



TYP. 6'-0" BLK. WALL CONSTRUCTION  
SCALE 1"=1'-0"

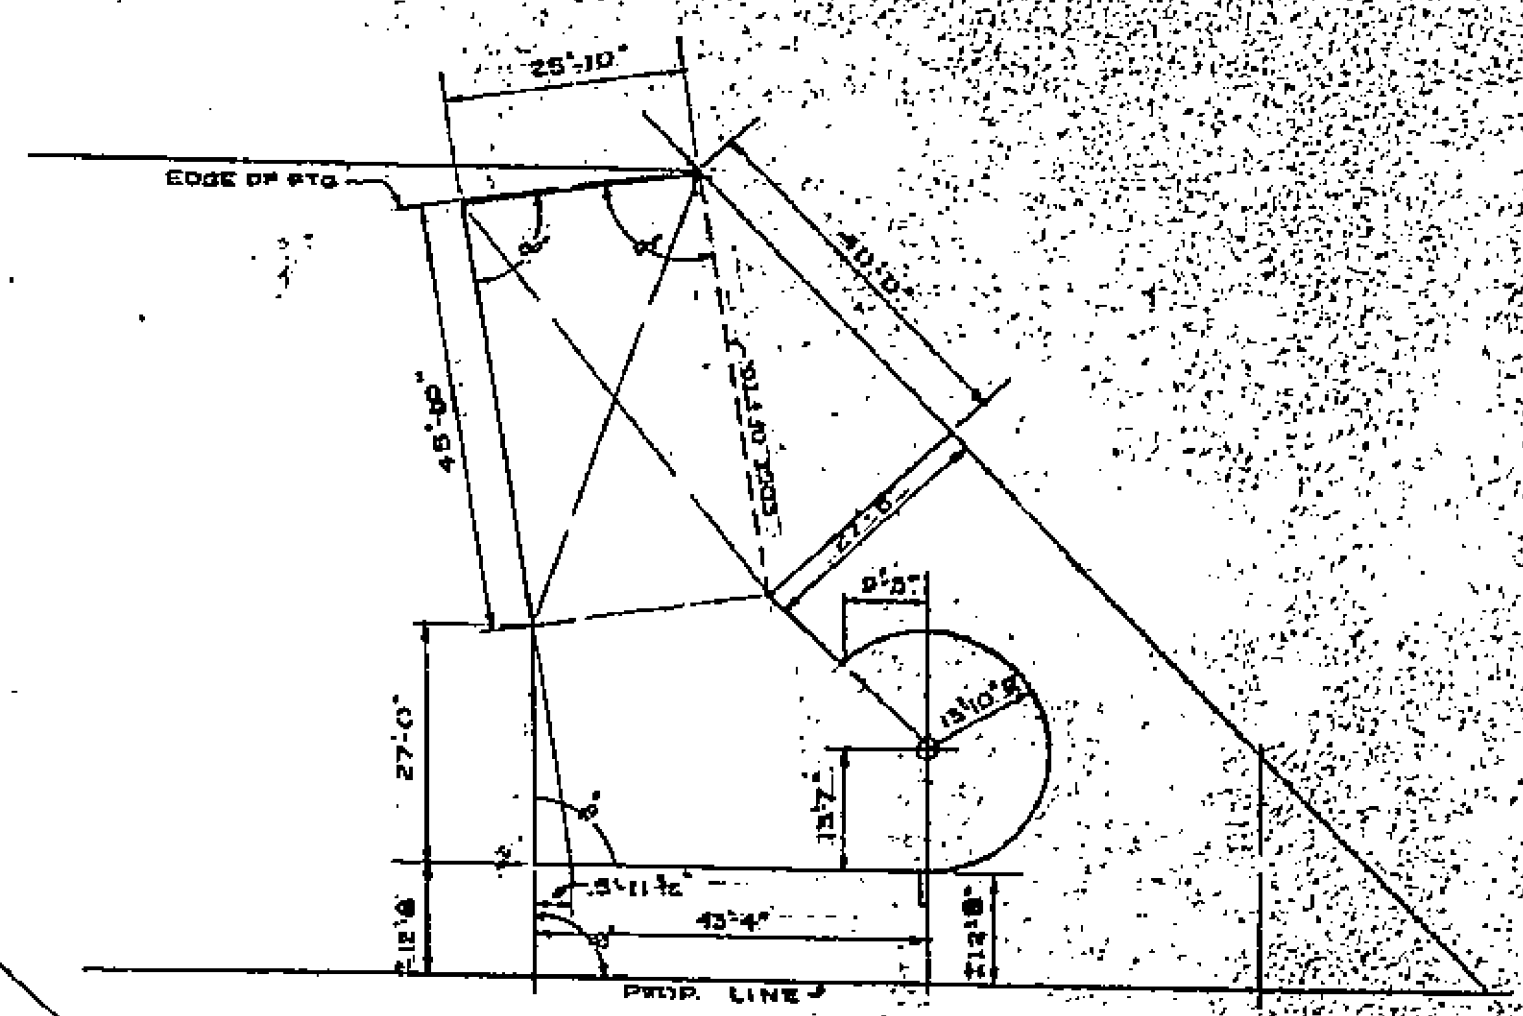

LAYOUT PLAN  
SCALE 1"=20'-0"

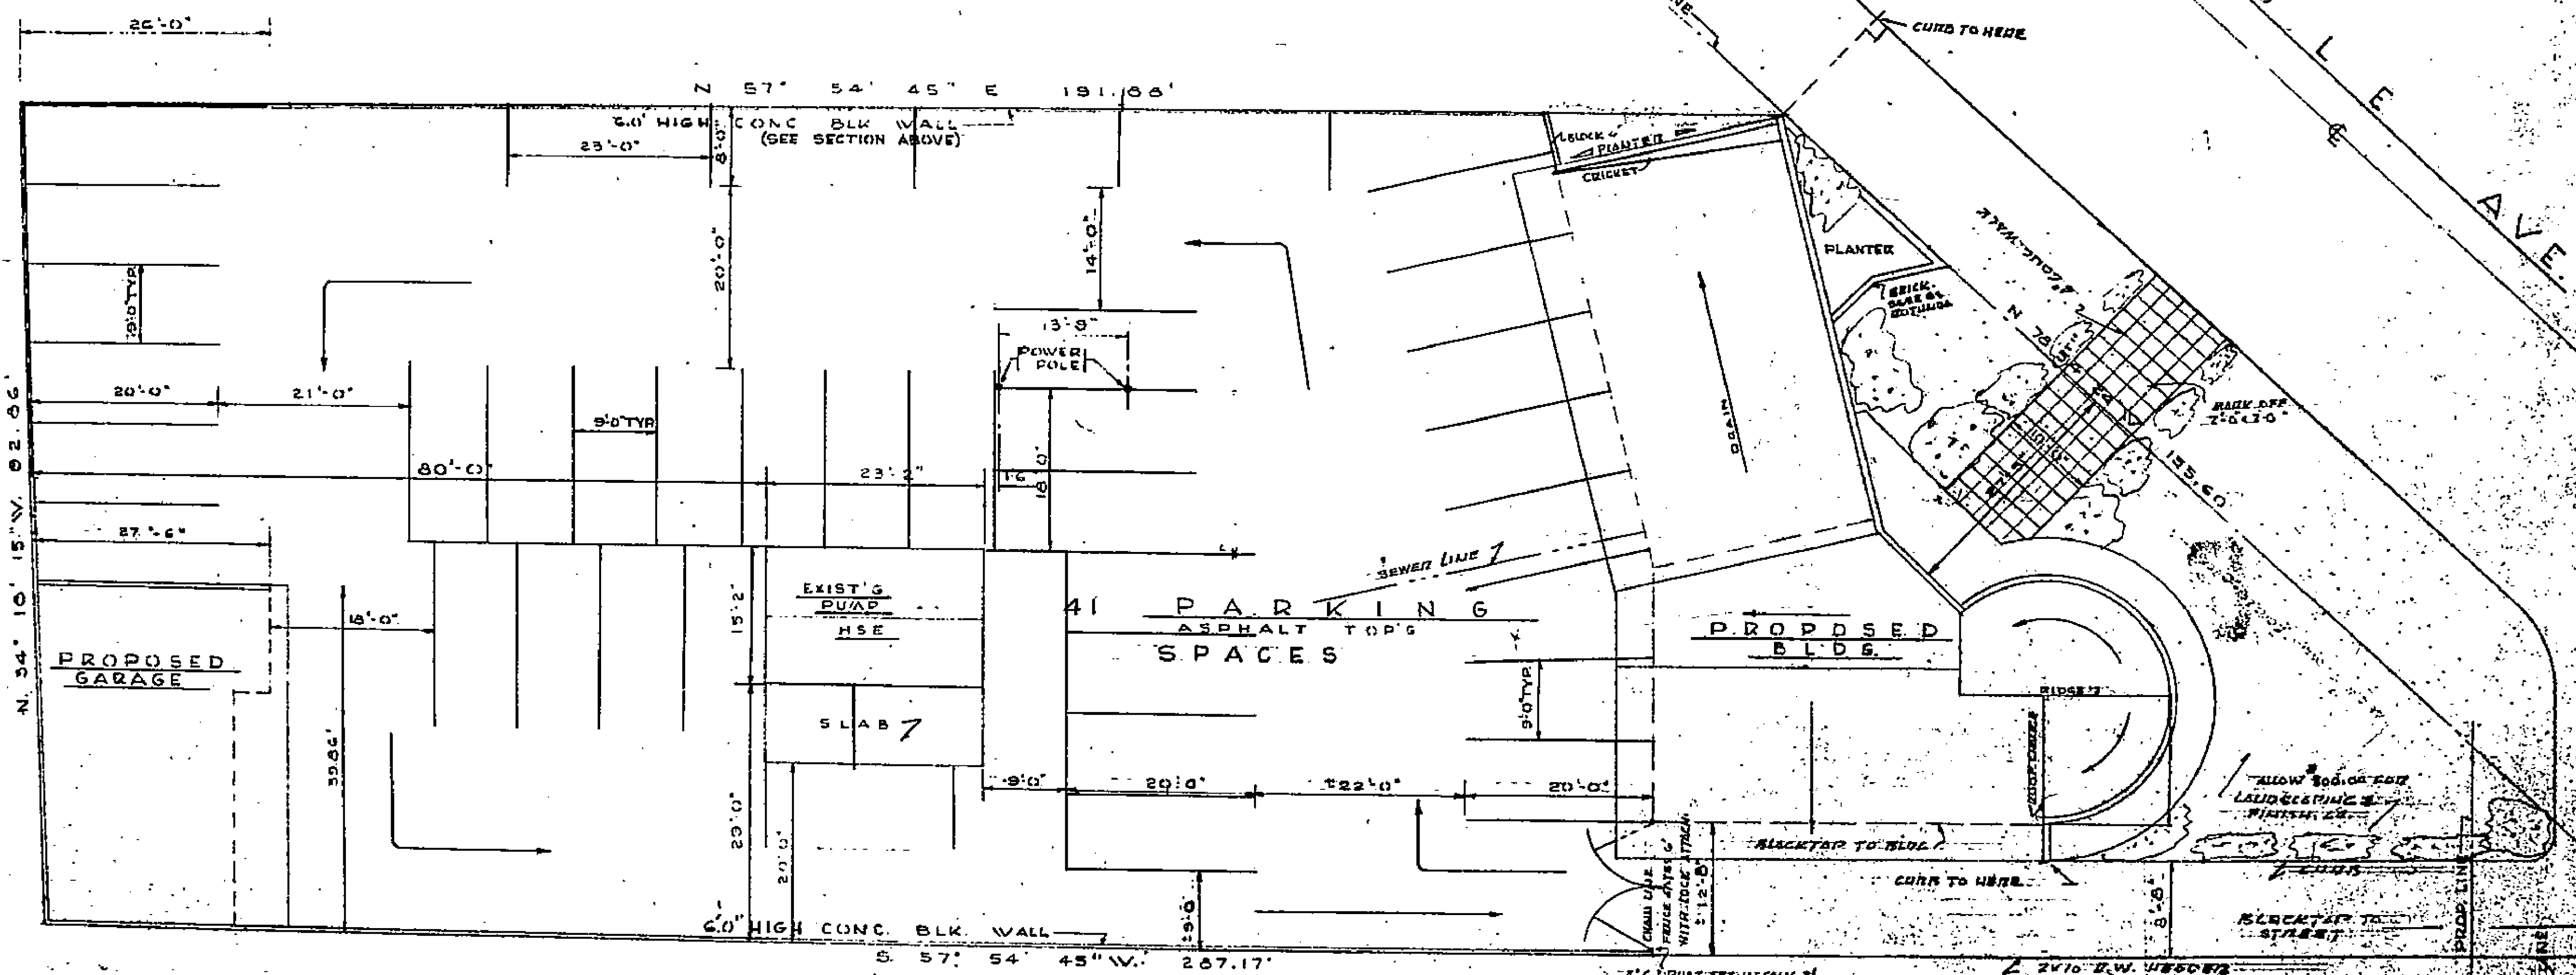

1,422.0' OF 6" DIA. CONC. BLK. WALL, 6.00' HIGH  
SEAL TOP & FILL IF NECESSARY TO PROVIDE 1% SLOPE - 1%  
PAVING CONTRACTOR TO PAINT PARKING LINE LOCATIONS

PARKING LOT PLAN  
SCALE 1"=10'-0"



Handwritten notes and calculations:  
 90  
 50  
 140  
 155  
 275  
 110  
 10 = 5  
 170  
 130  
 140  
 130  
 140

1691


RIVERSIDE ENGINEERING CO  
 1142 WEST 11TH STREET  
 RIVERSIDE, CALIF.

REVISIONS	
NO.	DATE
1	
2	
3	
4	
5	




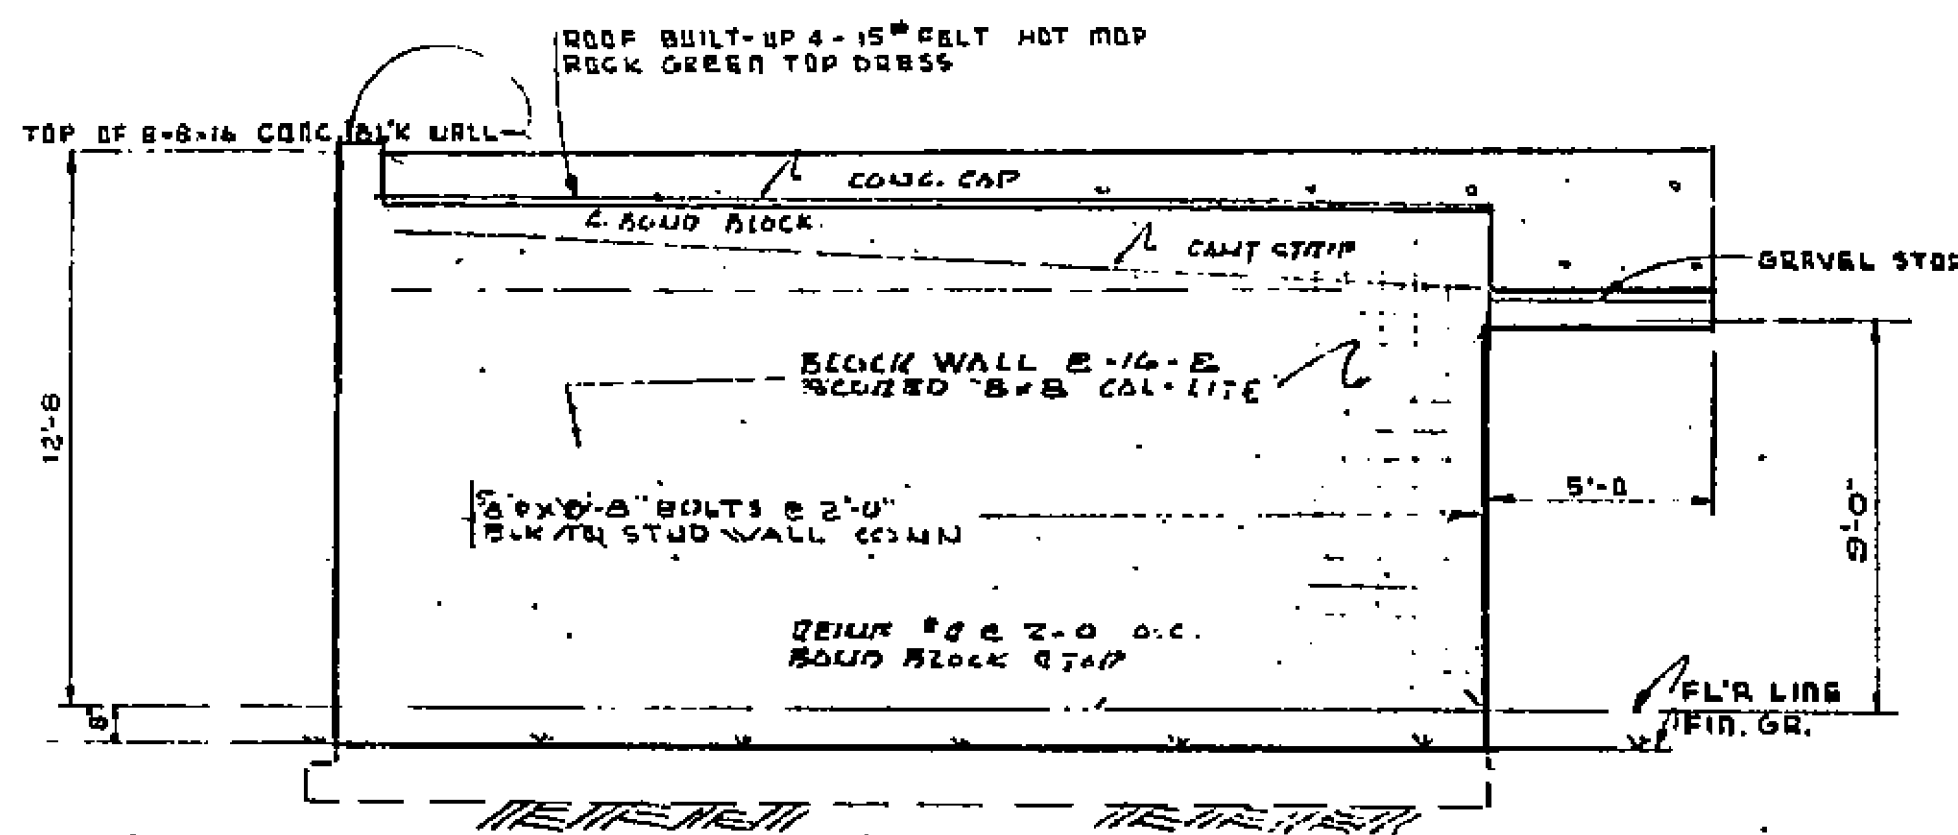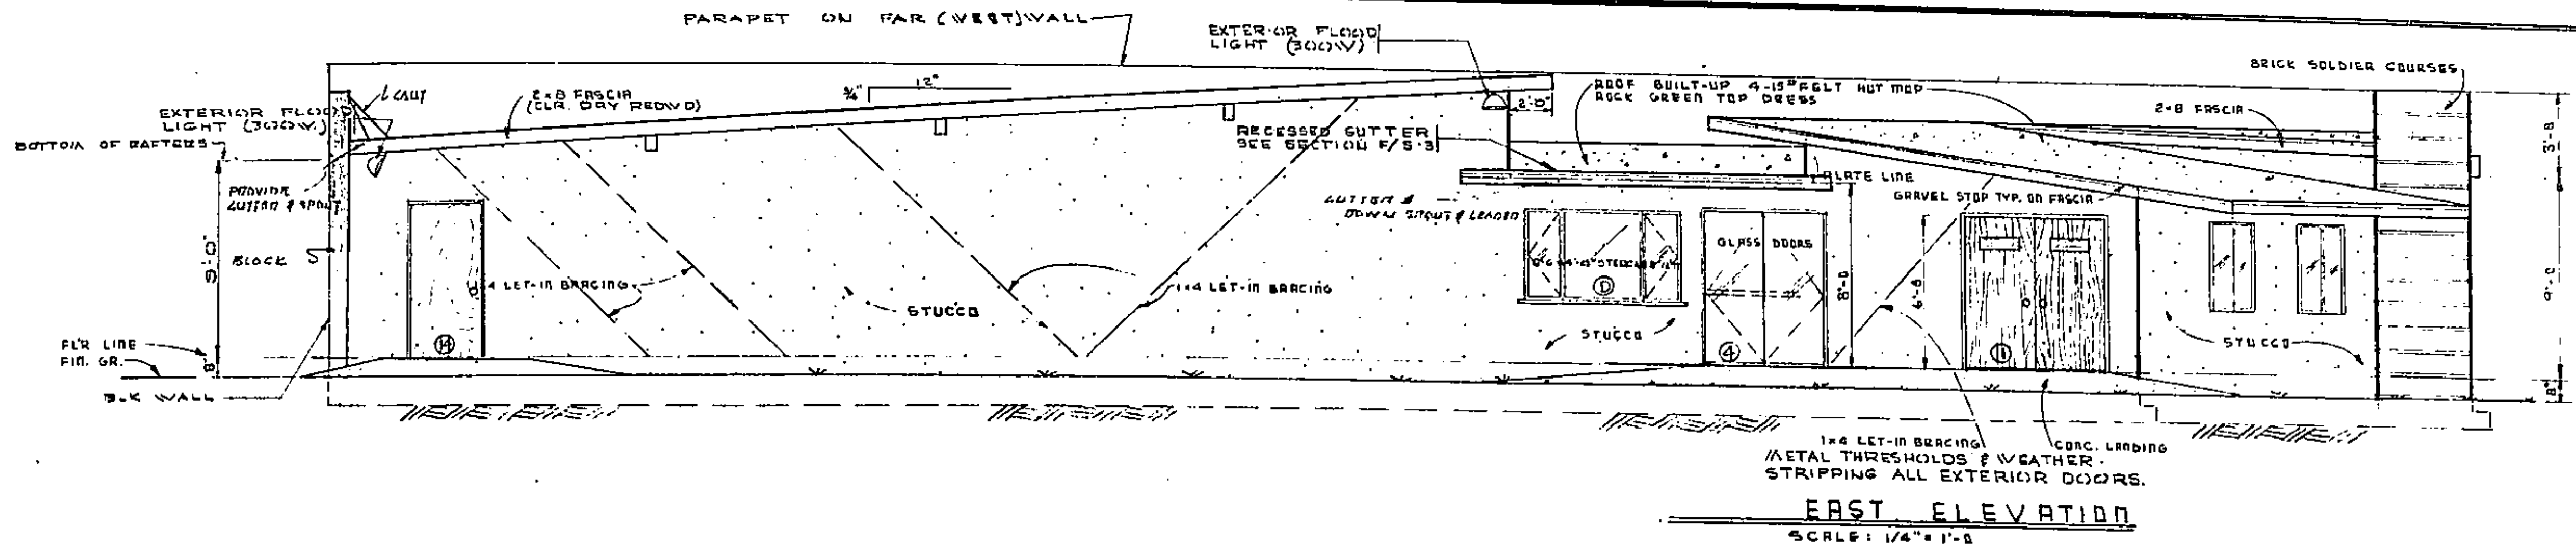



**SOUTH ELEVATION**  
SCALE: 1/4" = 1'-0"

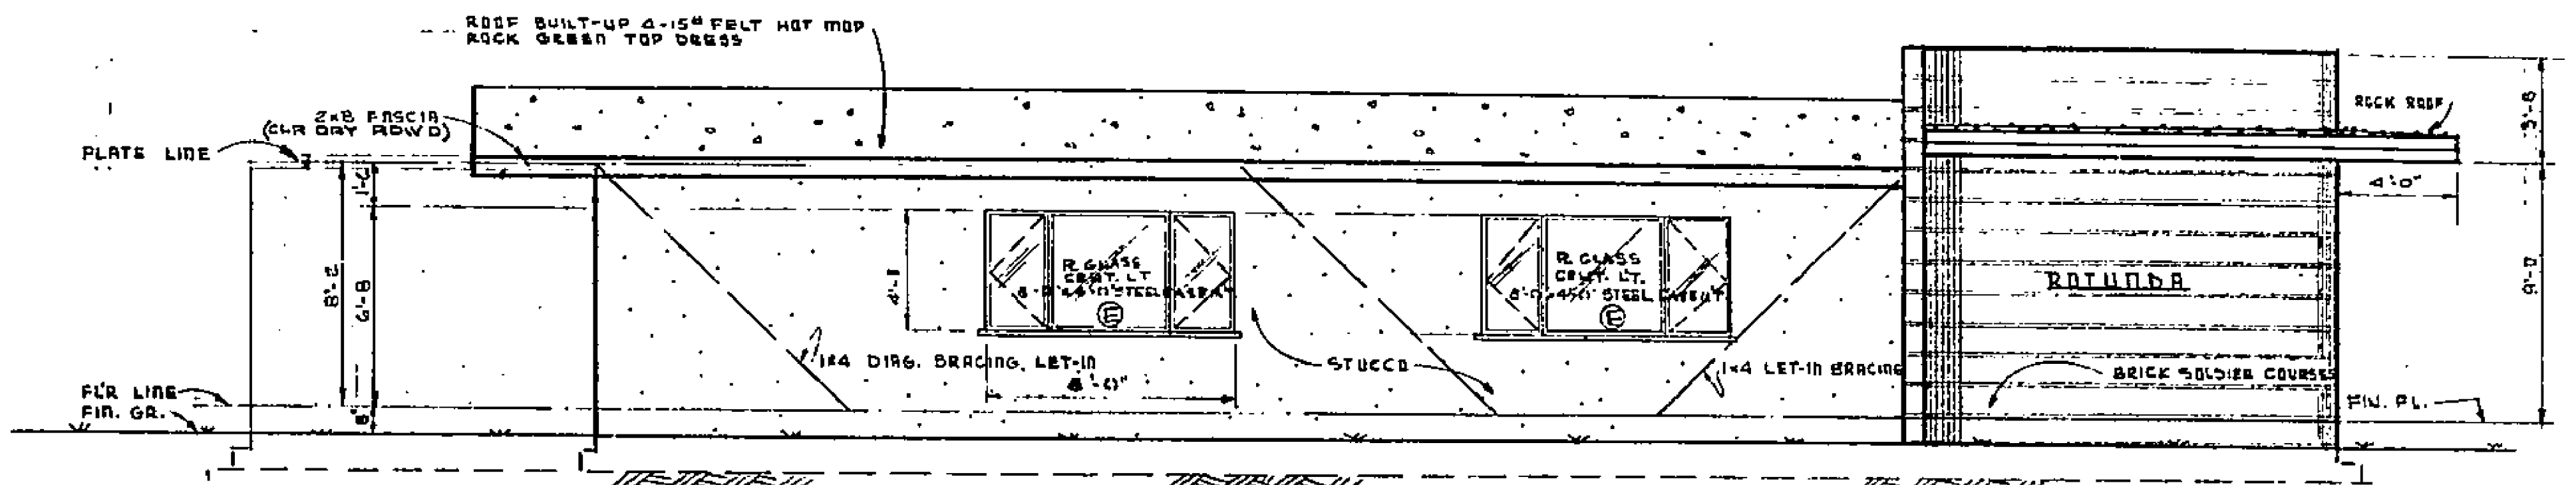

**NORTH ELEVATION**  
SCALE: 1/4" = 1'-0"

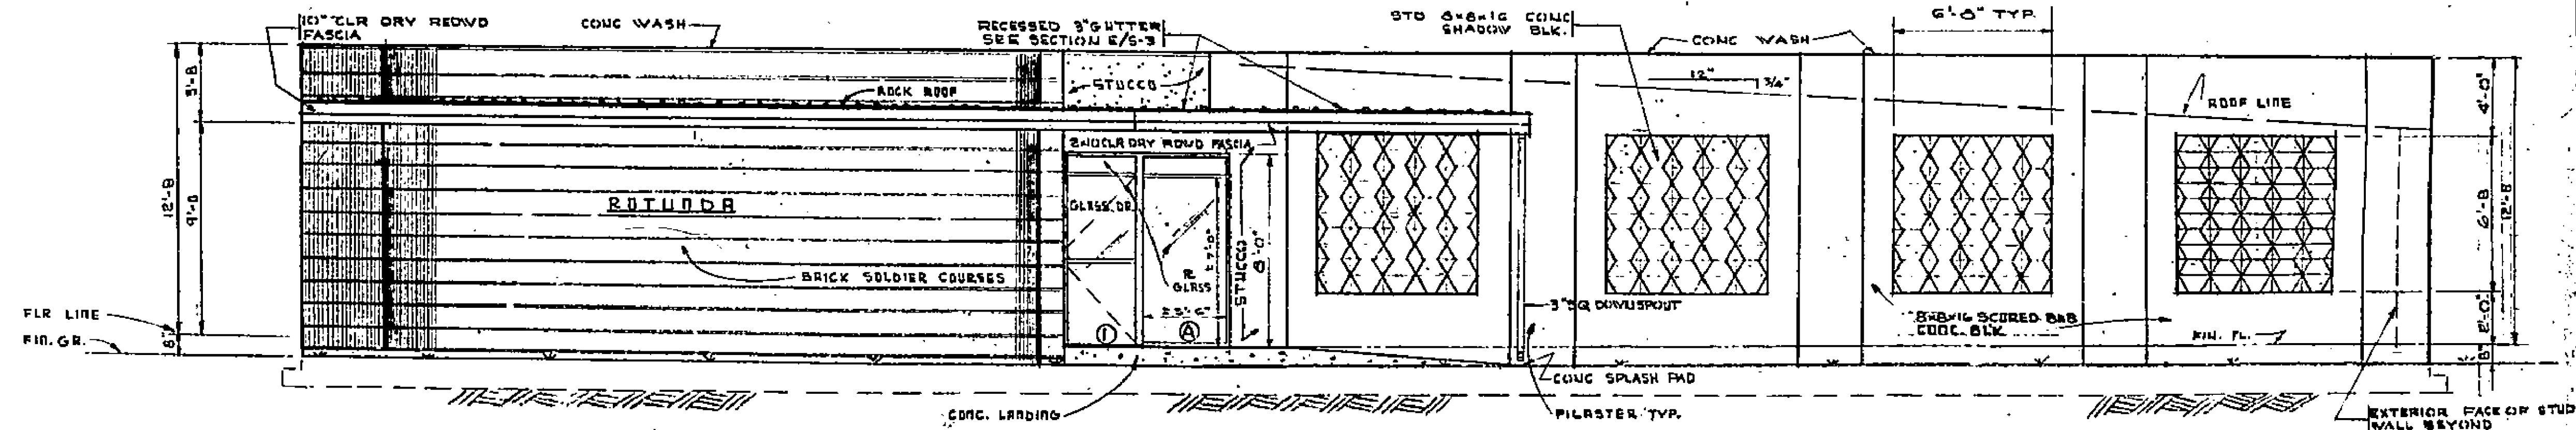

**WEST ELEVATION**  
SCALE: 1/4" = 1'-0"

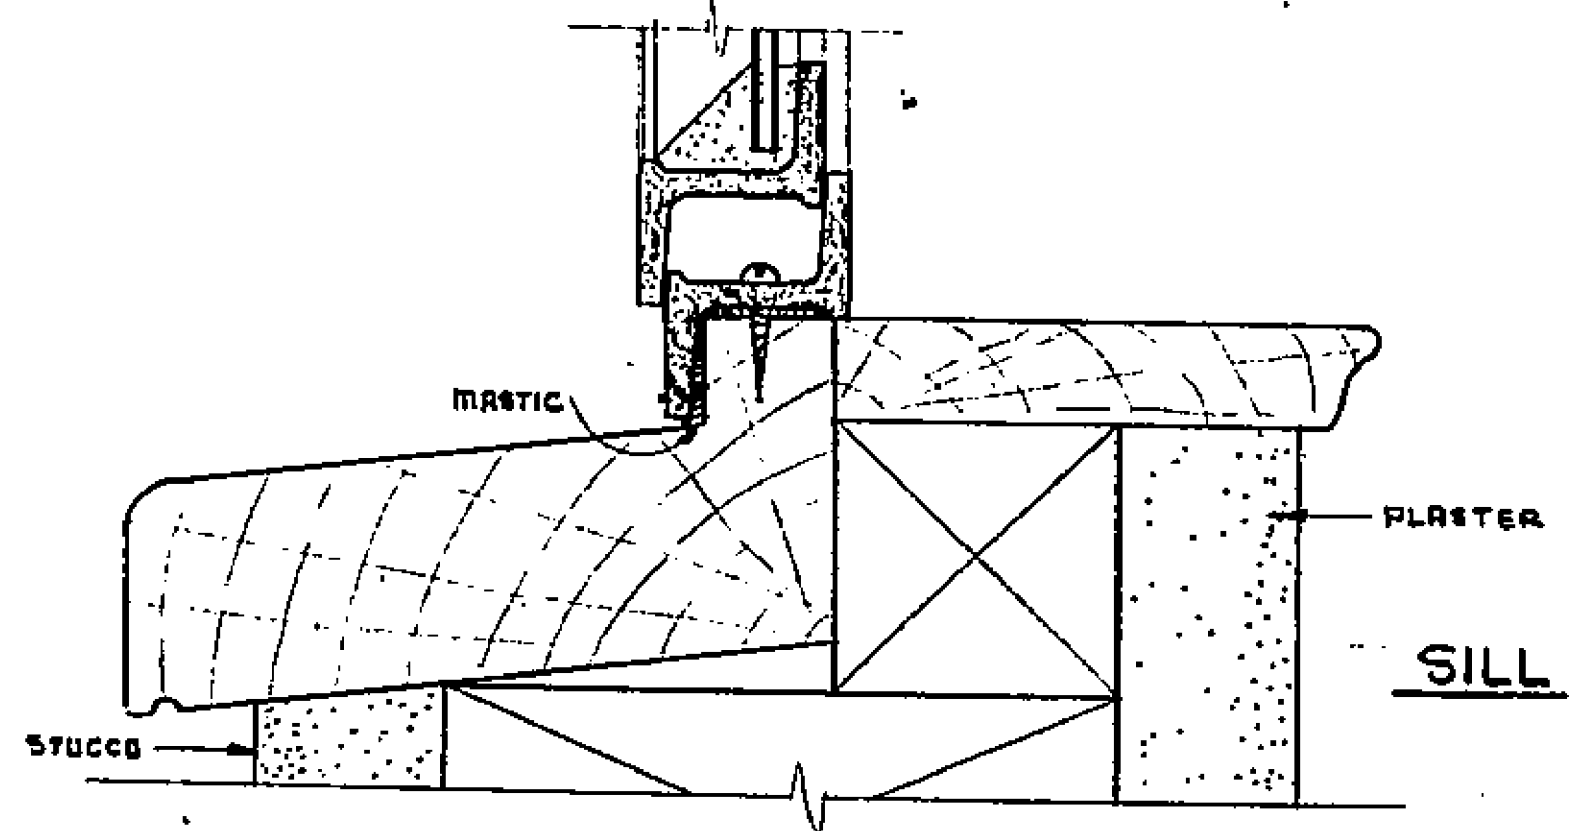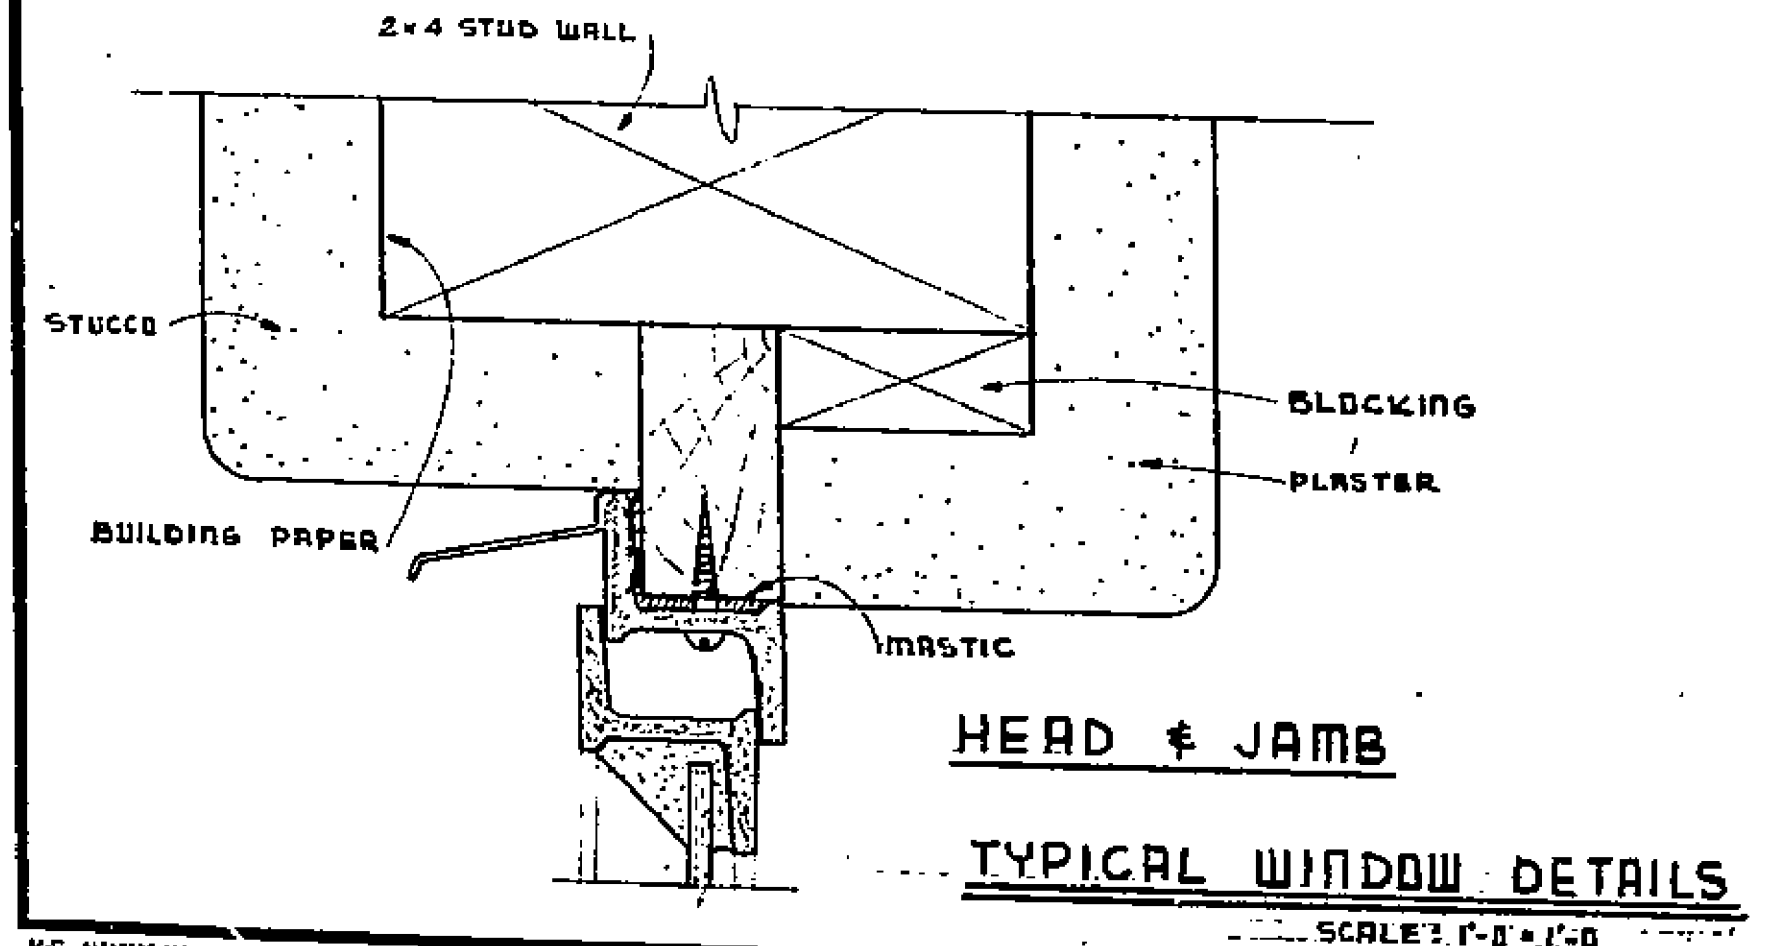

1691

REVISIONS		
No.	DATE	MARK
1		
2		
3		
4		
5		
6		

**RIVERSIDE ENGINEERING CO.**  
4144 ORANGE STREET  
RIVERSIDE, CALIFORNIA

FOR COMMUNITY SERVICE ADDRESS LA SIERRA, CALIF.

DRAWN BY: P. J. B. CHECKED BY: SCALE: LISTED



DATE: 7/2/38

CIVIL ENGINEER NO. 1126  
STRUCTURAL ENGINEER NO. 225  
MECHANICAL ENGINEER NO. 202

JOB No. 2156 FIELD BOOK No. SHEET 13 OF 18





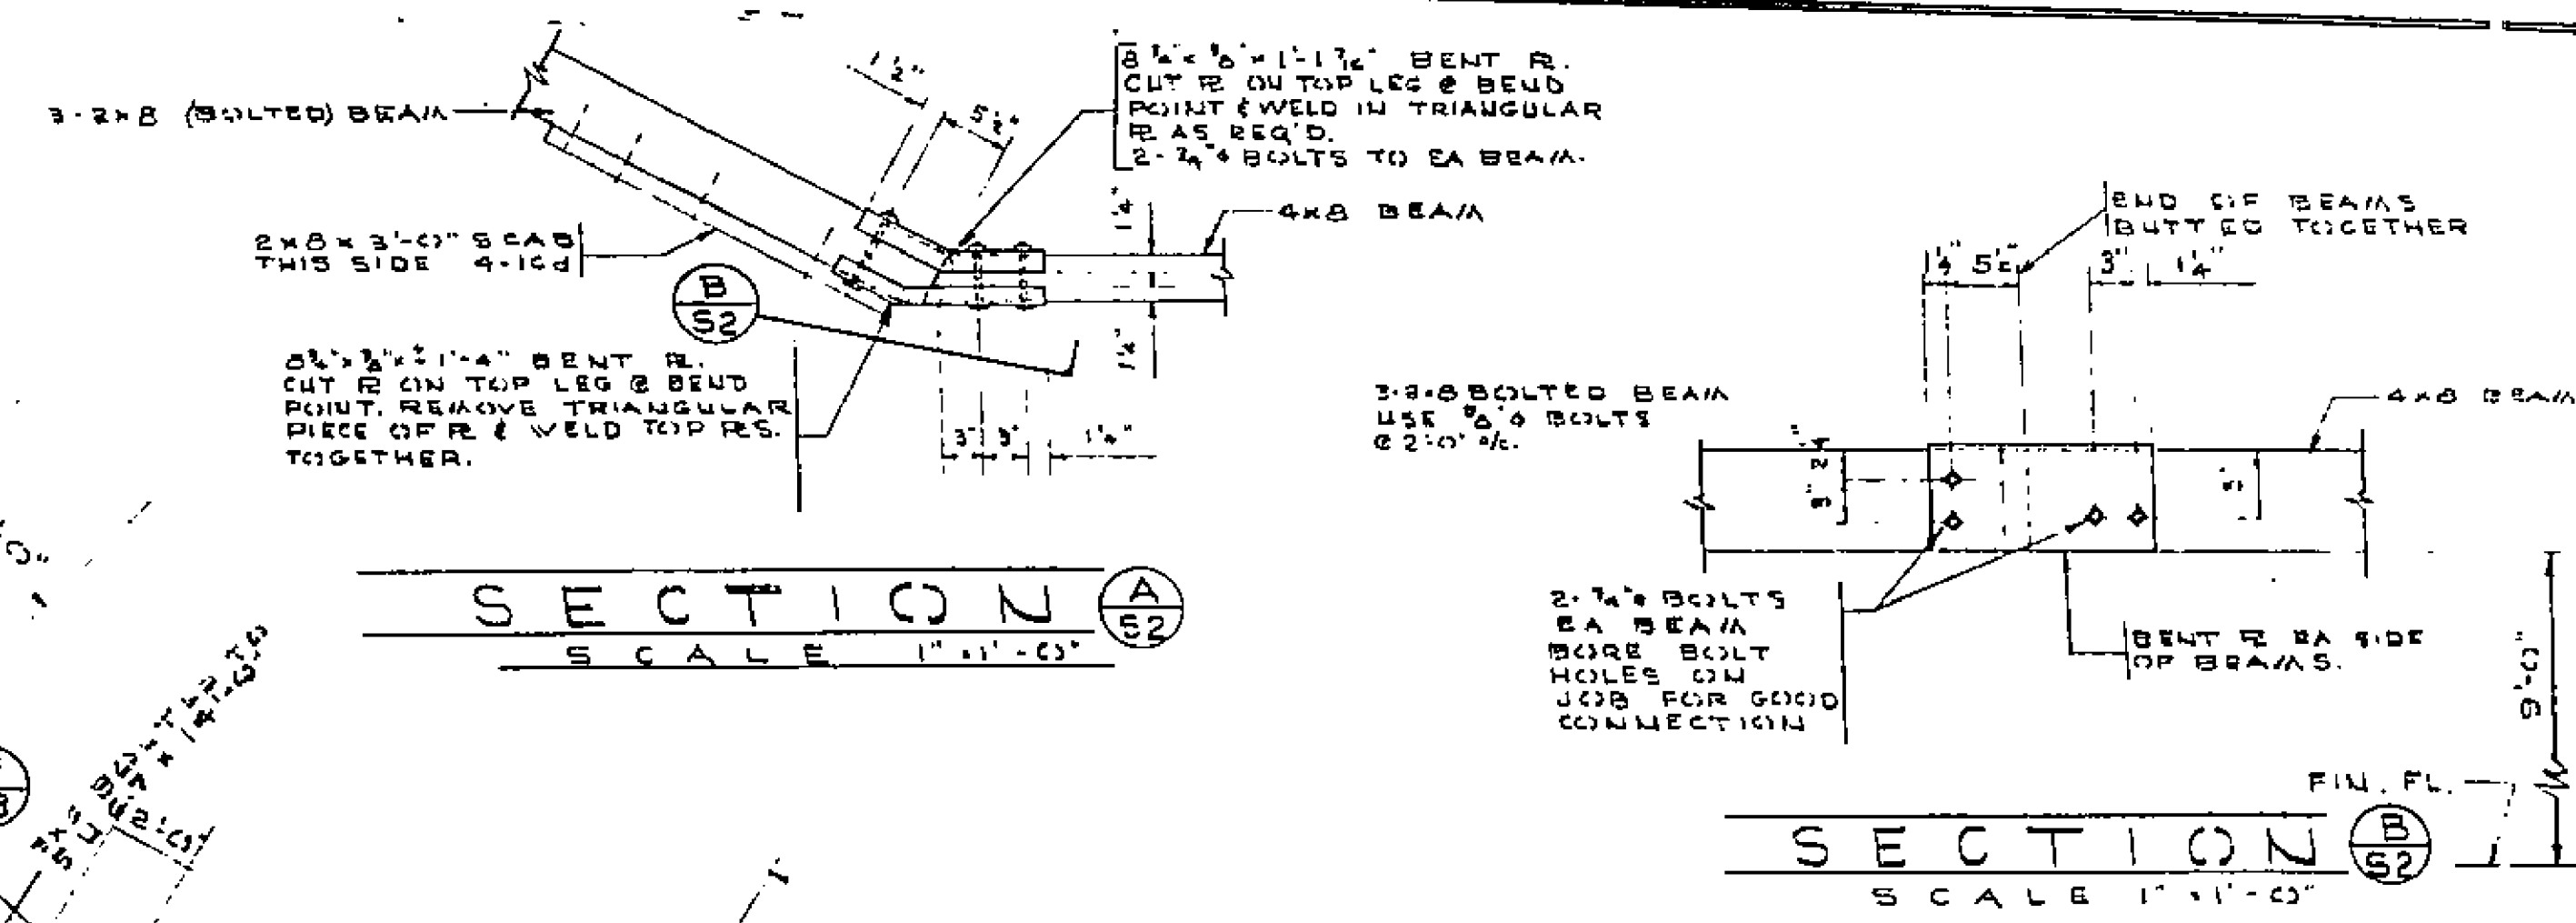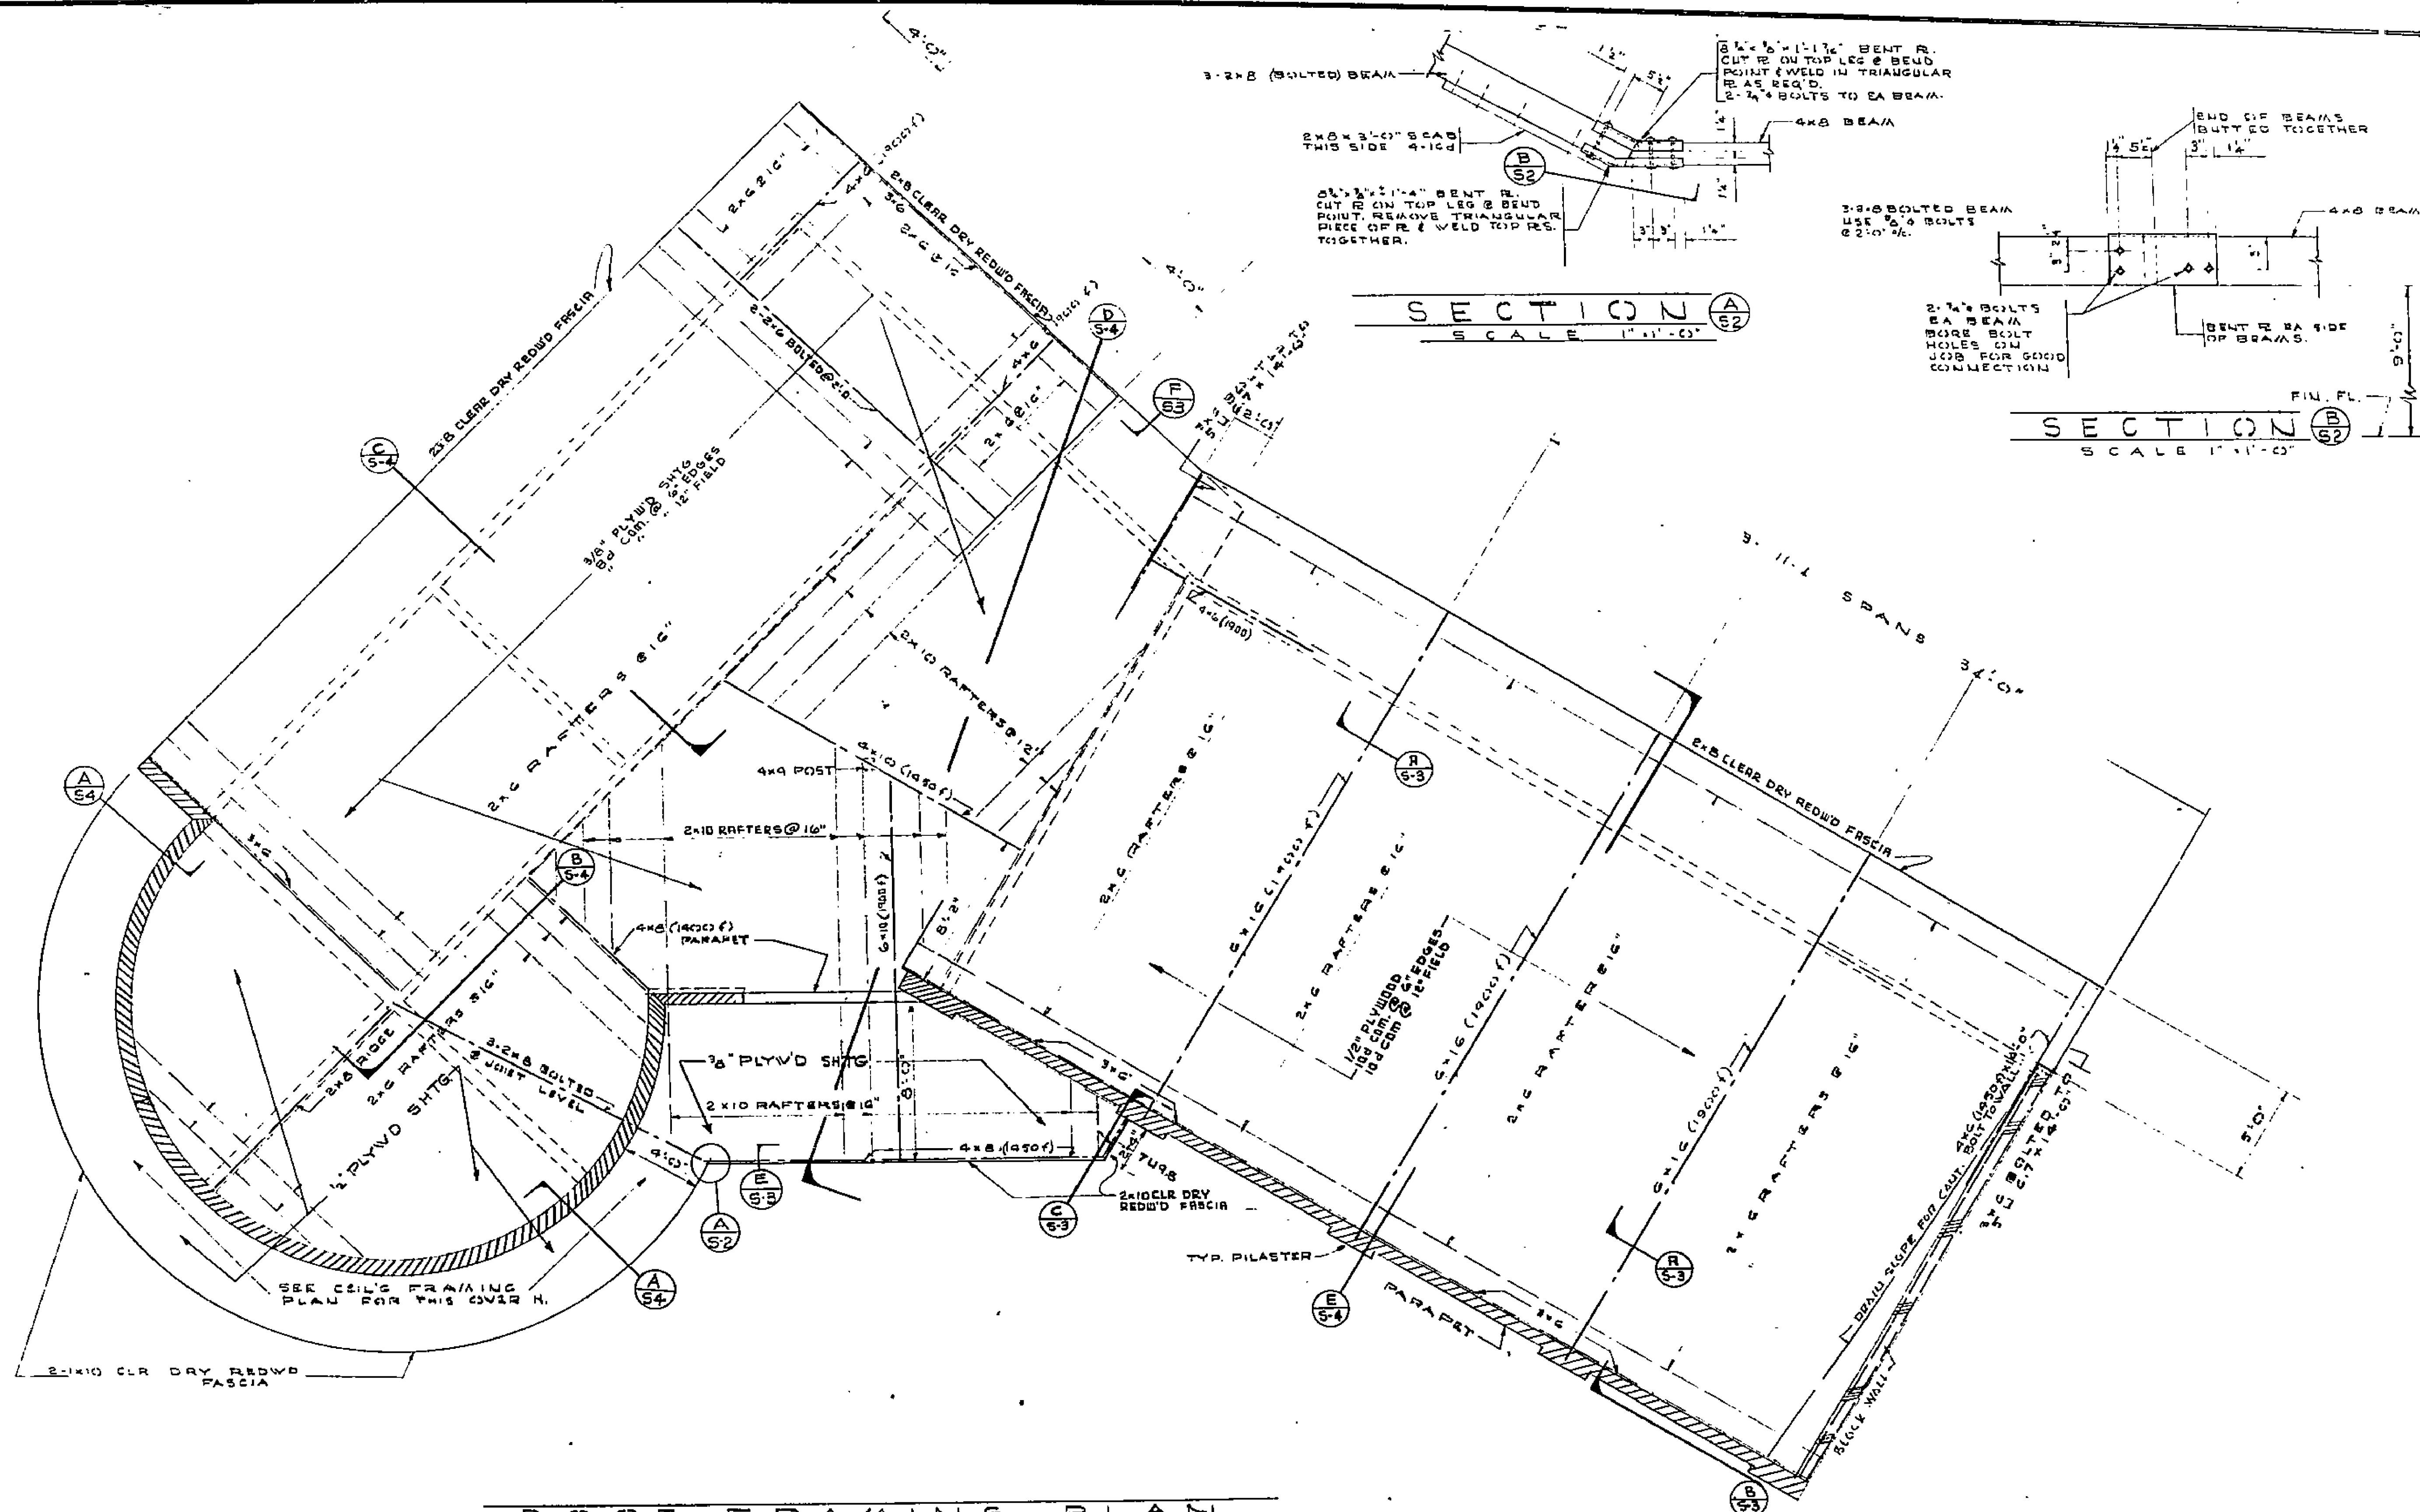

**ROOF FRAMING PLAN**  
SCALE 1/4"=1'-0"


1691

**RIVERSIDE ENGINEERING CO.**  
2164 ORANGE STREET  
RIVERSIDE, CALIFORNIA


FOR: COMMUNITY SERVICE ADDRESS L.S. SIEMEN, CALIF.  
DRAWN BY: L. R. CHECKED BY: SCALE NOTED  
DATE: 7/2/58  
JOB No: 2156 FIELD BOOK No:          SHEET: 52 OF 18

REVISIONS		
No.	DATE	MARK
1		
2		
3		
4		
5		
6		




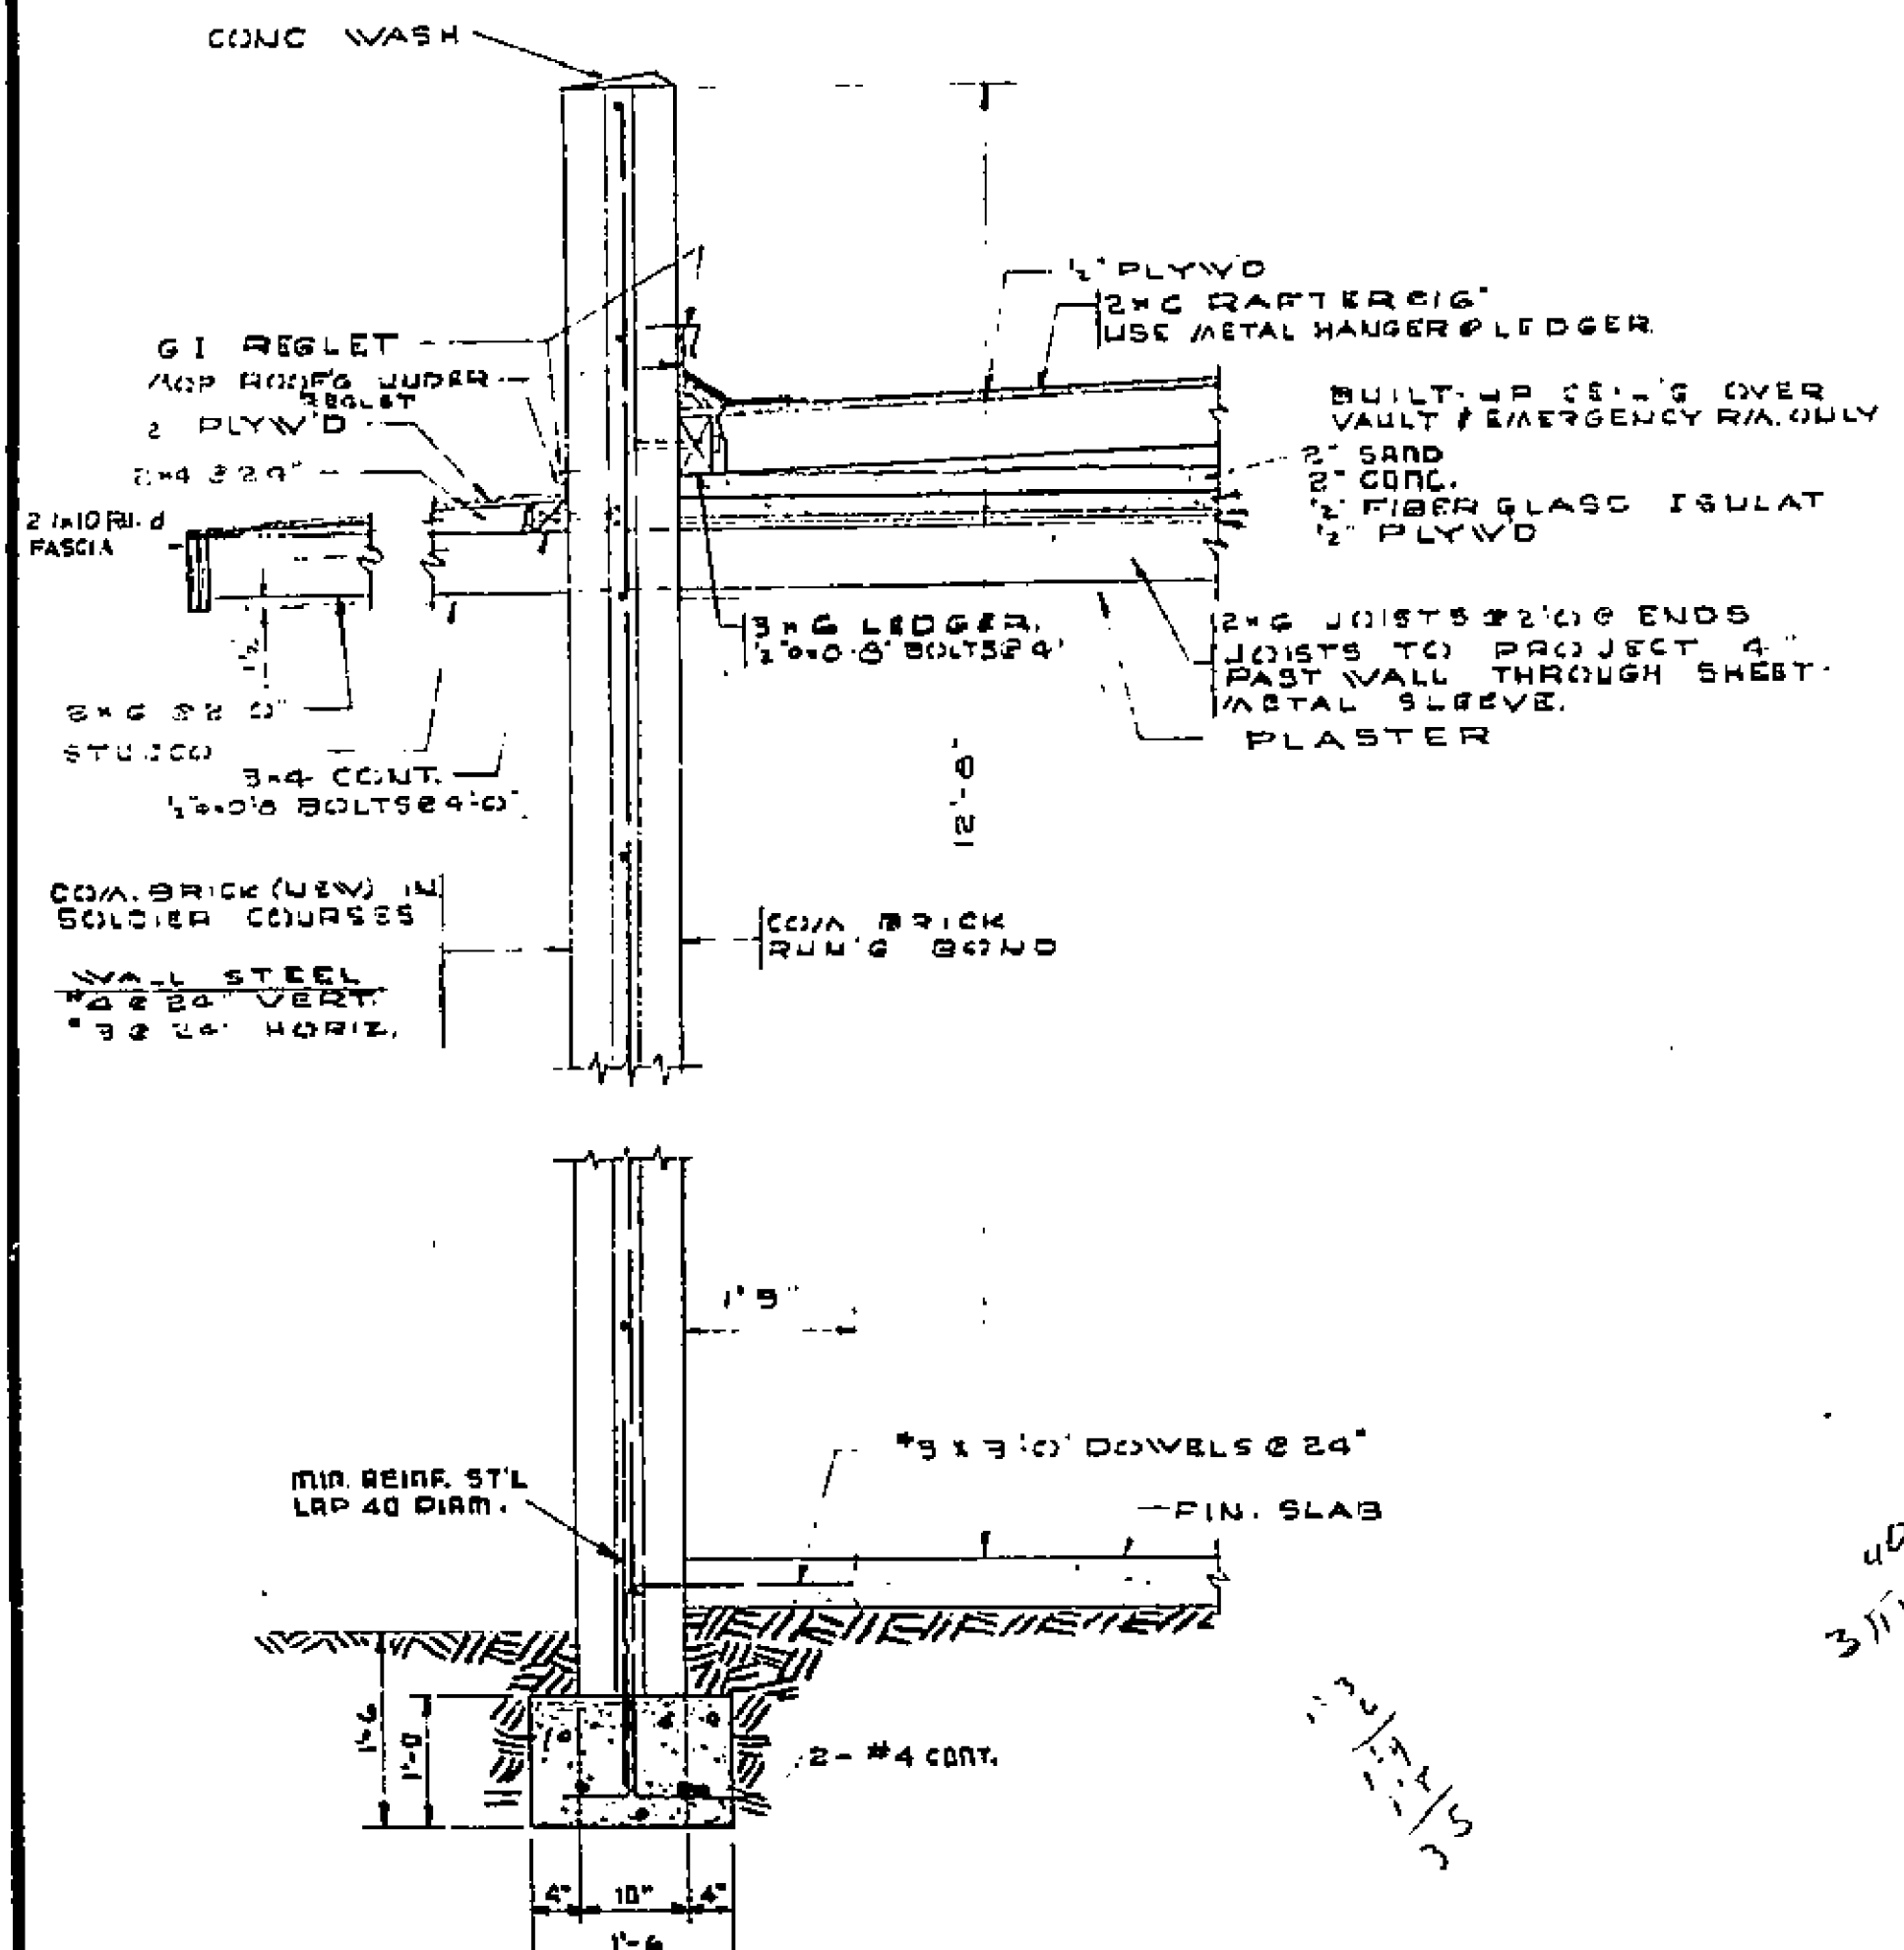

**SECTION B**  
SCALE: 3/4"=1'-0"

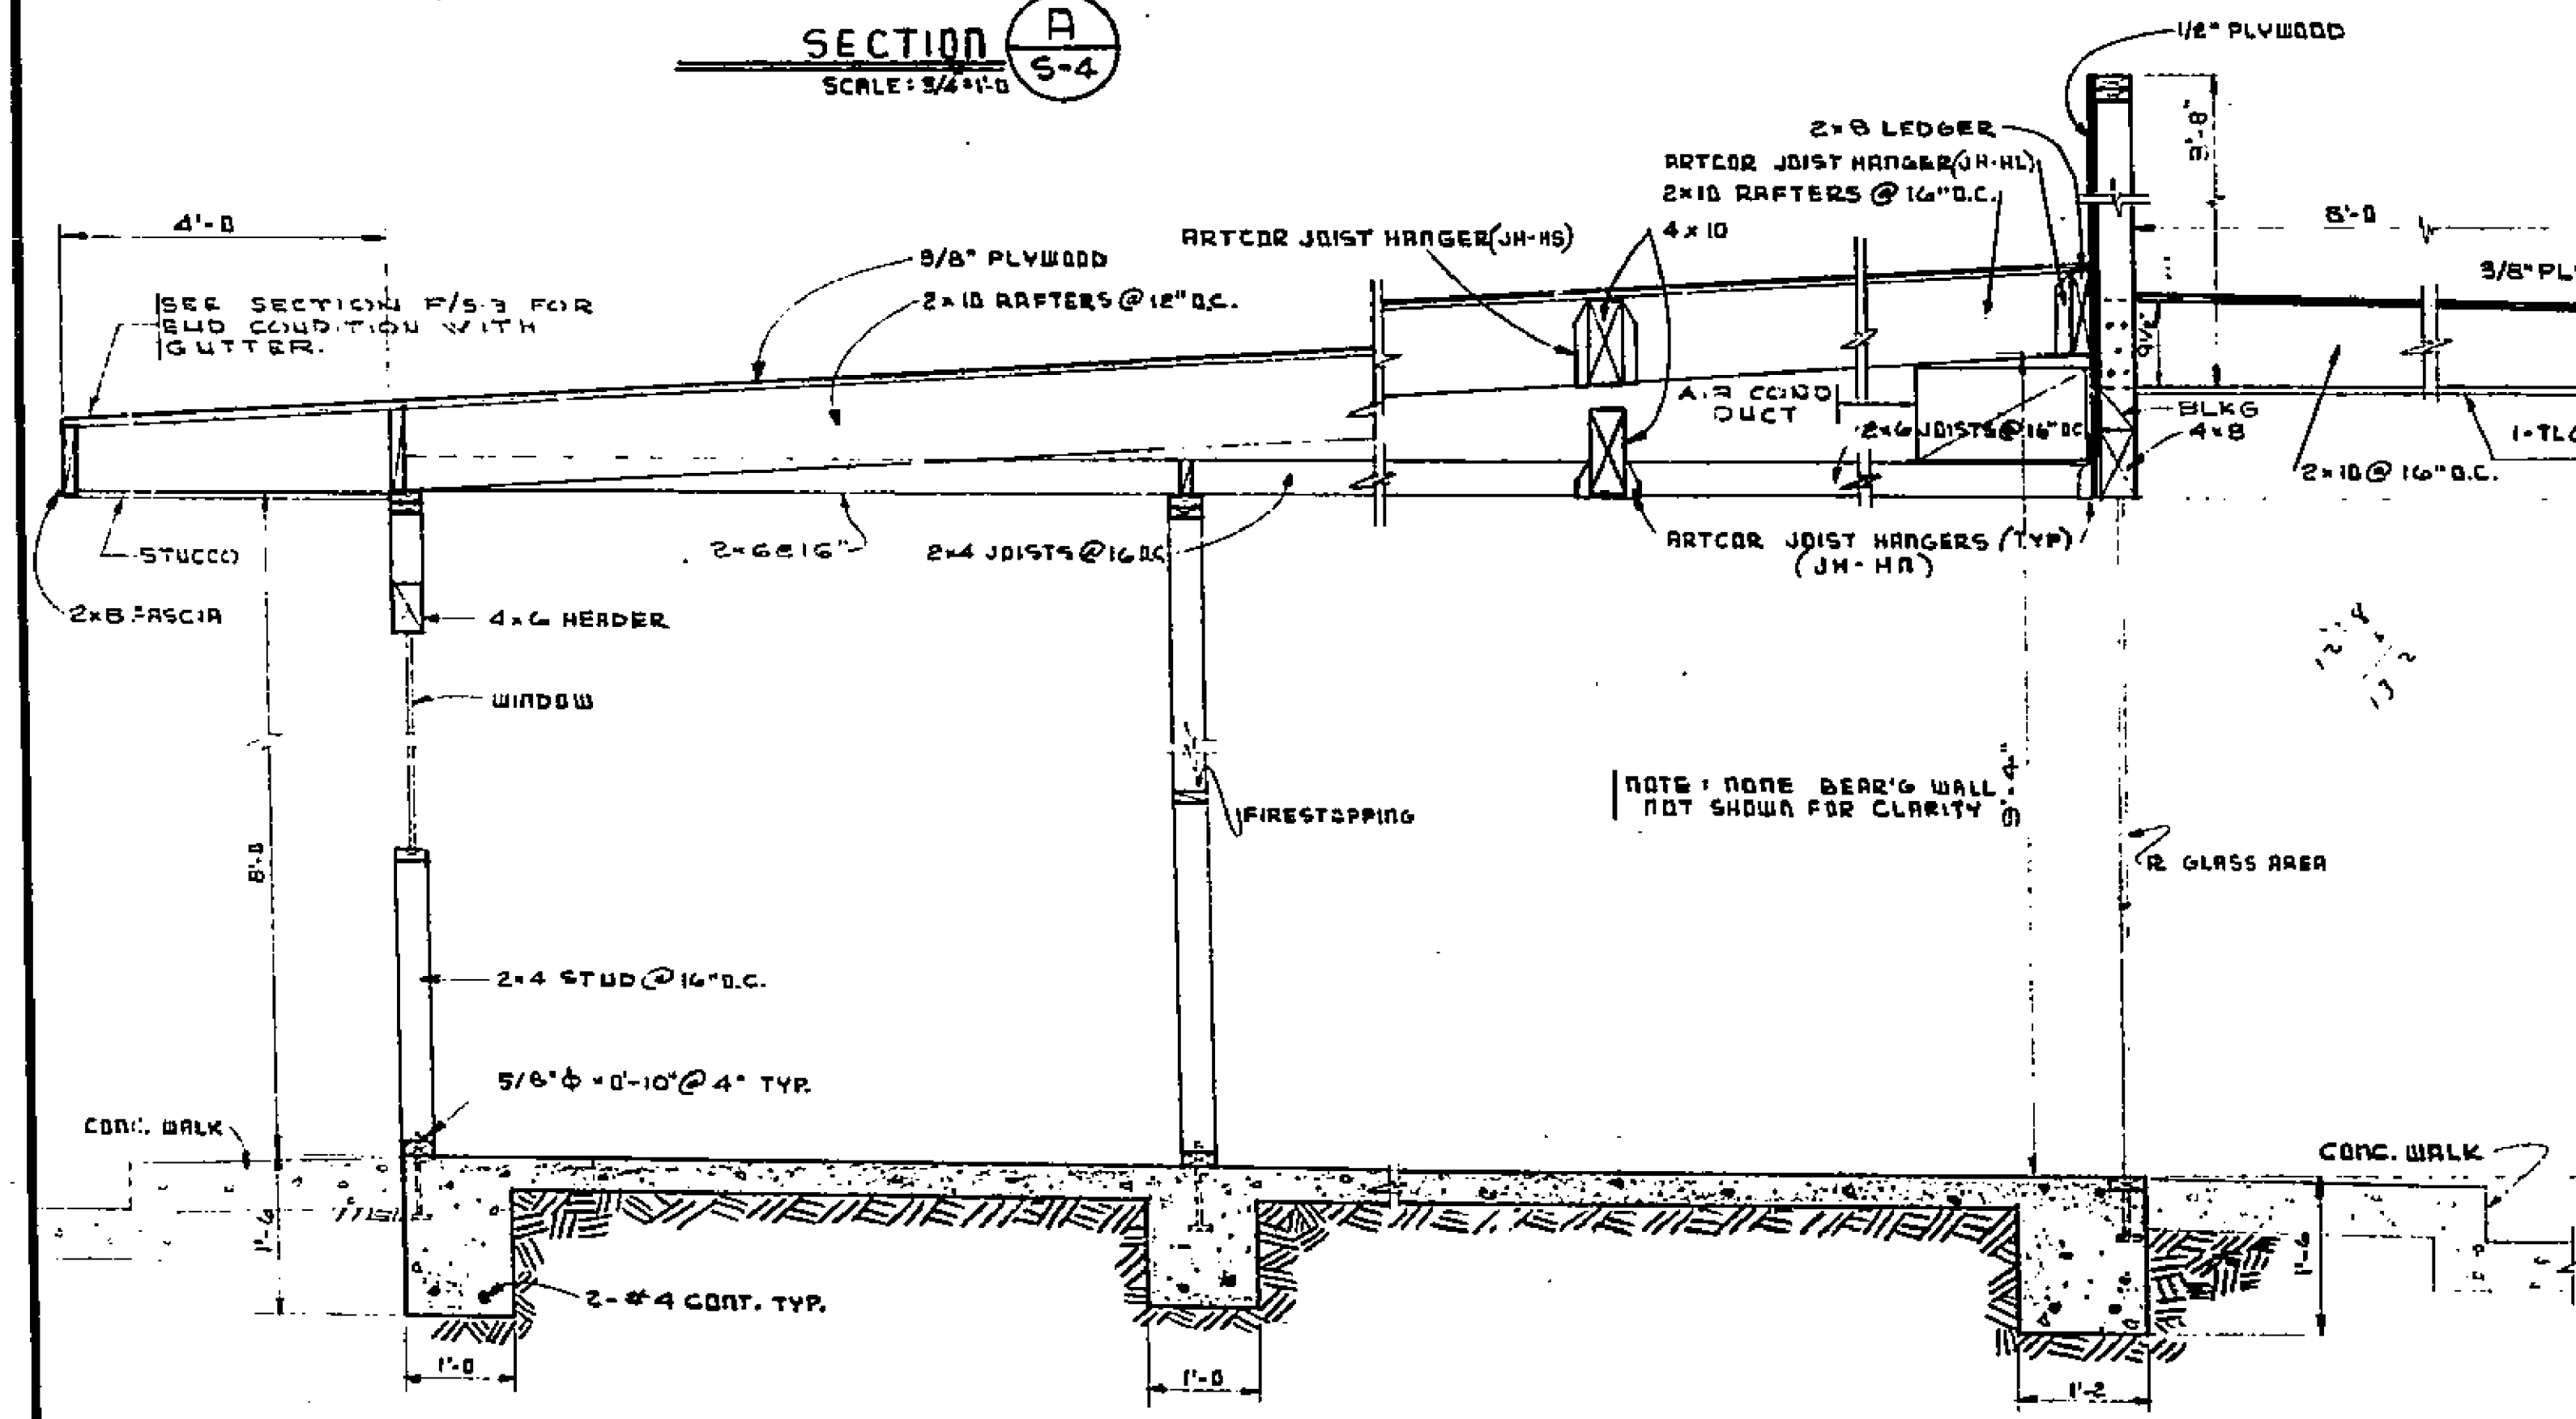


**SECTION D**  
SCALE: 3/4"=1'-0"

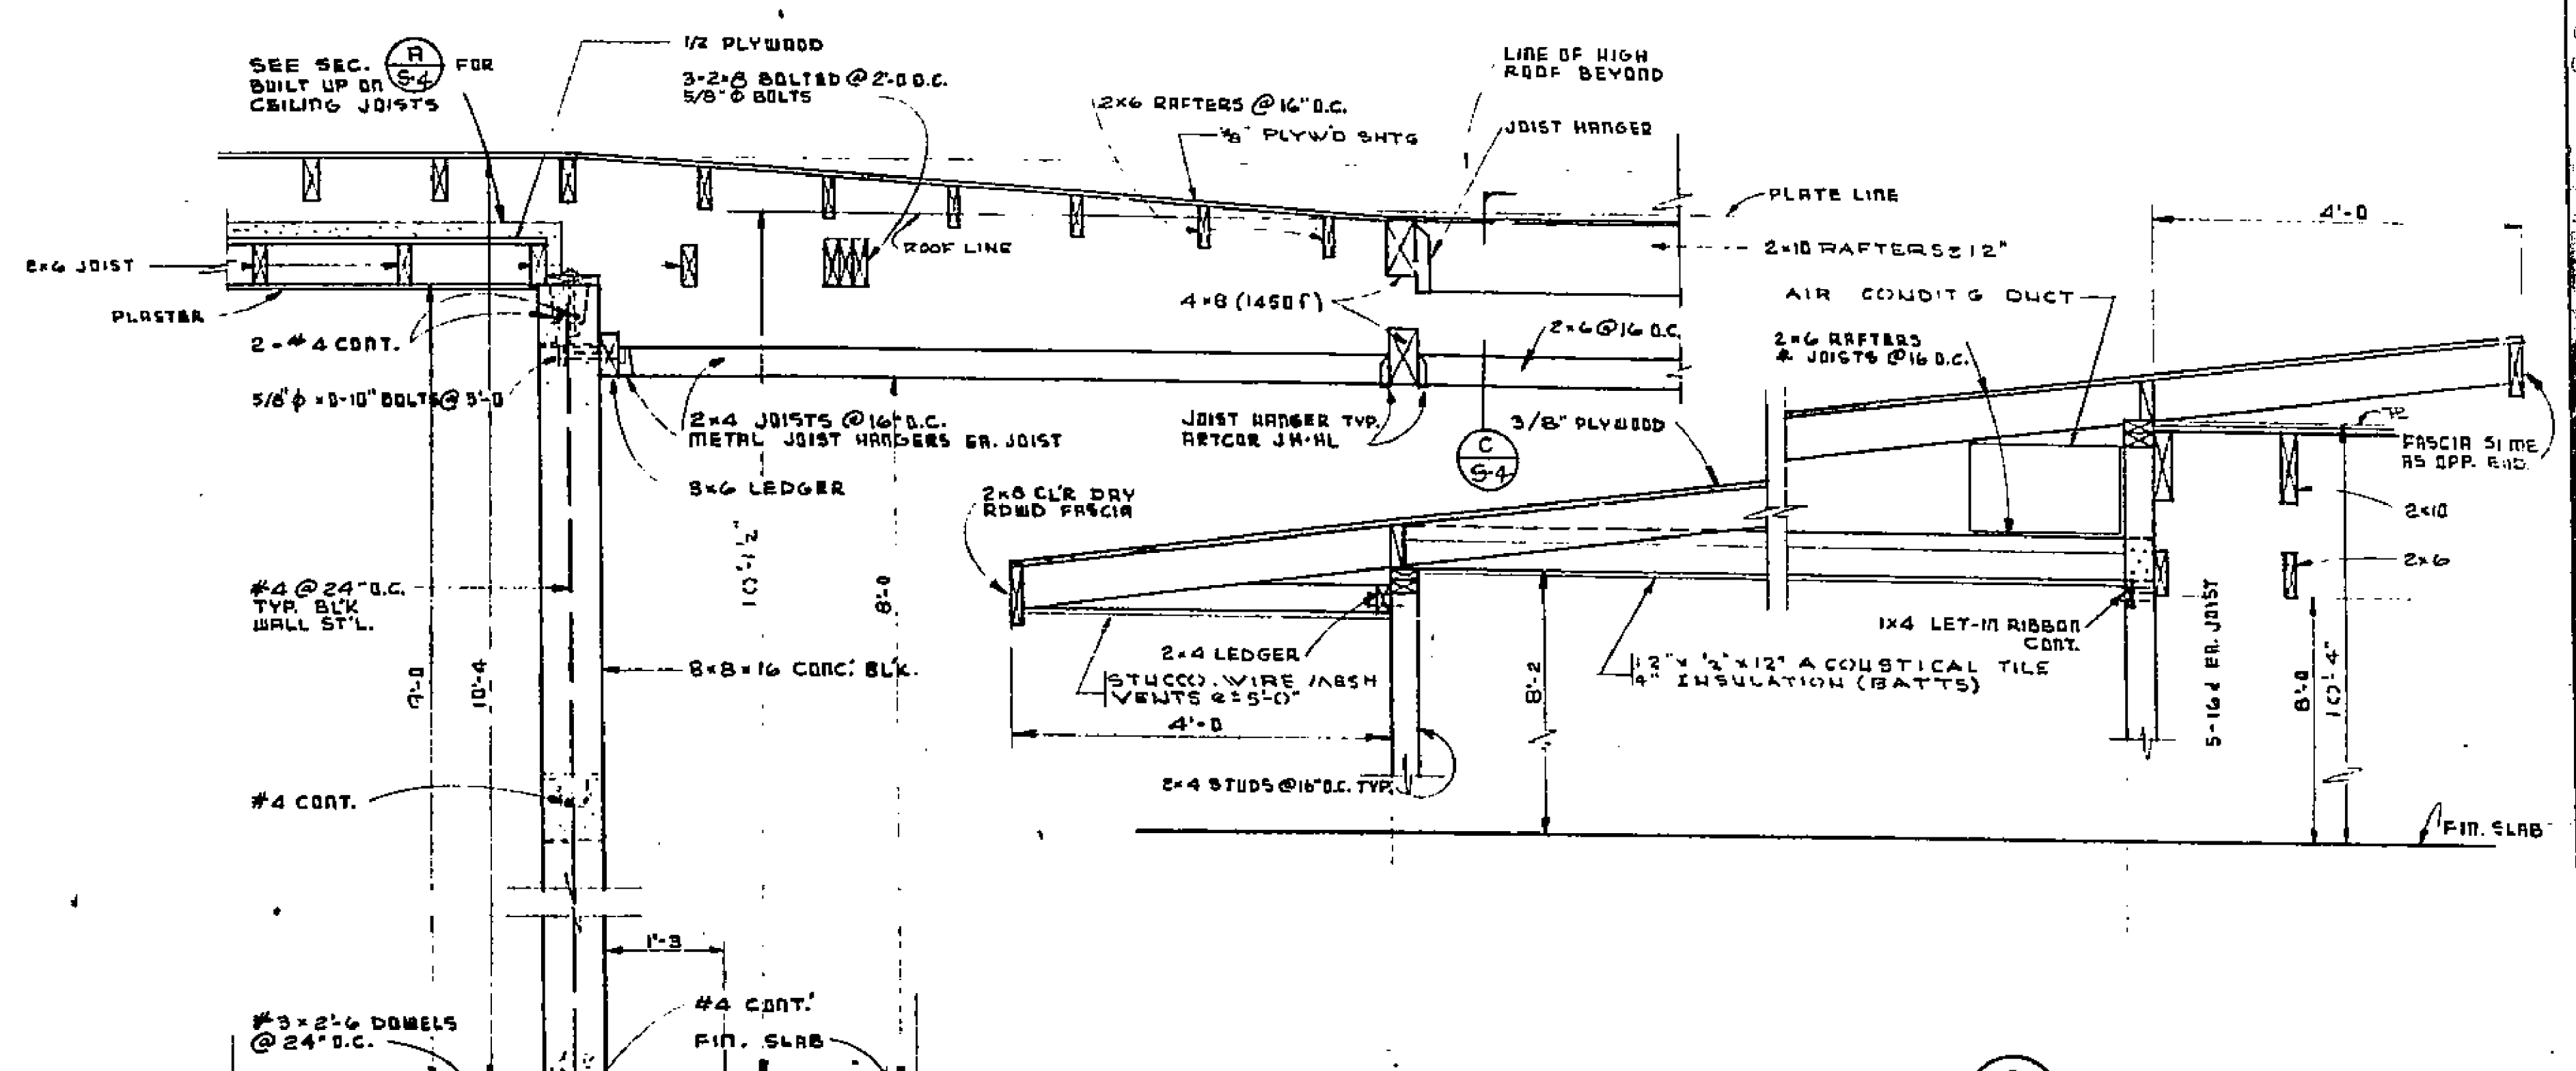

**SECTION C**  
SCALE: 3/4"=1'-0"

**SECTION B**  
SCALE: 3/4"=1'-0"

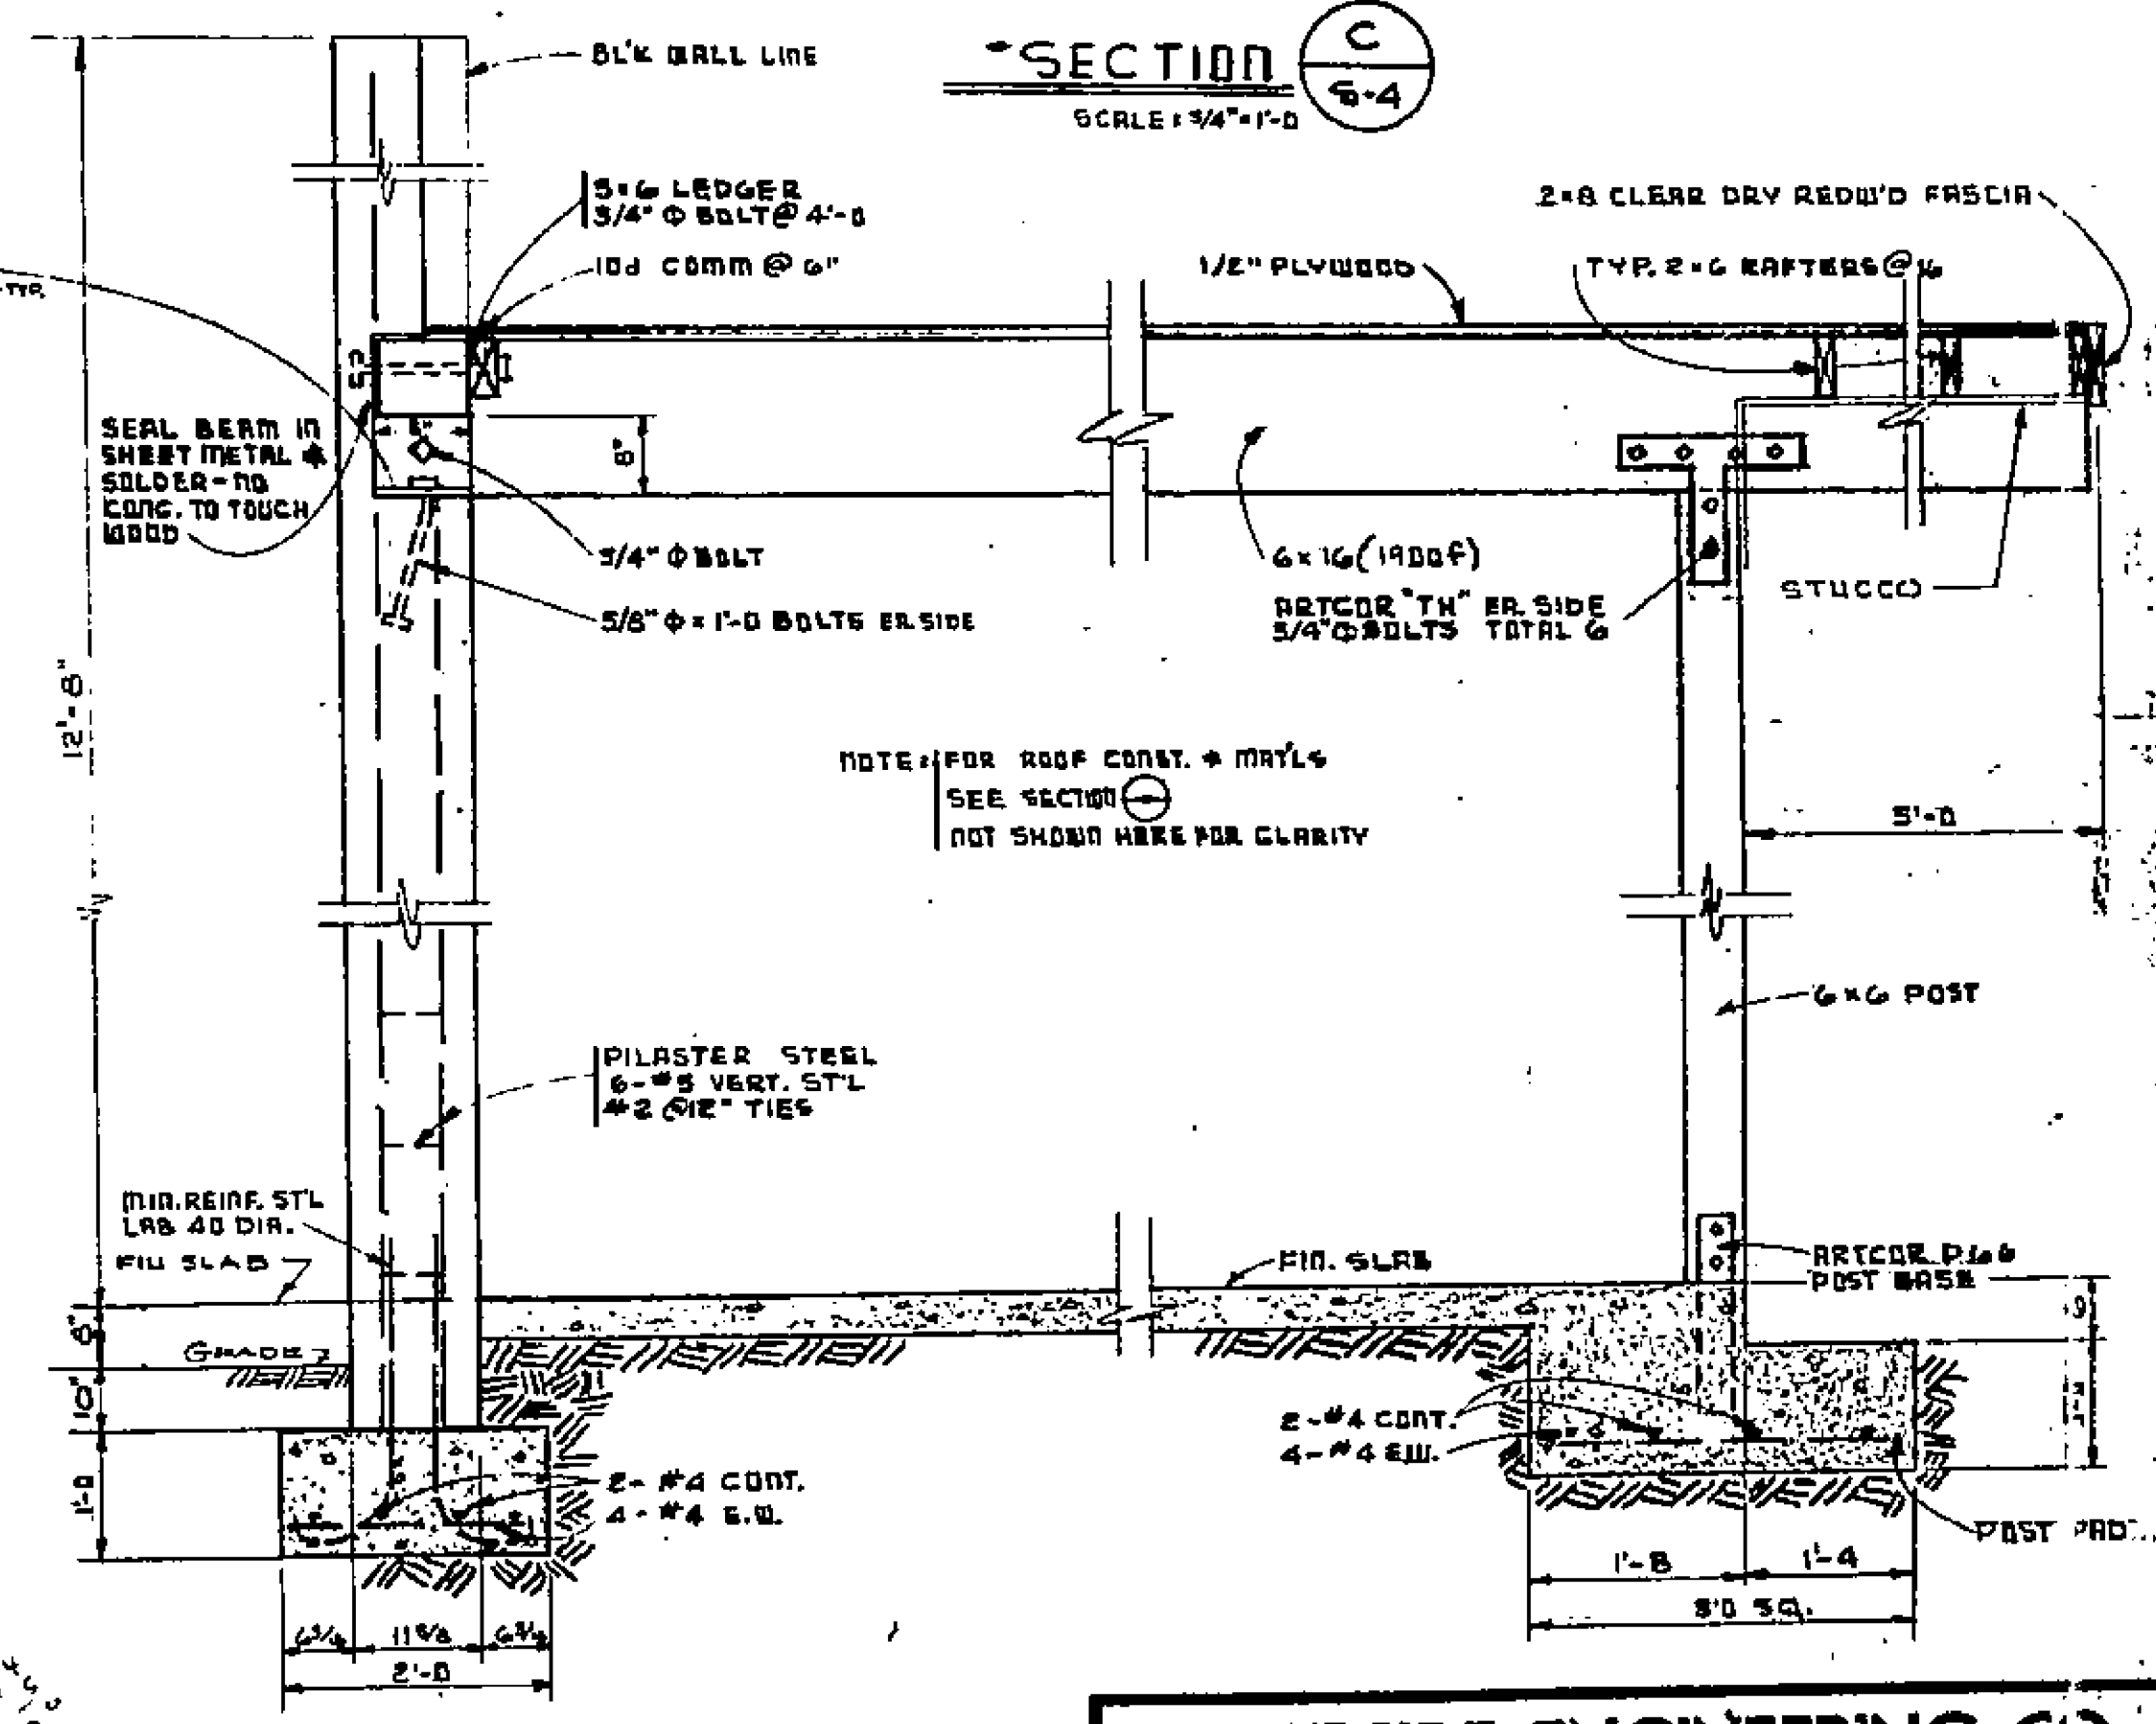

**SECTION E**  
SCALE: 3/4"=1'-0"


**RIVERSIDE ENGINEERING CO.**  
4164 3322 ORANGE STREET  
RIVERSIDE, CALIFORNIA

FOR COMMUNITY SERVICE ADDRESS: LA SIERRA, CALIF.  
DRAWN BY: L.R. CHECKED BY:                      SCALE: NOTED  
DATE: 7/3/58  
JOB No: 2152 FIELD BOOK No:                      SHEET: 5-4 OF 12

REVISIONS		
No.	DATE	MARK
1		
2		
3		
4		
5		
6		

169 12/31



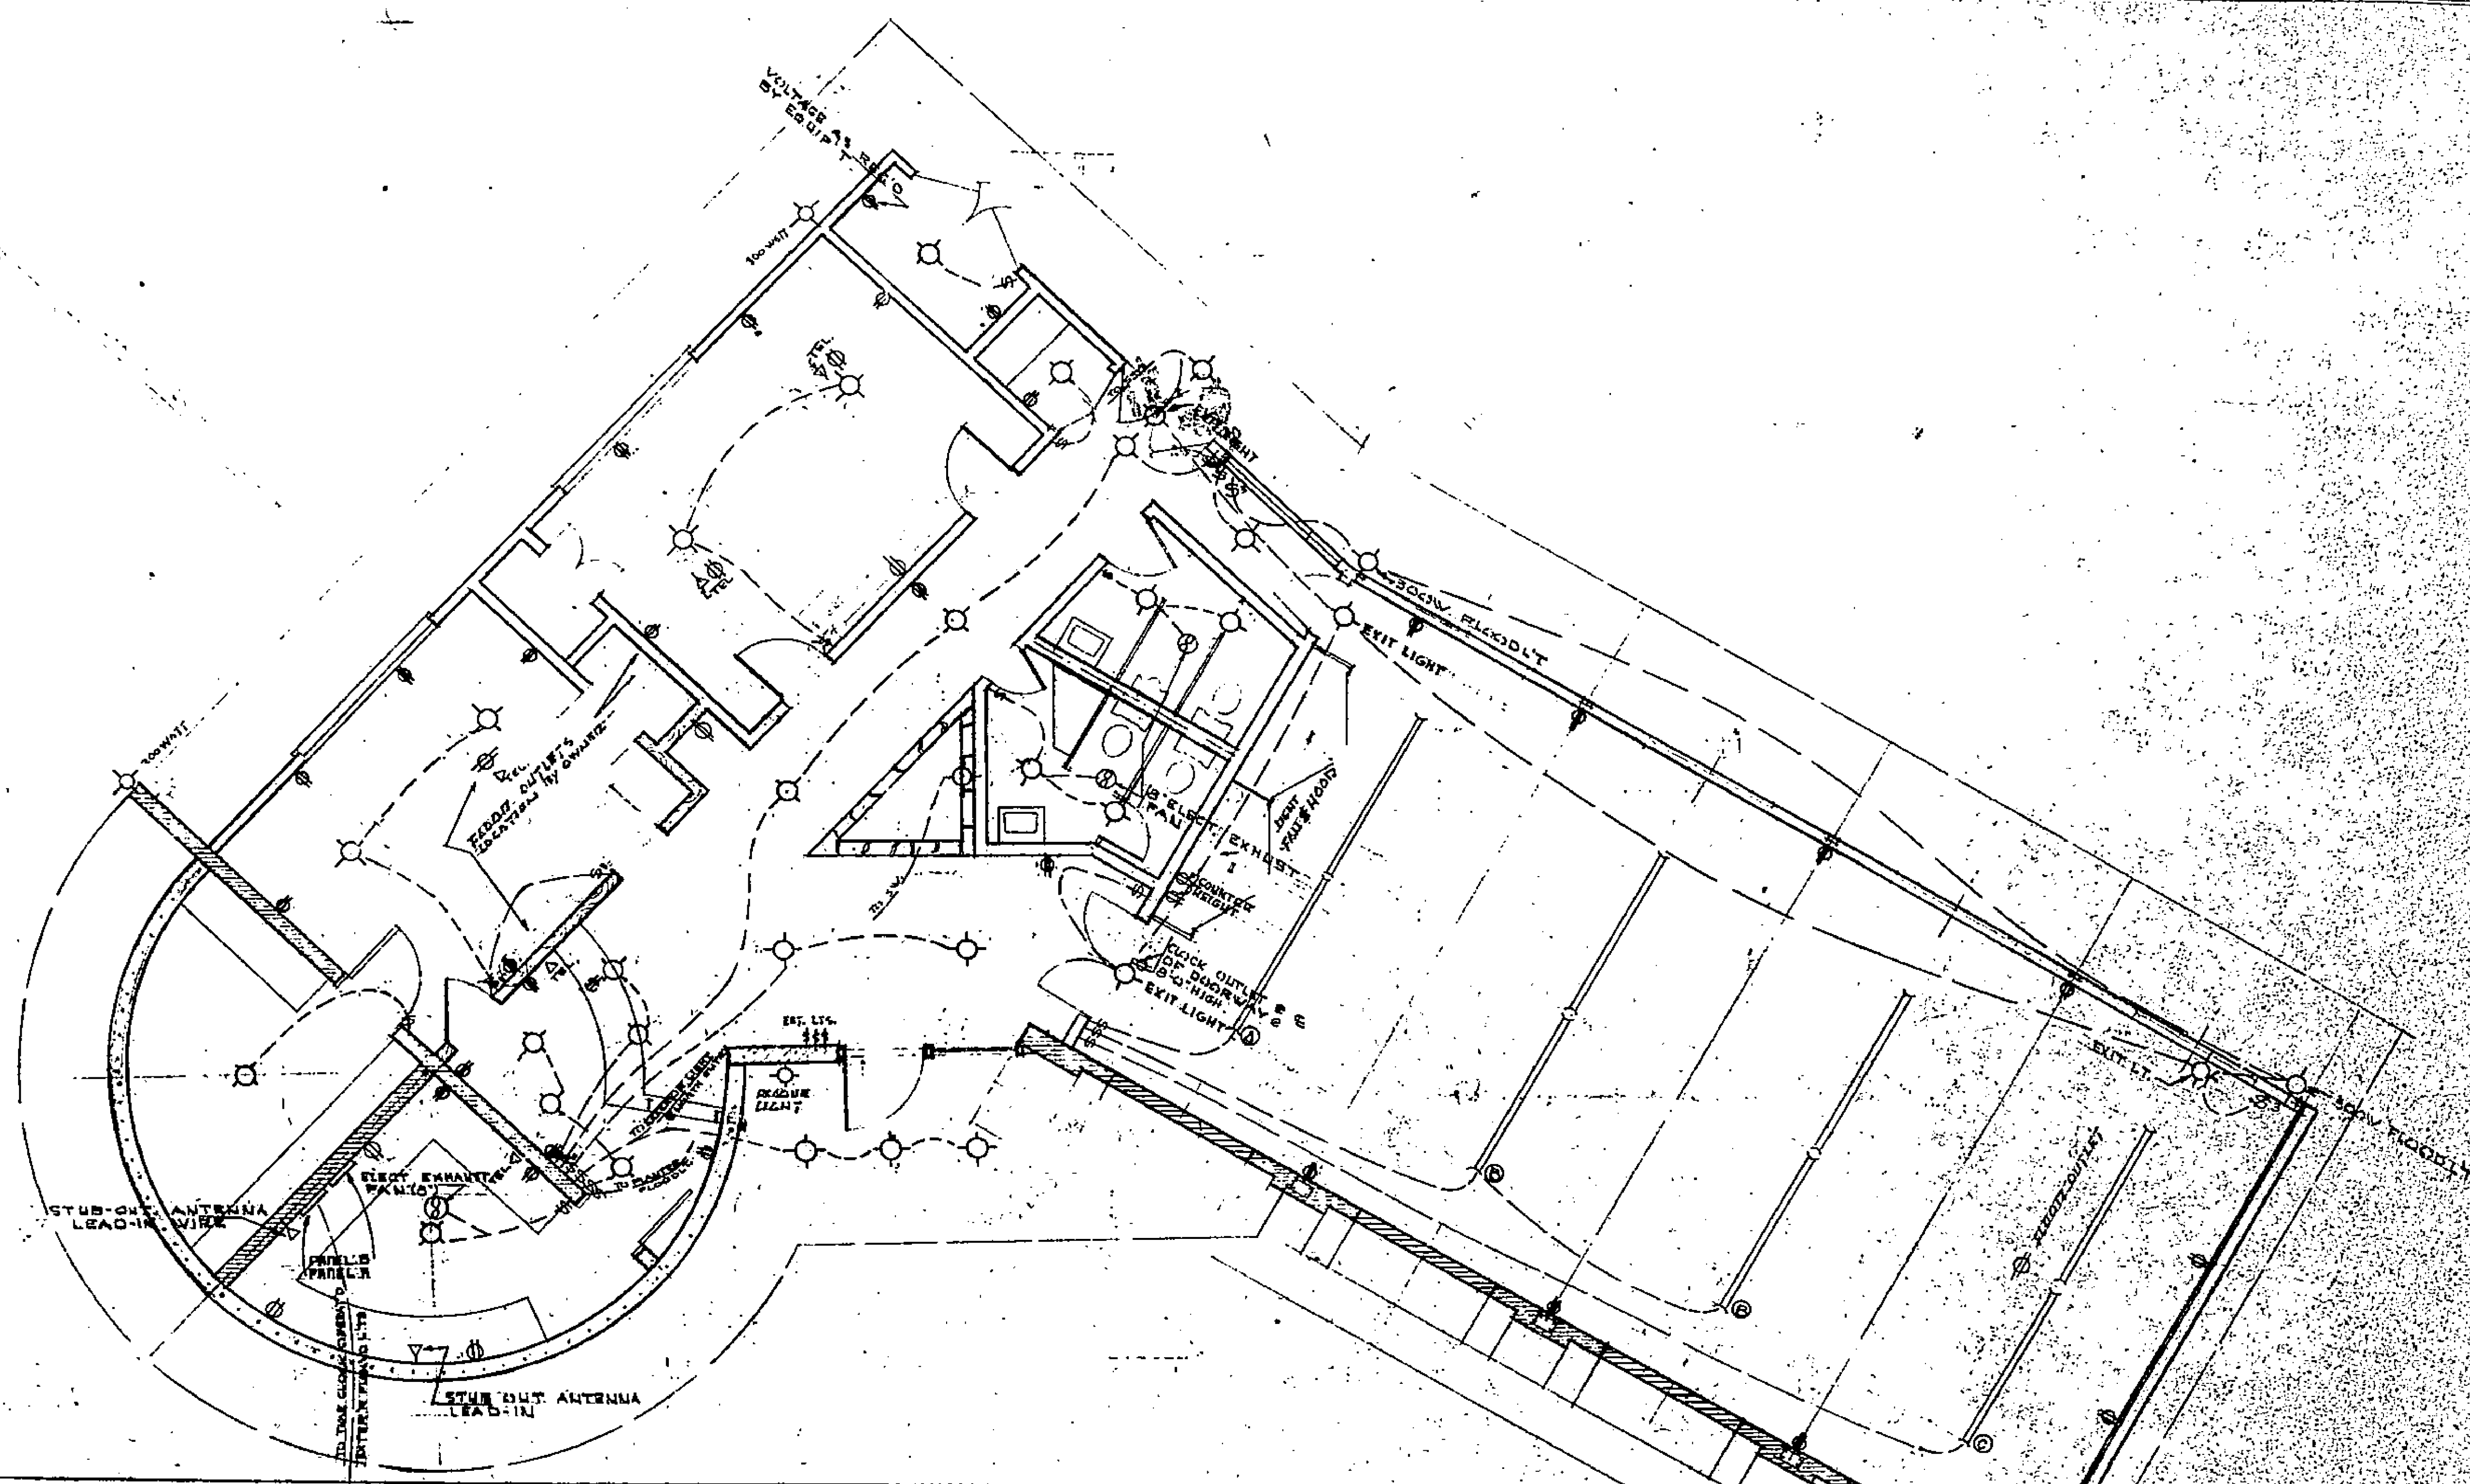

LOCATION	FIXTURES	AMOUNT	CIRCUIT	AMPS	PANEL
WALL	SMOOTH HOLLOW LUMINOUS	1	1	10	A
COMMUNITY SERVICE	PRESCLITE 40420B	2	1	10	B
RECEPTION AREA	PRESCLITE 40420B	2	1	10	B
DRIVE FLOORS	5 CFB	1	1	10	B
DRIVE FLOORS		2	5	10	B
RECEPTION	PRESCLITE 70-A	1	2	10	B
EAST HALL LIGHT	PRESCLITE 89	1	2	10	B
EXIT LIGHT	PRESCLITE 85E	3	5	10	B
EAST HALL LIGHT	PRESCLITE 40415B	1	2	10	B
HALL LIGHTS	PRESCLITE 40415B	5	2	15	B
PLASTER	MOE LIGHT 10-1867	1	2	10	B
MEN TOILET	PRESCLITE 6400B	2	2	10	B
WOMEN TOILET	PRESCLITE 6400B	2	2	10	B
CIVIL DEPT. OFF.	PRESCLITE 6401B	1	2	10	B
RECEPTION	PRESCLITE 70-B	1	2	10	B
AUDITORIUM	SMOOTH HOLLOW PV 100	2	5	10	B
EXIT SIGN FLOODLIGHTS	PRESCLITE 89	3	5	10	B
LUB. V.	PRESCLITE 10-1867	1	2	10	B
REAR AUDITORIUM	300W FLOOD LT.	2	2	10	B
AUDITORIUM	SMOOTH HOLLOW PV 100	1	5	10	B
DRIVE LAMP FIXTURES	SMOOTH HOLLOW PV 100	2	2	10	B
AUDITORIUM	SMOOTH HOLLOW PV 100	1	7	10	B

LOCATION	FIXTURES	CIRCUIT	AMP.	PANEL
REAR OF COMM. TR. VAULT RM. EXT. HALL	RECEPTACLE	1	10	B
COMM. SERVICE - CONTROL - JANITOR		2	15	B
EMERGENCY RM. - RECEPTION AREA		3	10	B
LOBBY - WEST AUDITORIUM HALL		4	10	B
SOUTH-EAST AUDITORIUM HALL		5	10	B
FURNACE ROOM	VOLTAGE AS REQ'D BY AIR CONDITIONING & HYG. EQUIP.	6	10	B
SPRINK.		7	15	B

PROVIDE AT LEAST 4 SPARE 15 AMP. CIRCUITS FOR FUTURE EXPANSION

ELECTRICAL PLAN  
SCALE: 1/4" = 1'-0"

1691

REVISIONS		
NO.	DATE	MARK
1		
2		
3		
4		
5		
6		

**RIVERSIDE ENGINEERING CO.**  
3929 ORANGE STREET  
RIVERSIDE, CALIFORNIA


FOR COMMUNITY SERVICE, ADDRESS: LA SIERRA, CA.

DRAWN BY: H. J. B. CHECKED BY: SCALE: 1/4" = 1'-0"

DATE: 7/1/58

CIVIL ENGINEER  
REGISTERED IN CALIFORNIA  
MEDICAL EXAMINER

JOB NO. 1691 FIELD BOOK NO. WEST. 1/1/58

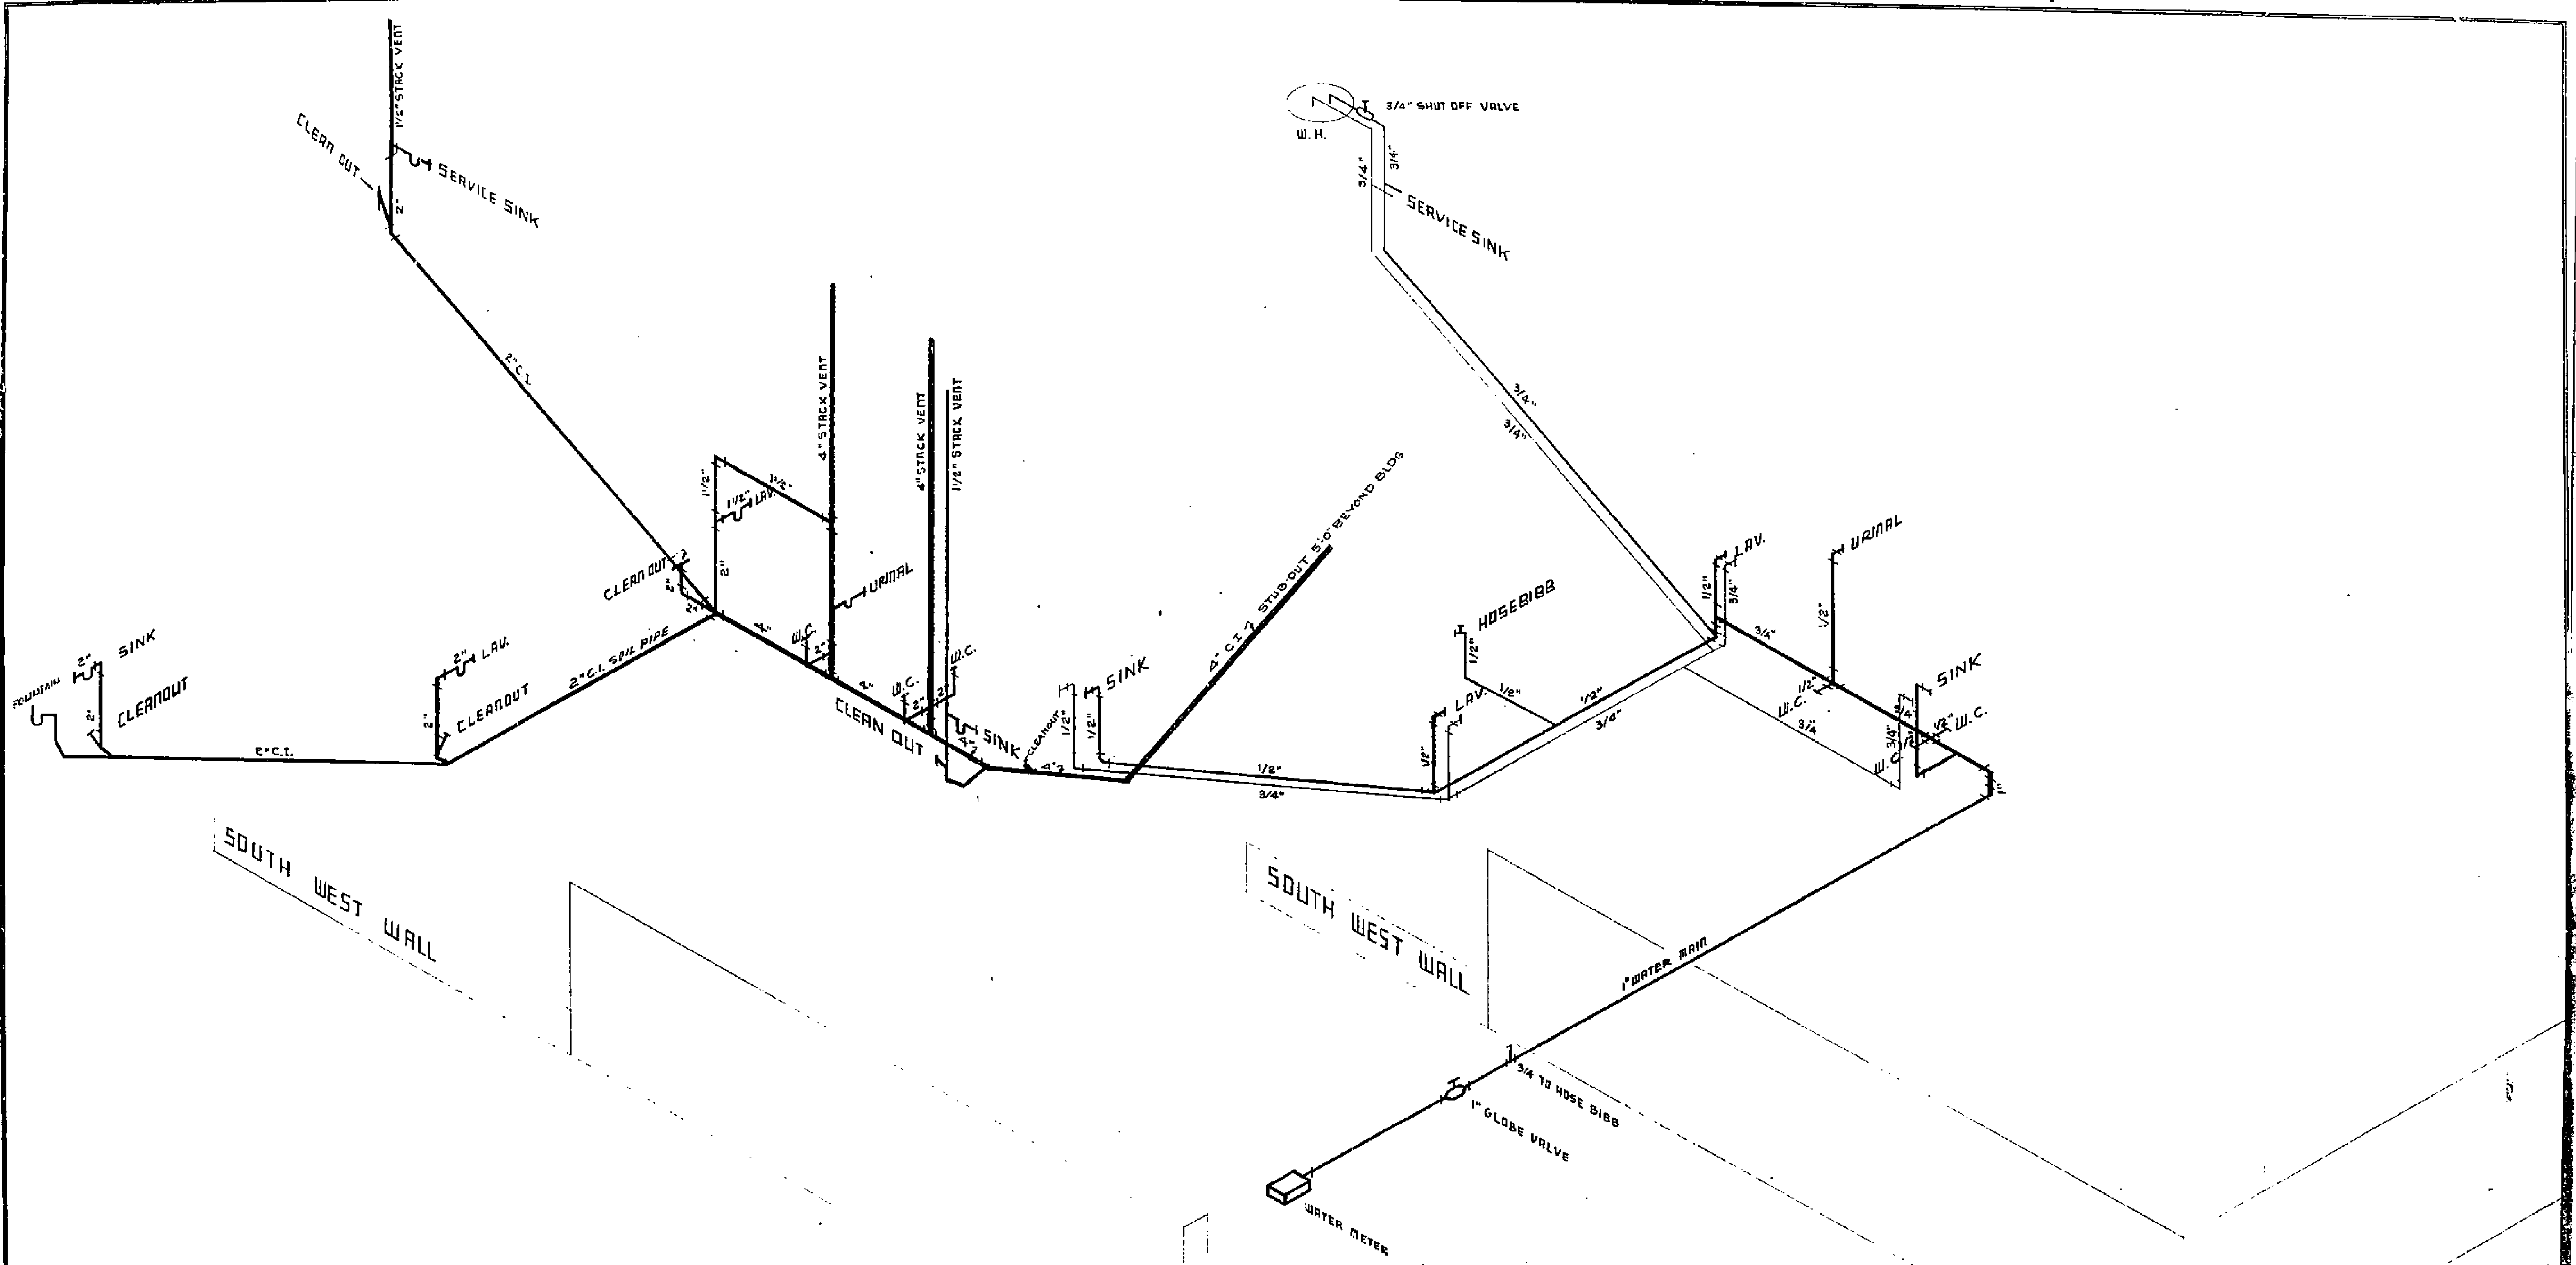

SEWER DRAIN SCHEMATIC DIAGRAM

HOT & COLD WATER SCHEMATIC DIAGRAM

1691

REVISIONS		
No.	DATE	MARK
1		
2		
3		
4		
5		
6		

**RIVERSIDE ENGINEERING CO.**  
 4164 ORANGE STREET  
 RIVERSIDE, CALIFORNIA


FOR COMMUNITY SERVICE ADDRESS LA SIERRA, CALIF.

DRAWN BY R.J.B. CHECKED BY L.R. SCALE AS SHOWN

DATE 7/10/56

CIVIL ENGINEER No. 1176  
 STRUCTURAL ENGINEER No. 326  
 MECHANICAL ENGINEER No. 929

JOB No. 2156 FIELD-BOOK No. \_\_\_\_\_ SHEET 2-1 OF 10

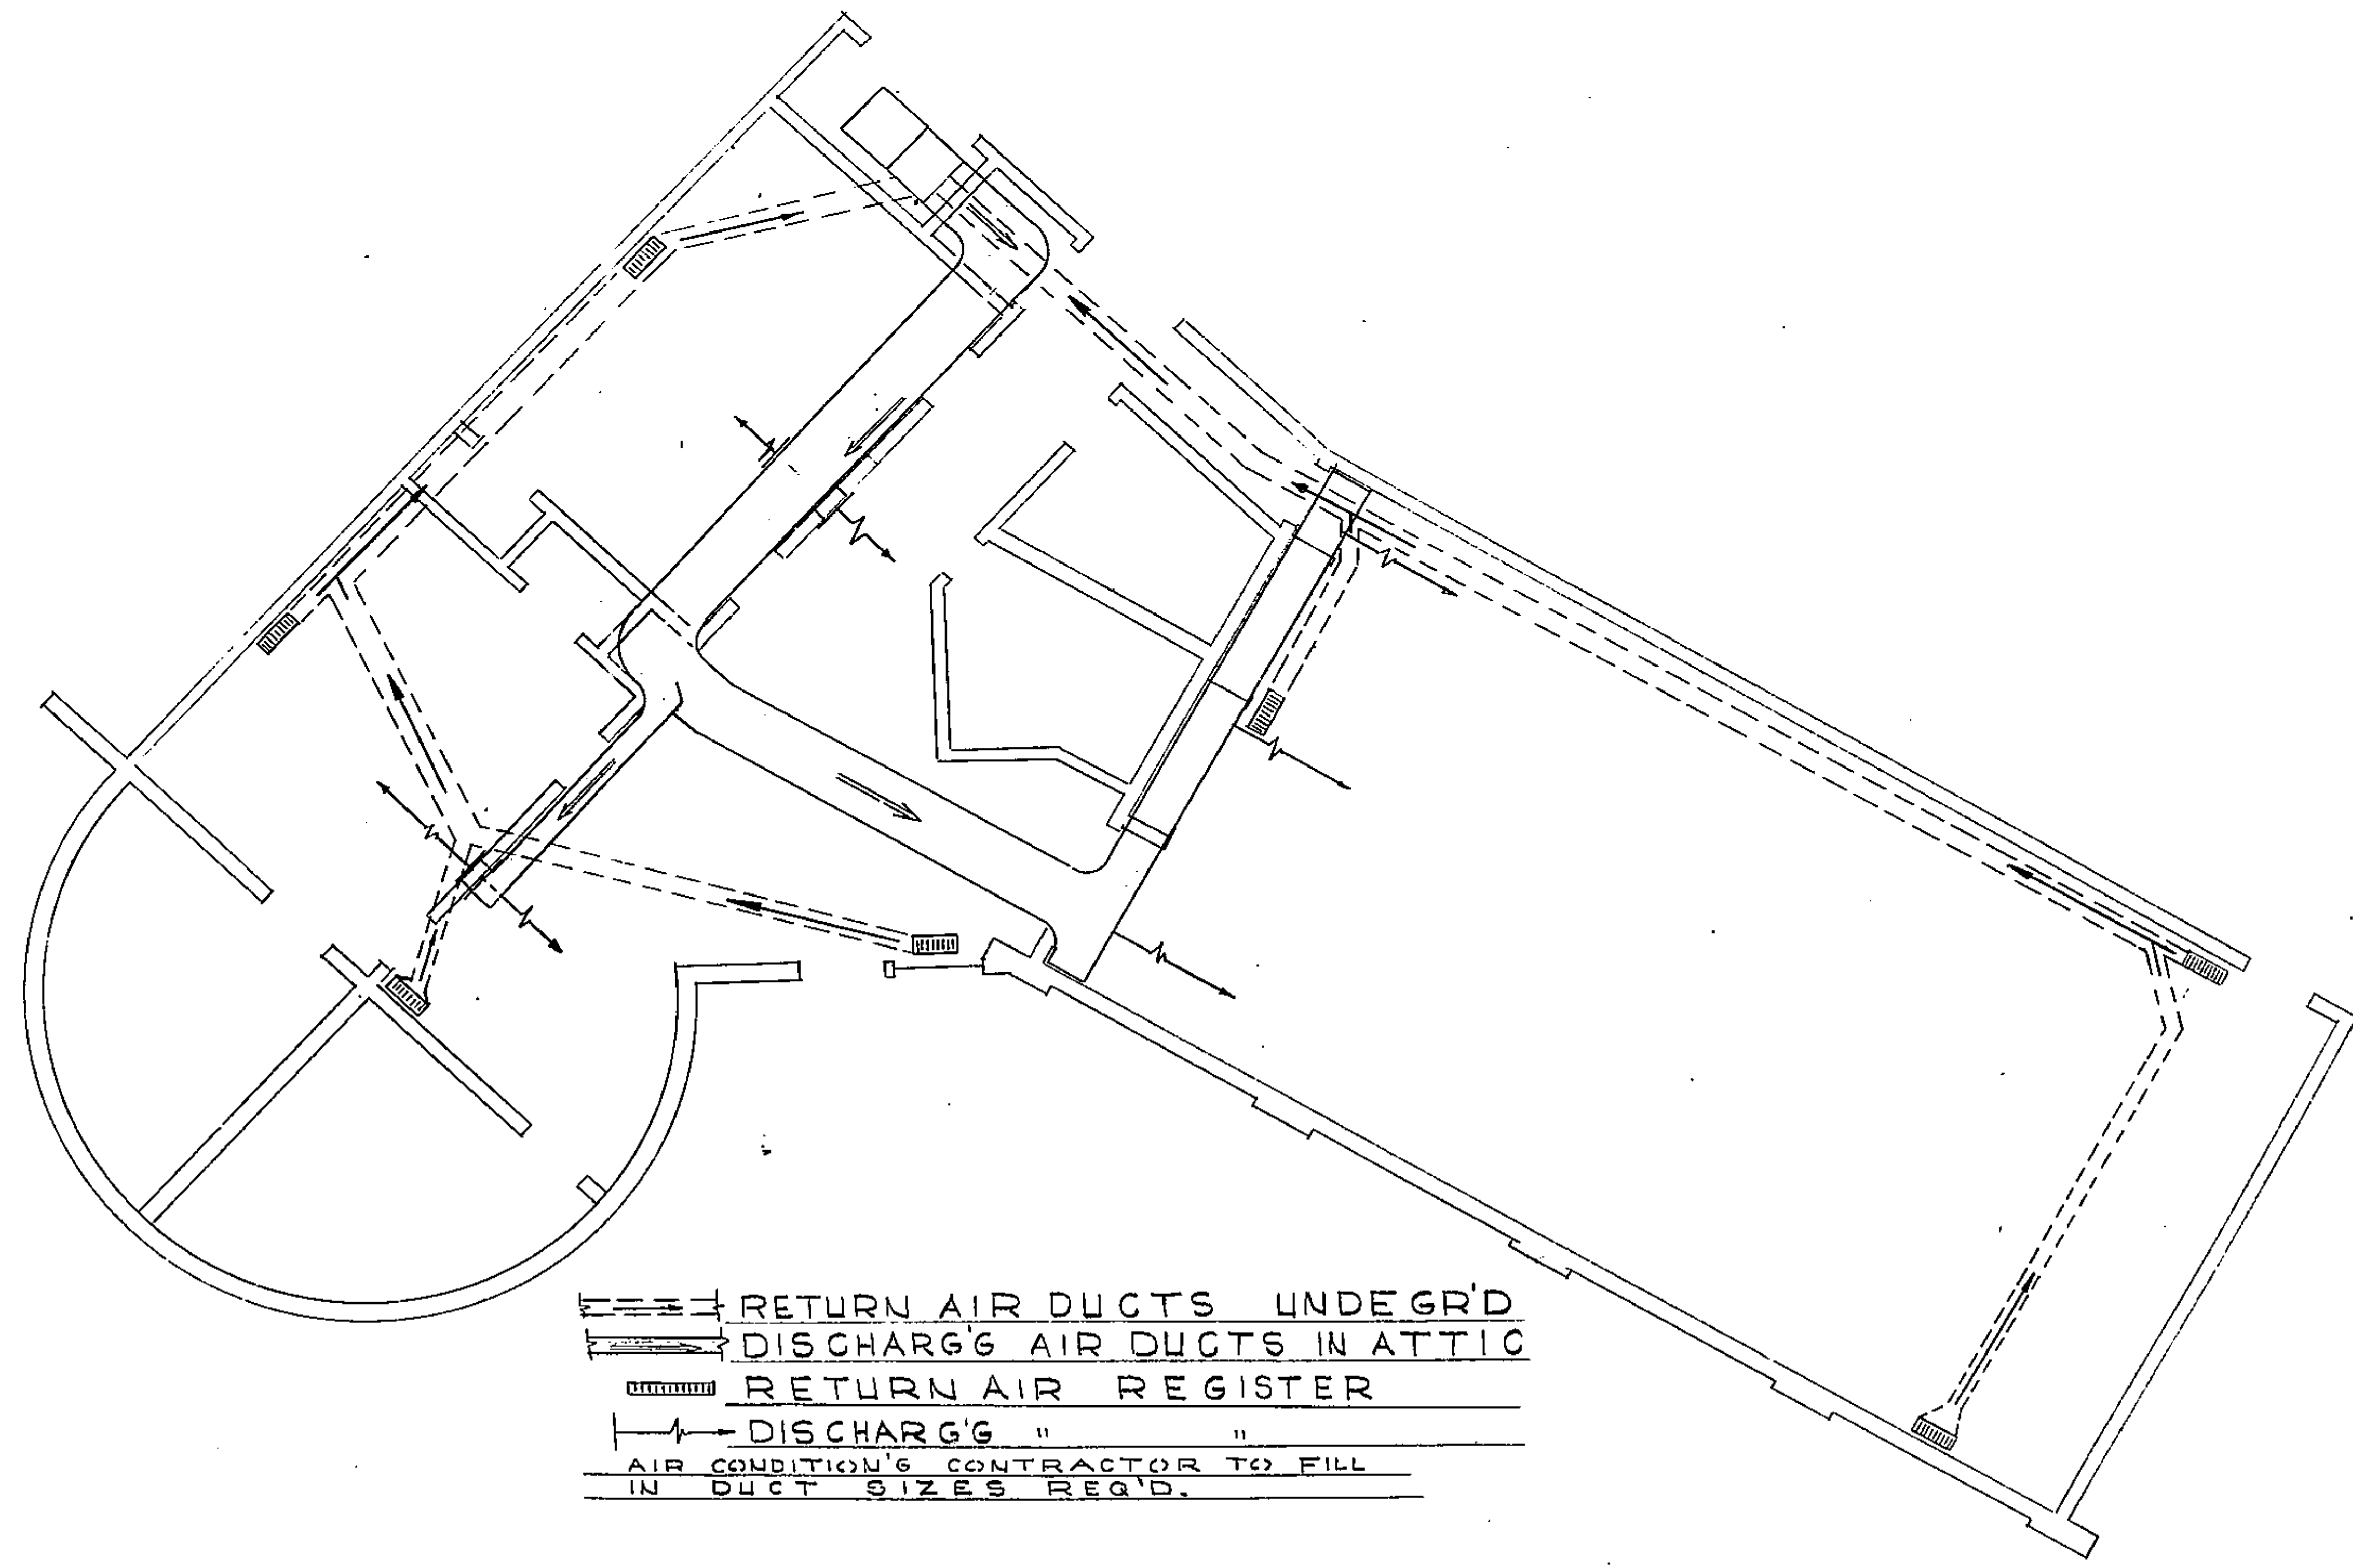

- - - - - RETURN AIR DUCTS UNDERGR'D  
 ——— DISCHARGG AIR DUCTS IN ATTIC  
 [GRID] RETURN AIR REGISTER  
 | | DISCHARGG " " " "  
 AIR CONDITIONG CONTRACTOR TO FILL  
 IN DUCT SIZES REQ'D.

AIR CONDITIONING DUCTS PLAN  
 SCALE 1/4" = 1'-0"

1691


REVISIONS

No.	DATE	MARK
1		
2		
3		
4		
5		
6		


**RIVERSIDE ENGINEERING CO.**  
 4164 ORANGE STREET  
 RIVERSIDE, CALIFORNIA

FOR SIERRA COMM SERVICE, LA SIERRA  
 ADDRESS  
 DRAWN BY LR CHECKED BY SCALE 1/4" = 1'-0"  
 DATE AUG. 14, 1958  
 CIVIL ENGINEER NO. 1126  
 STRUCTURAL ENGINEER NO. 226  
 MECHANICAL ENGINEER NO. 999  
 JOB No. 2156 FIELD BOOK No. SHEET 2A-1 OF 1E


**PLUMBING**  
 A/A. STD. 2205-51 OR EQUAL  
 \* F 2114-2  
 \* TL-17 FITTING  
 DAY NIGHT SOL WATER HEAT'R

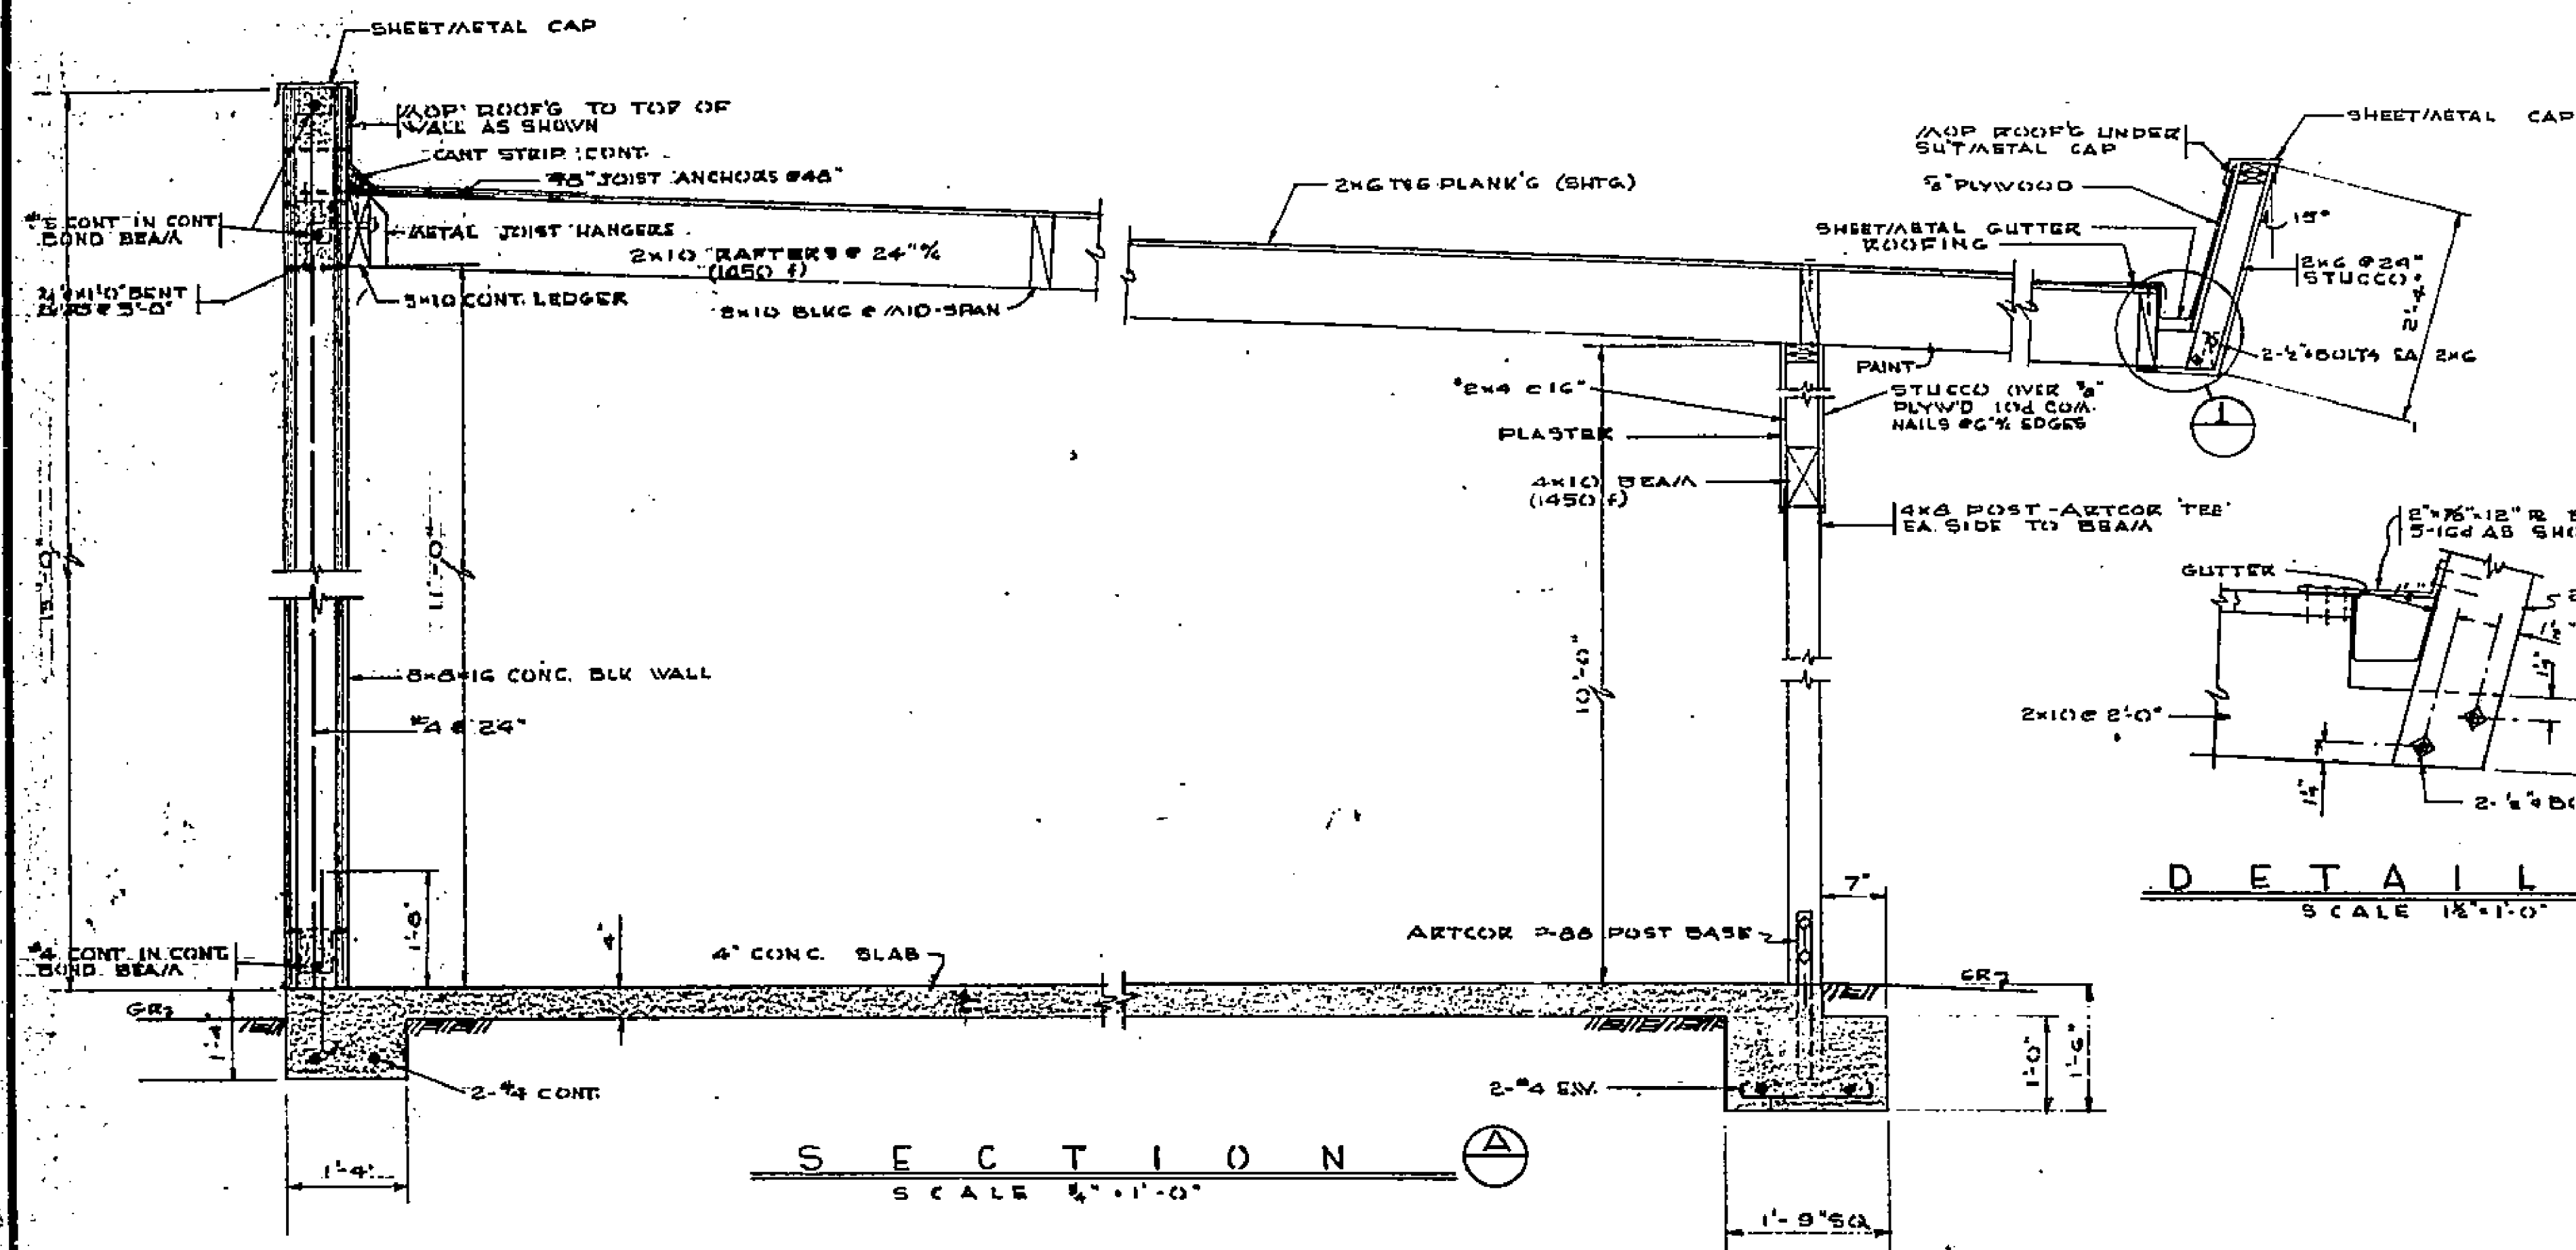


**DETAIL 1**  
 SCALE 1/2\"/>

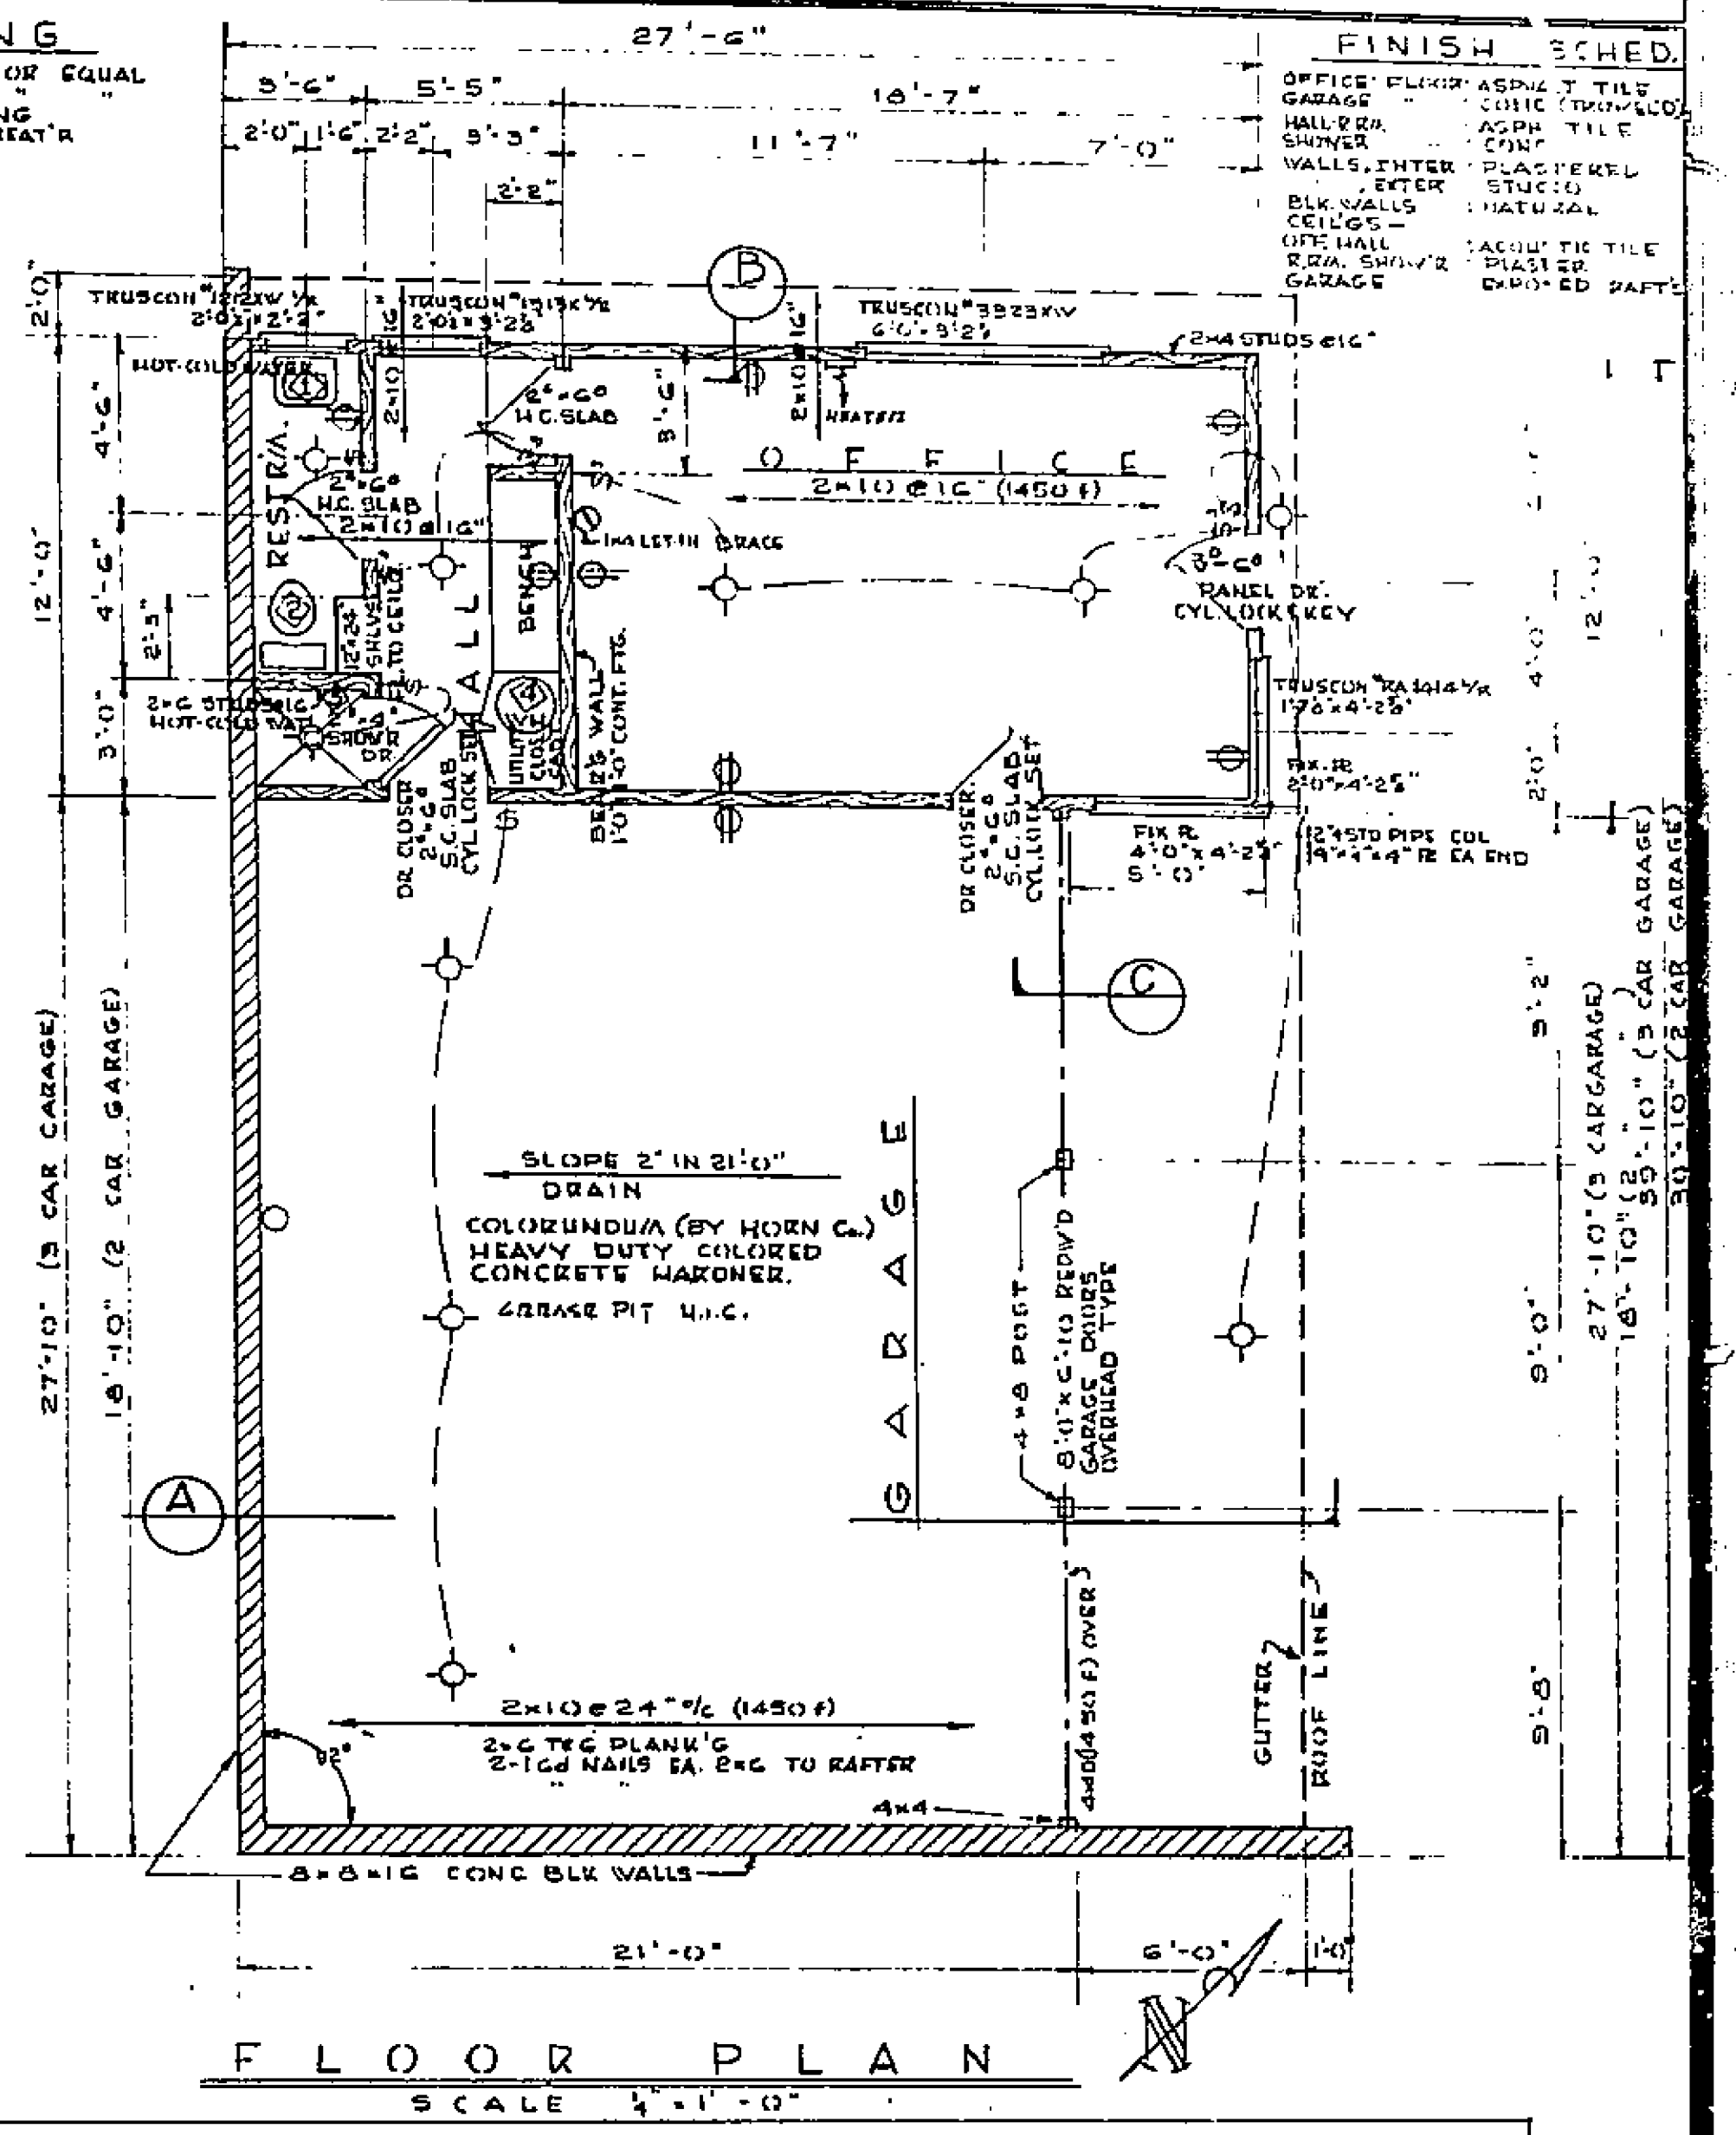


**FLOOR PLAN**  
 SCALE 1/4\"/>

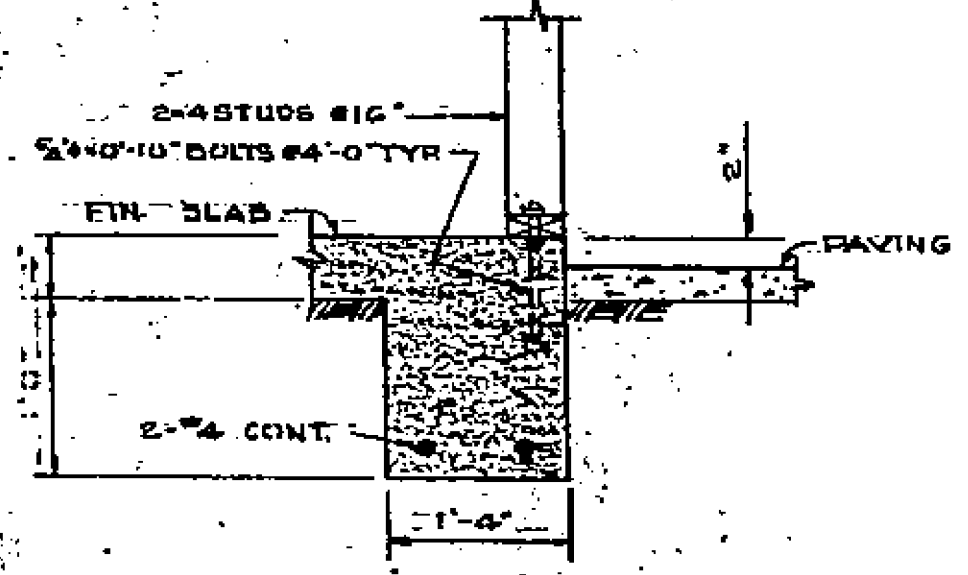


**SECTION B**  
 SCALE 1\"/>

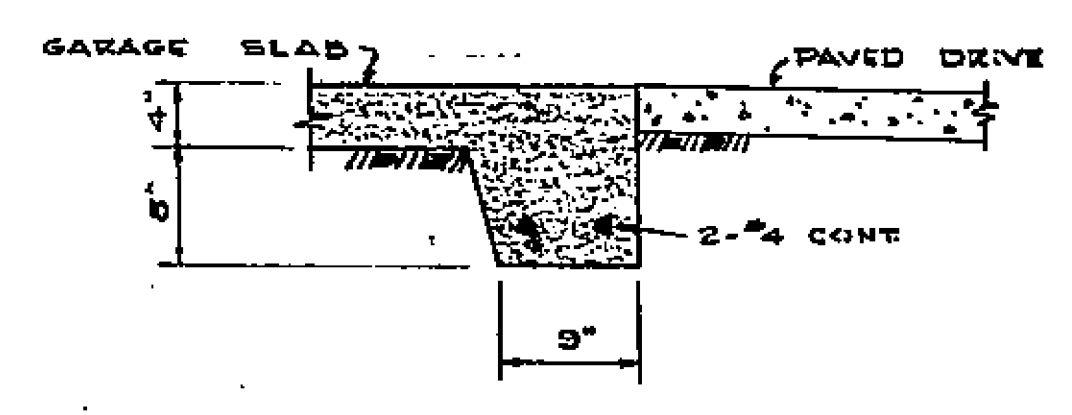

**SECTION C**  
 SCALE 1\"/>

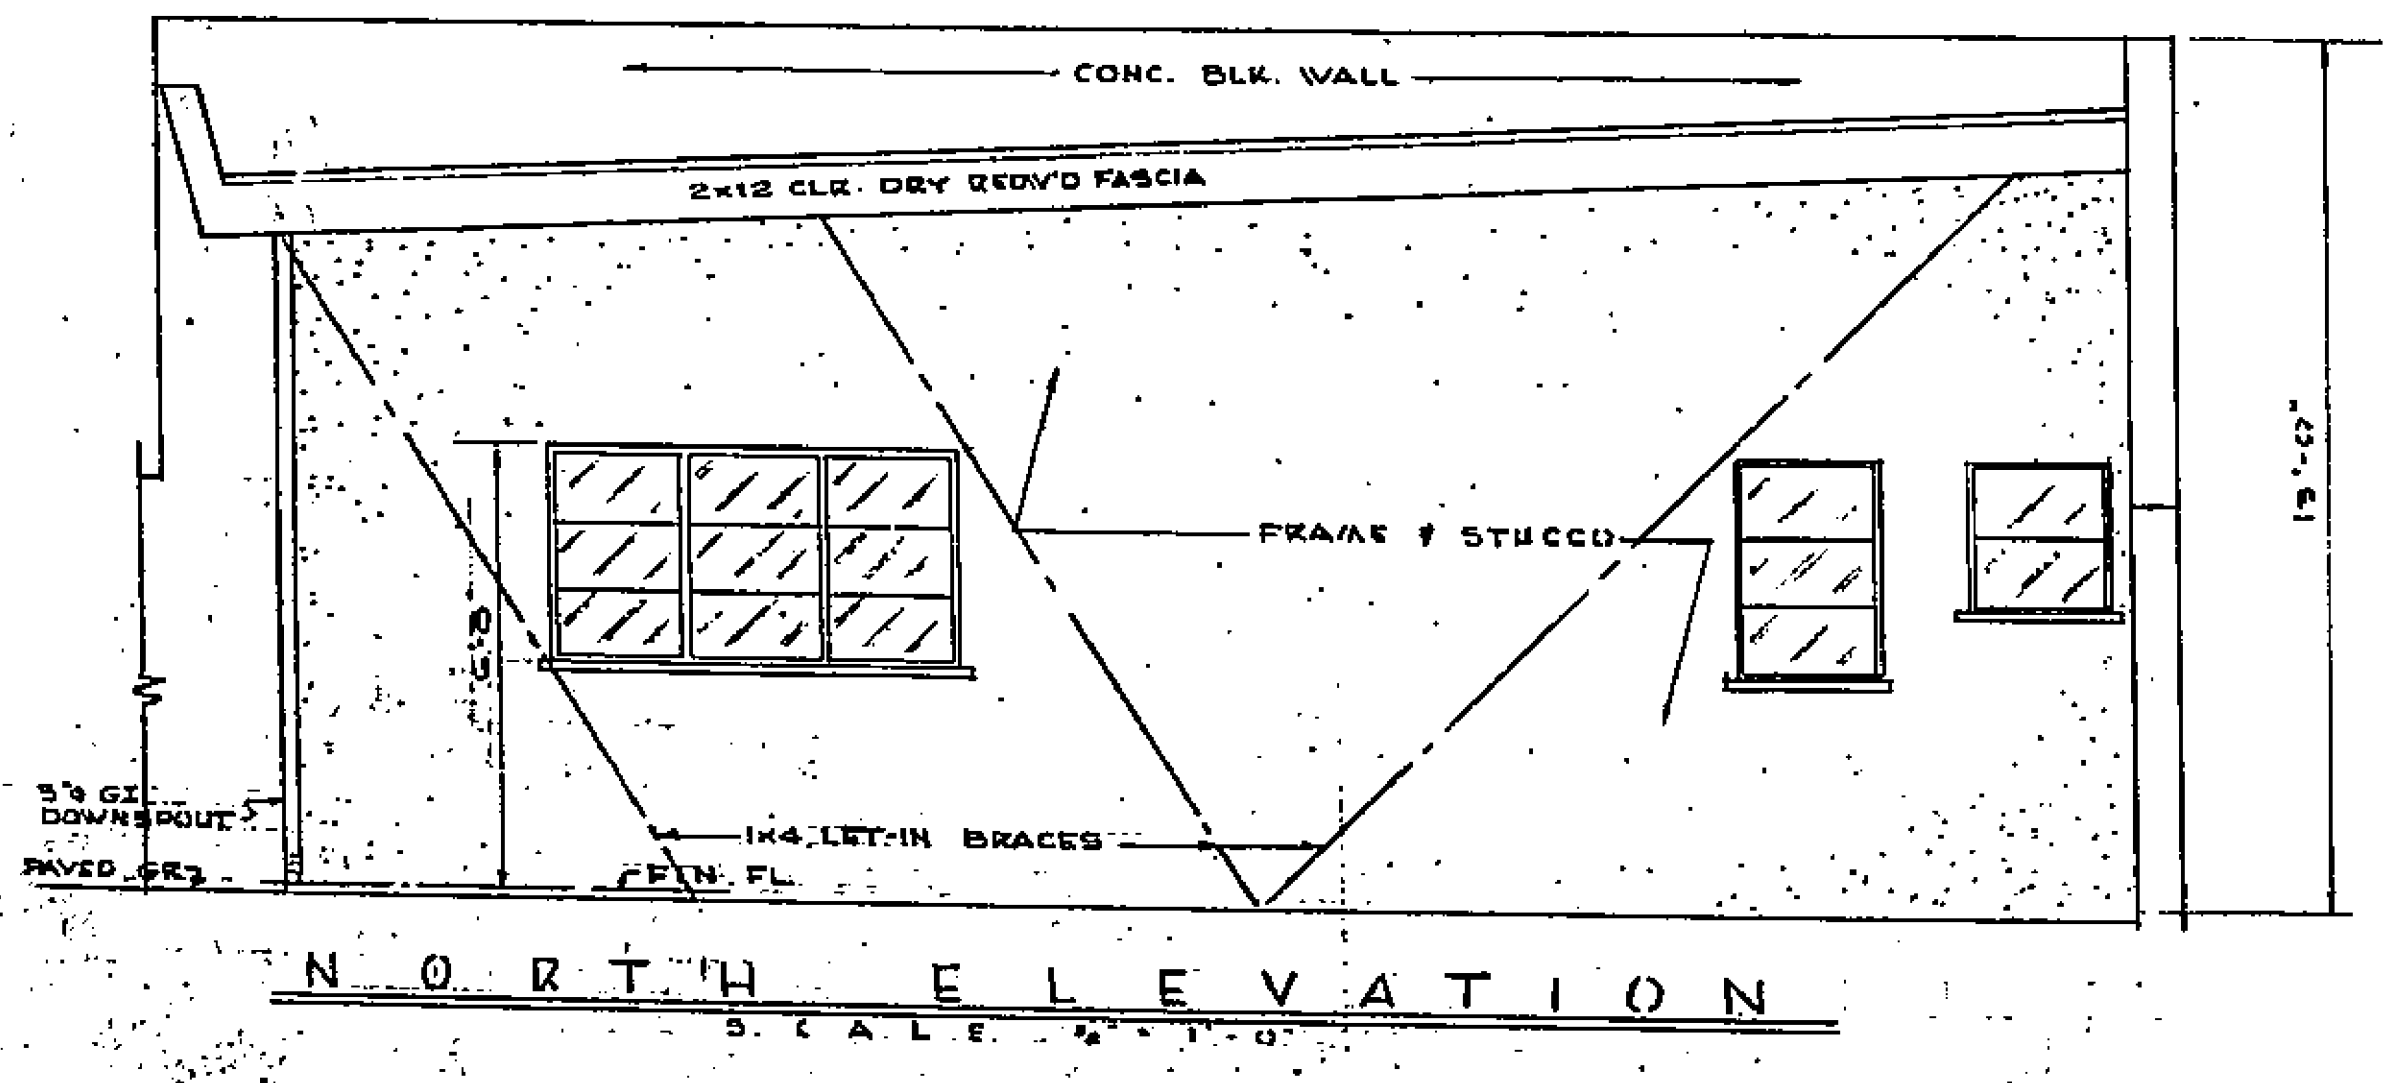

**NORTH ELEVATION**  
 SCALE 1/2\"/>

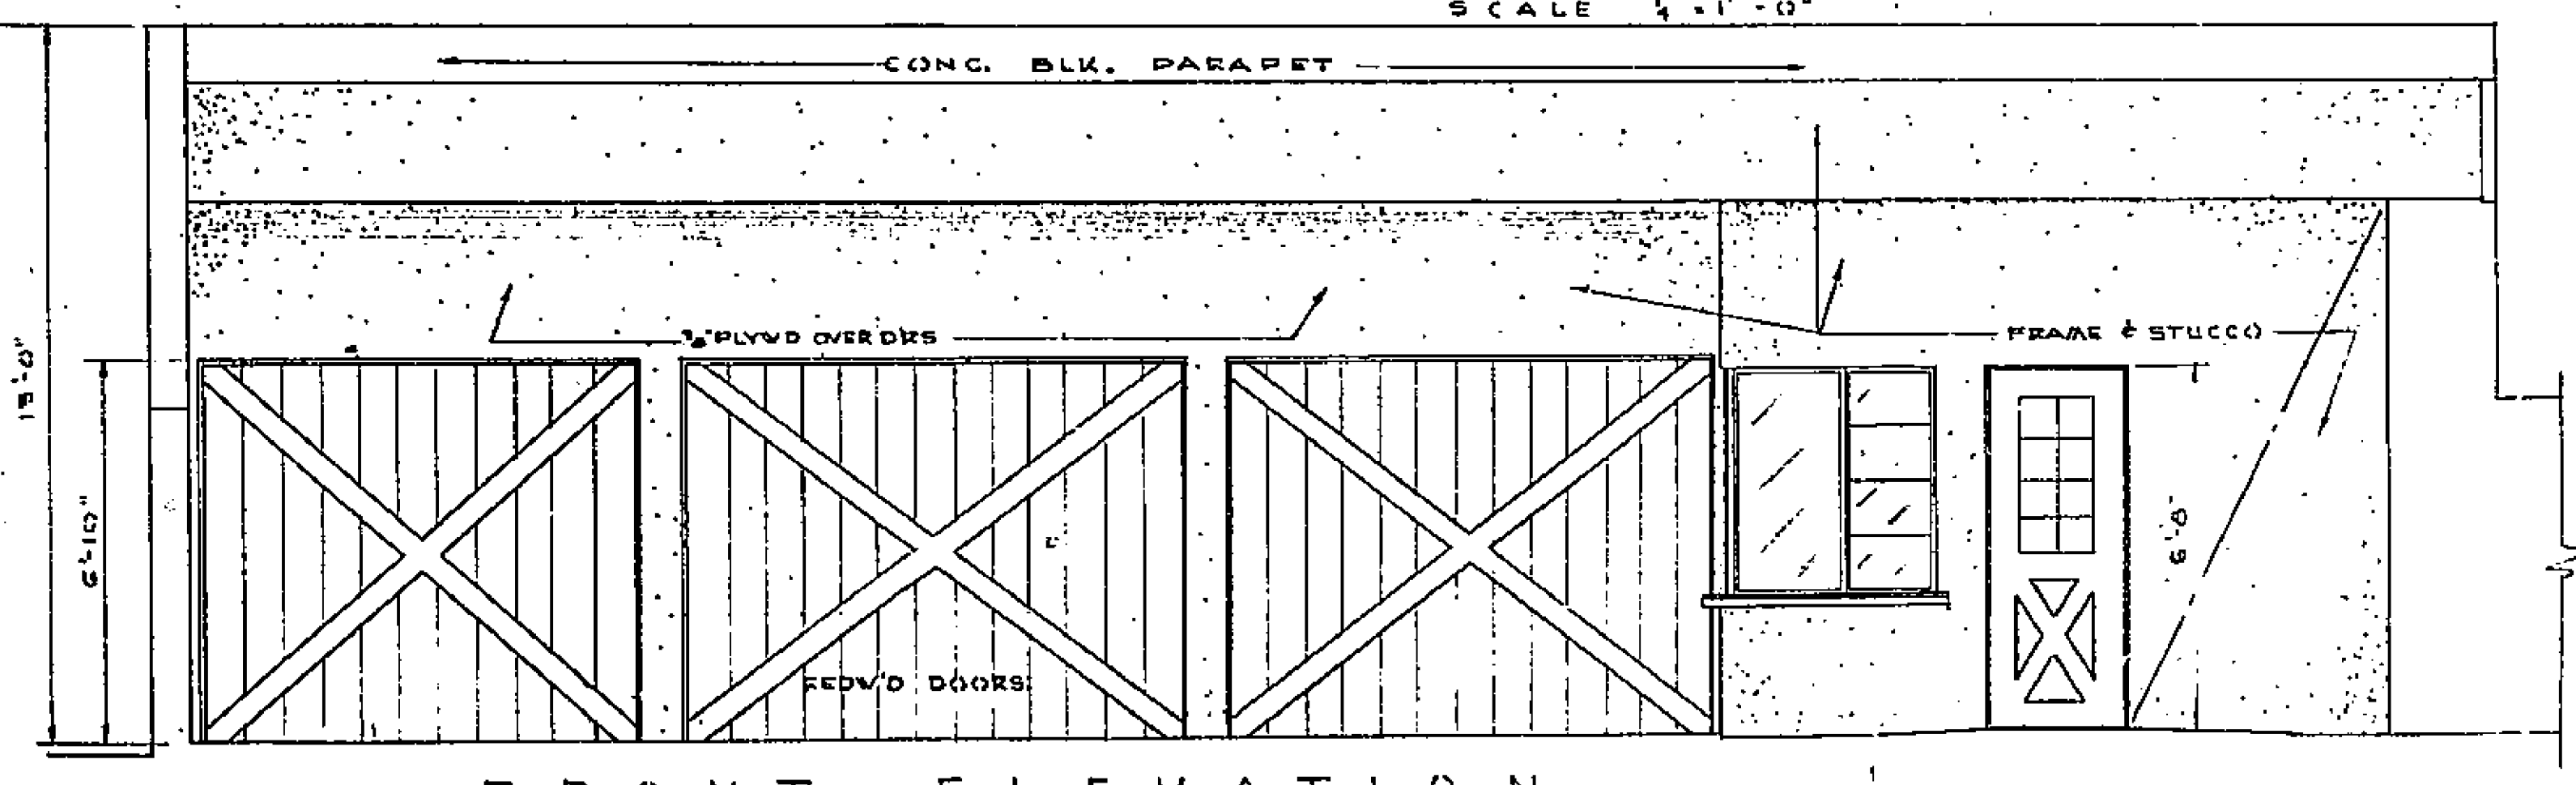

**FRONT ELEVATION**  
 SCALE 3/8\"/>

NOTE ALTERNATE BID FOR 2 & 3 STALL GARAGE  
 BID GARAGE SEPARATE FROM MAIN BLDG  
 BID SAME PLUMBING FIXTURES QUALITY  
 TILE SHOWERS 6\"/>

REVISIONS

No.	DATE	MARK
1		
2		
3		
4		
5		
6		

1691

**RIVERSIDE ENGINEERING CO.**  
 4164 8TH ORANGE STREET  
 RIVERSIDE, CALIFORNIA

FOR LA SIERRA COMM. SERV. - GARAGE  
 ADDRESS

DRAWN BY L.B. CHECKED BY SCALE  
 DATE 9-30-65

CIVIL ENGINEER NO. 1111  
 STRUCTURAL ENGINEER NO. 1111  
 MECHANICAL ENGINEER NO. 950

JOB No. 2156 FIELD BOOK No. SHEET 12 OF 12