


300-4

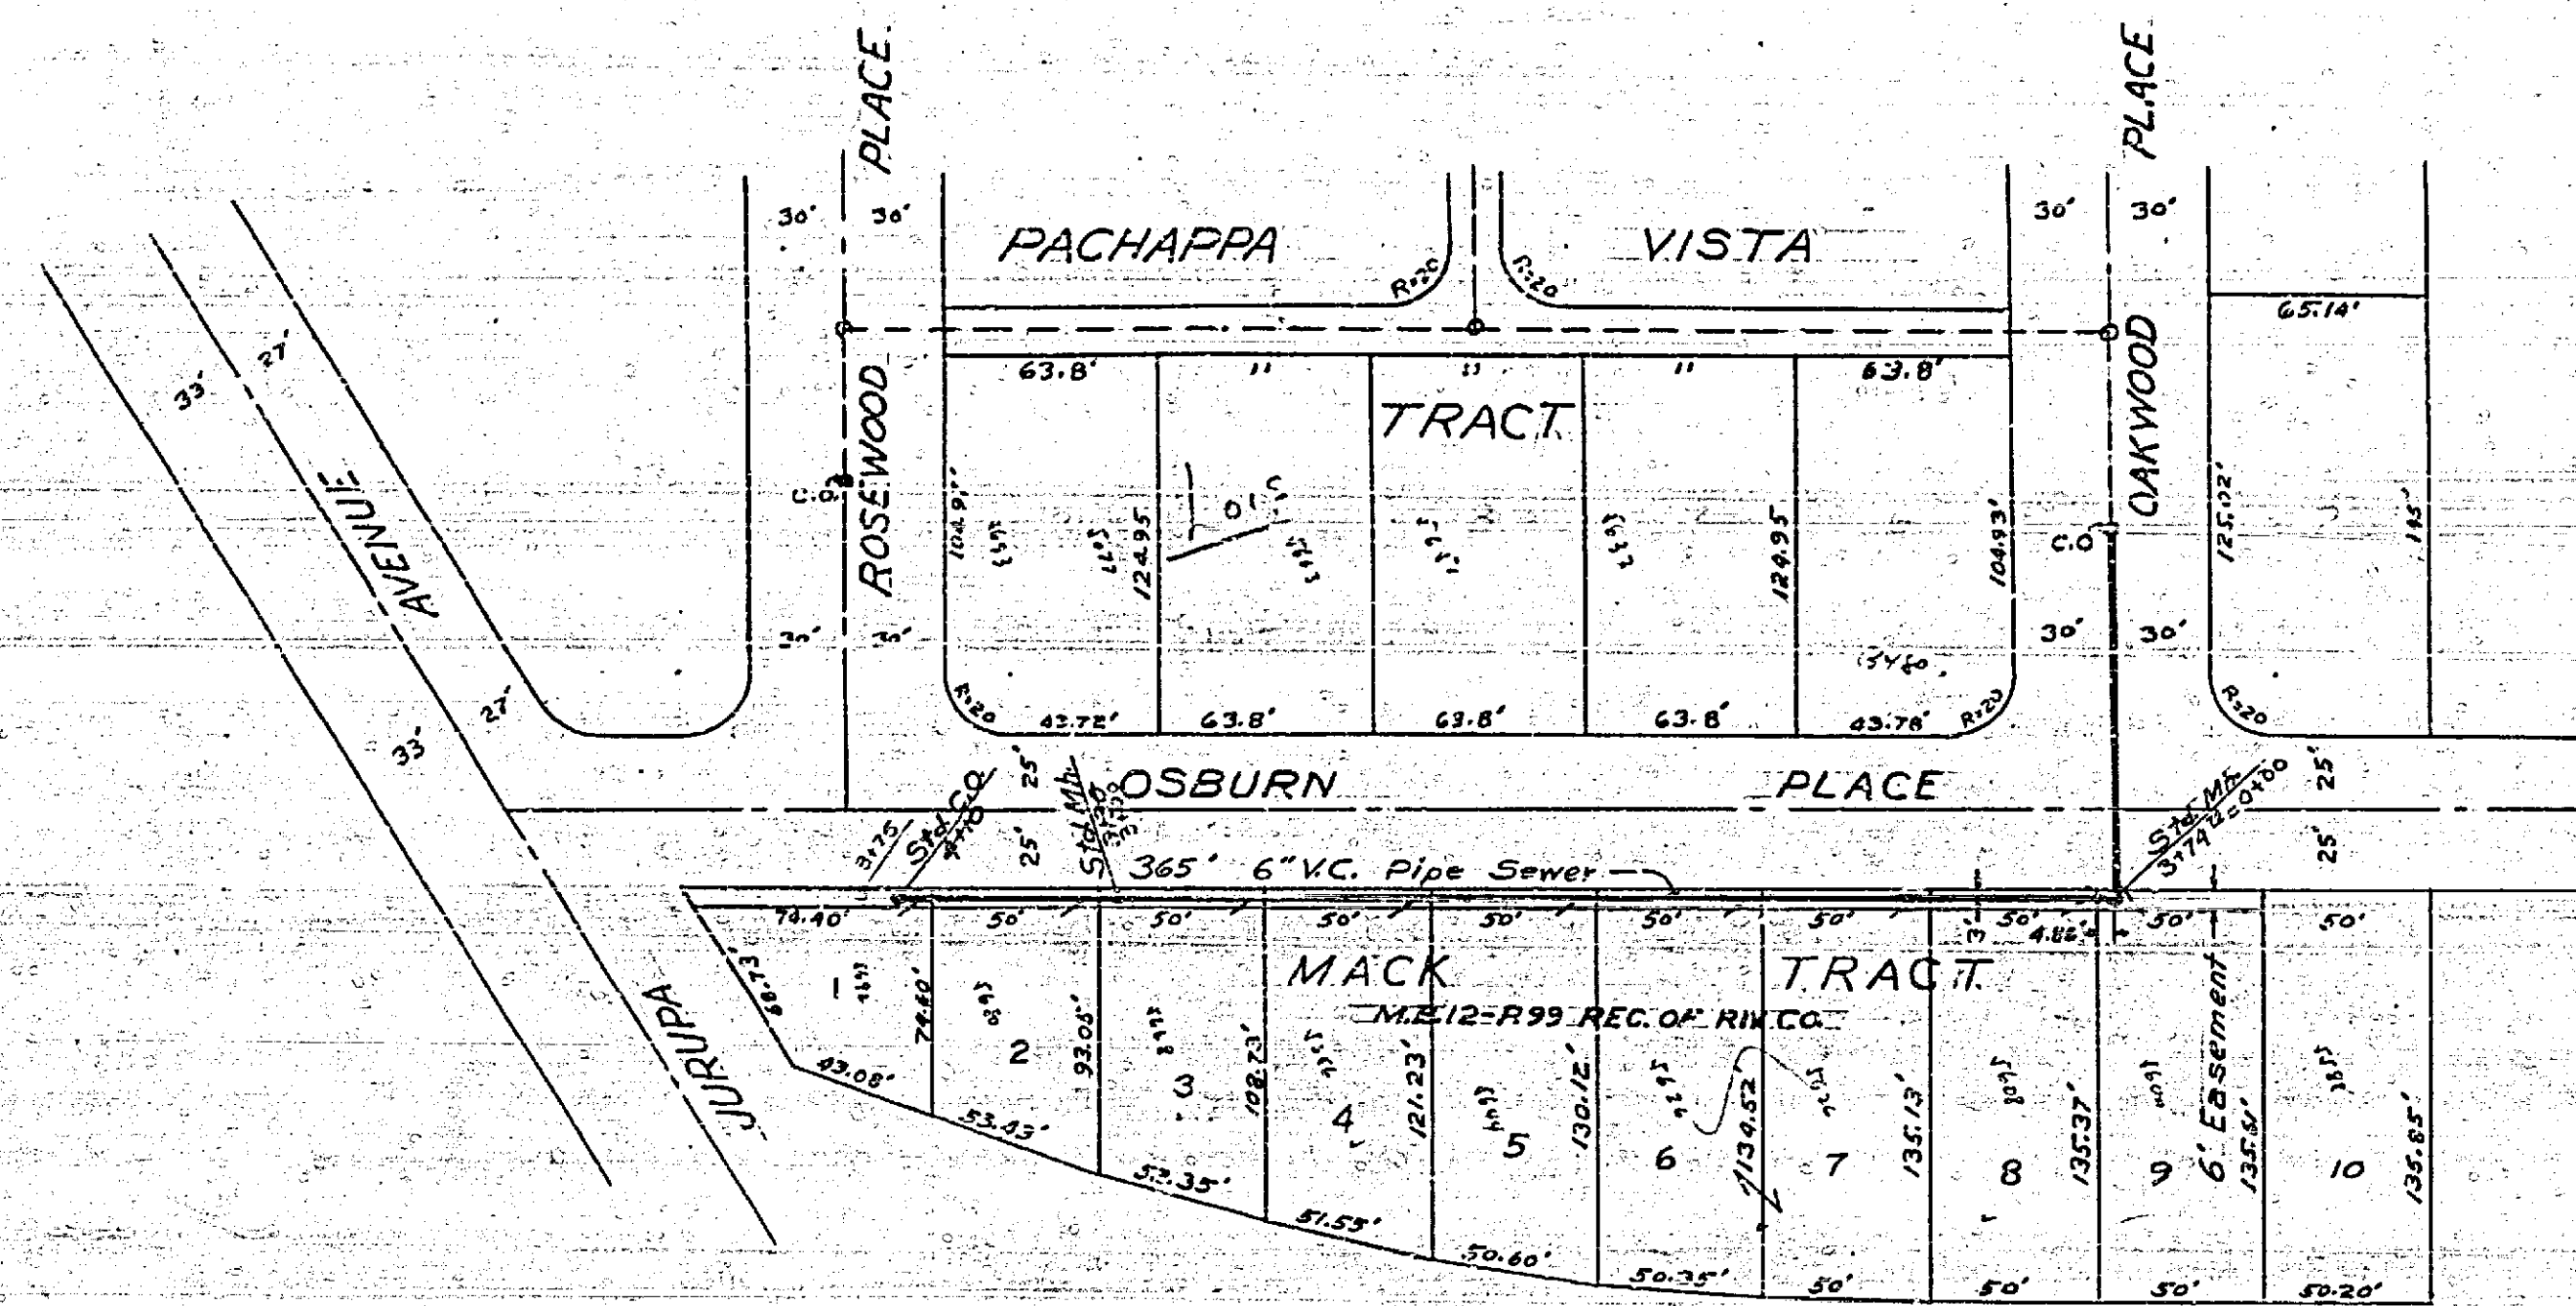


PLAN AND PROFILE NO. 203-A
FOR THE CONSTRUCTION OF
A SANITARY SEWER IN
OSBURN PLACE AND OAKWOOD PLACE

F.B. 517-35 SCALES HOR.: 1 IN. = 50 FT.
VERT.: 1 IN. = 5 FT.

APPROVED *M. H. Irvine*
M.H. IRVINE - RES. C.E. NO. 300
CITY ENGINEER

DATE	
BY	
CHECKED	
DESIGNED	
DRAWN	
SCALE	
PROJECT	
DATE	
BY	
CHECKED	
DESIGNED	
DRAWN	
SCALE	
PROJECT	

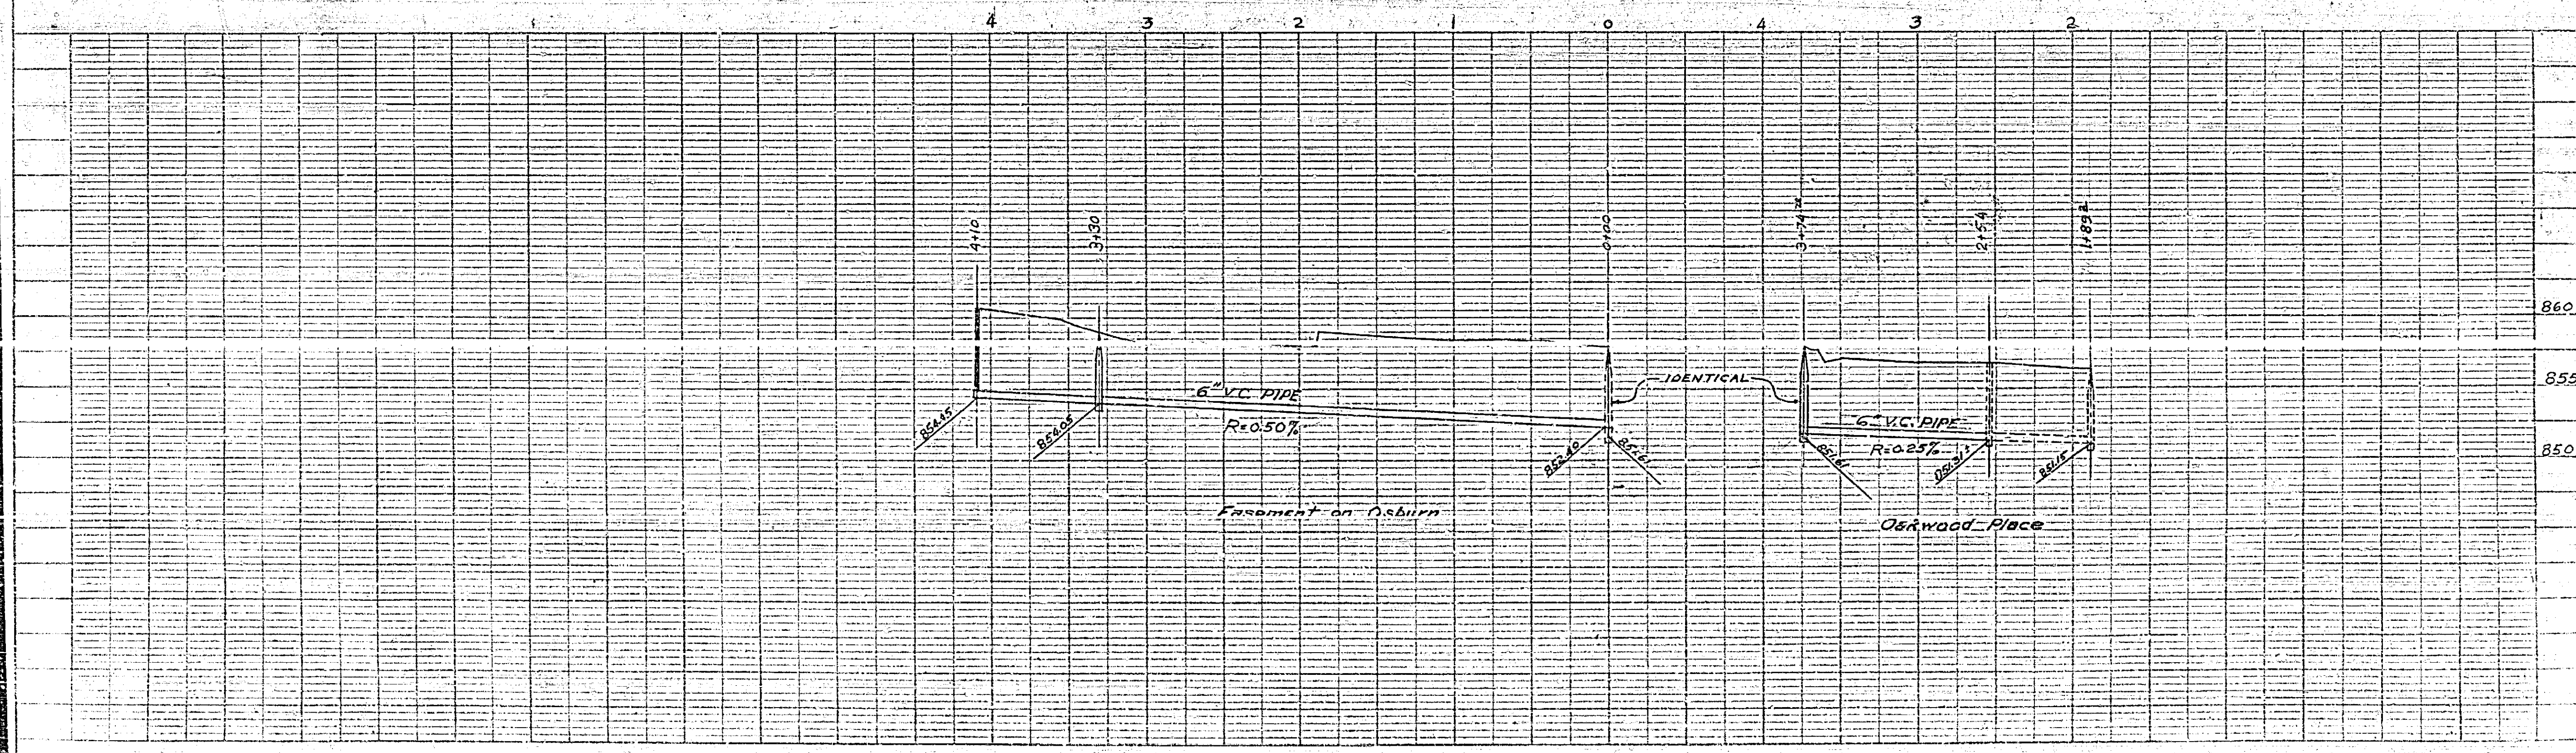

DATE	
BY	
CHECKED	
DESIGNED	
DRAWN	
SCALE	
PROJECT	
DATE	
BY	
CHECKED	
DESIGNED	
DRAWN	
SCALE	
PROJECT	

DATE: 1-14-35
DRAWN BY: J. H. IRVINE
CHECKED BY: J. H. IRVINE
SCALE: AS SHOWN
PROJECT: SANITARY SEWER

203-A