


PLAN AND PROFILE OF
 COMMUNITY HOSPITAL
 PROPOSED SEWER LINE
 NO 374B

APPROVED BY CITY ENGINEER

FB448 PG 26

SCALE VERT 1"=4'
 HORT 1"=40'

0 1 2 3 4 5 6 7

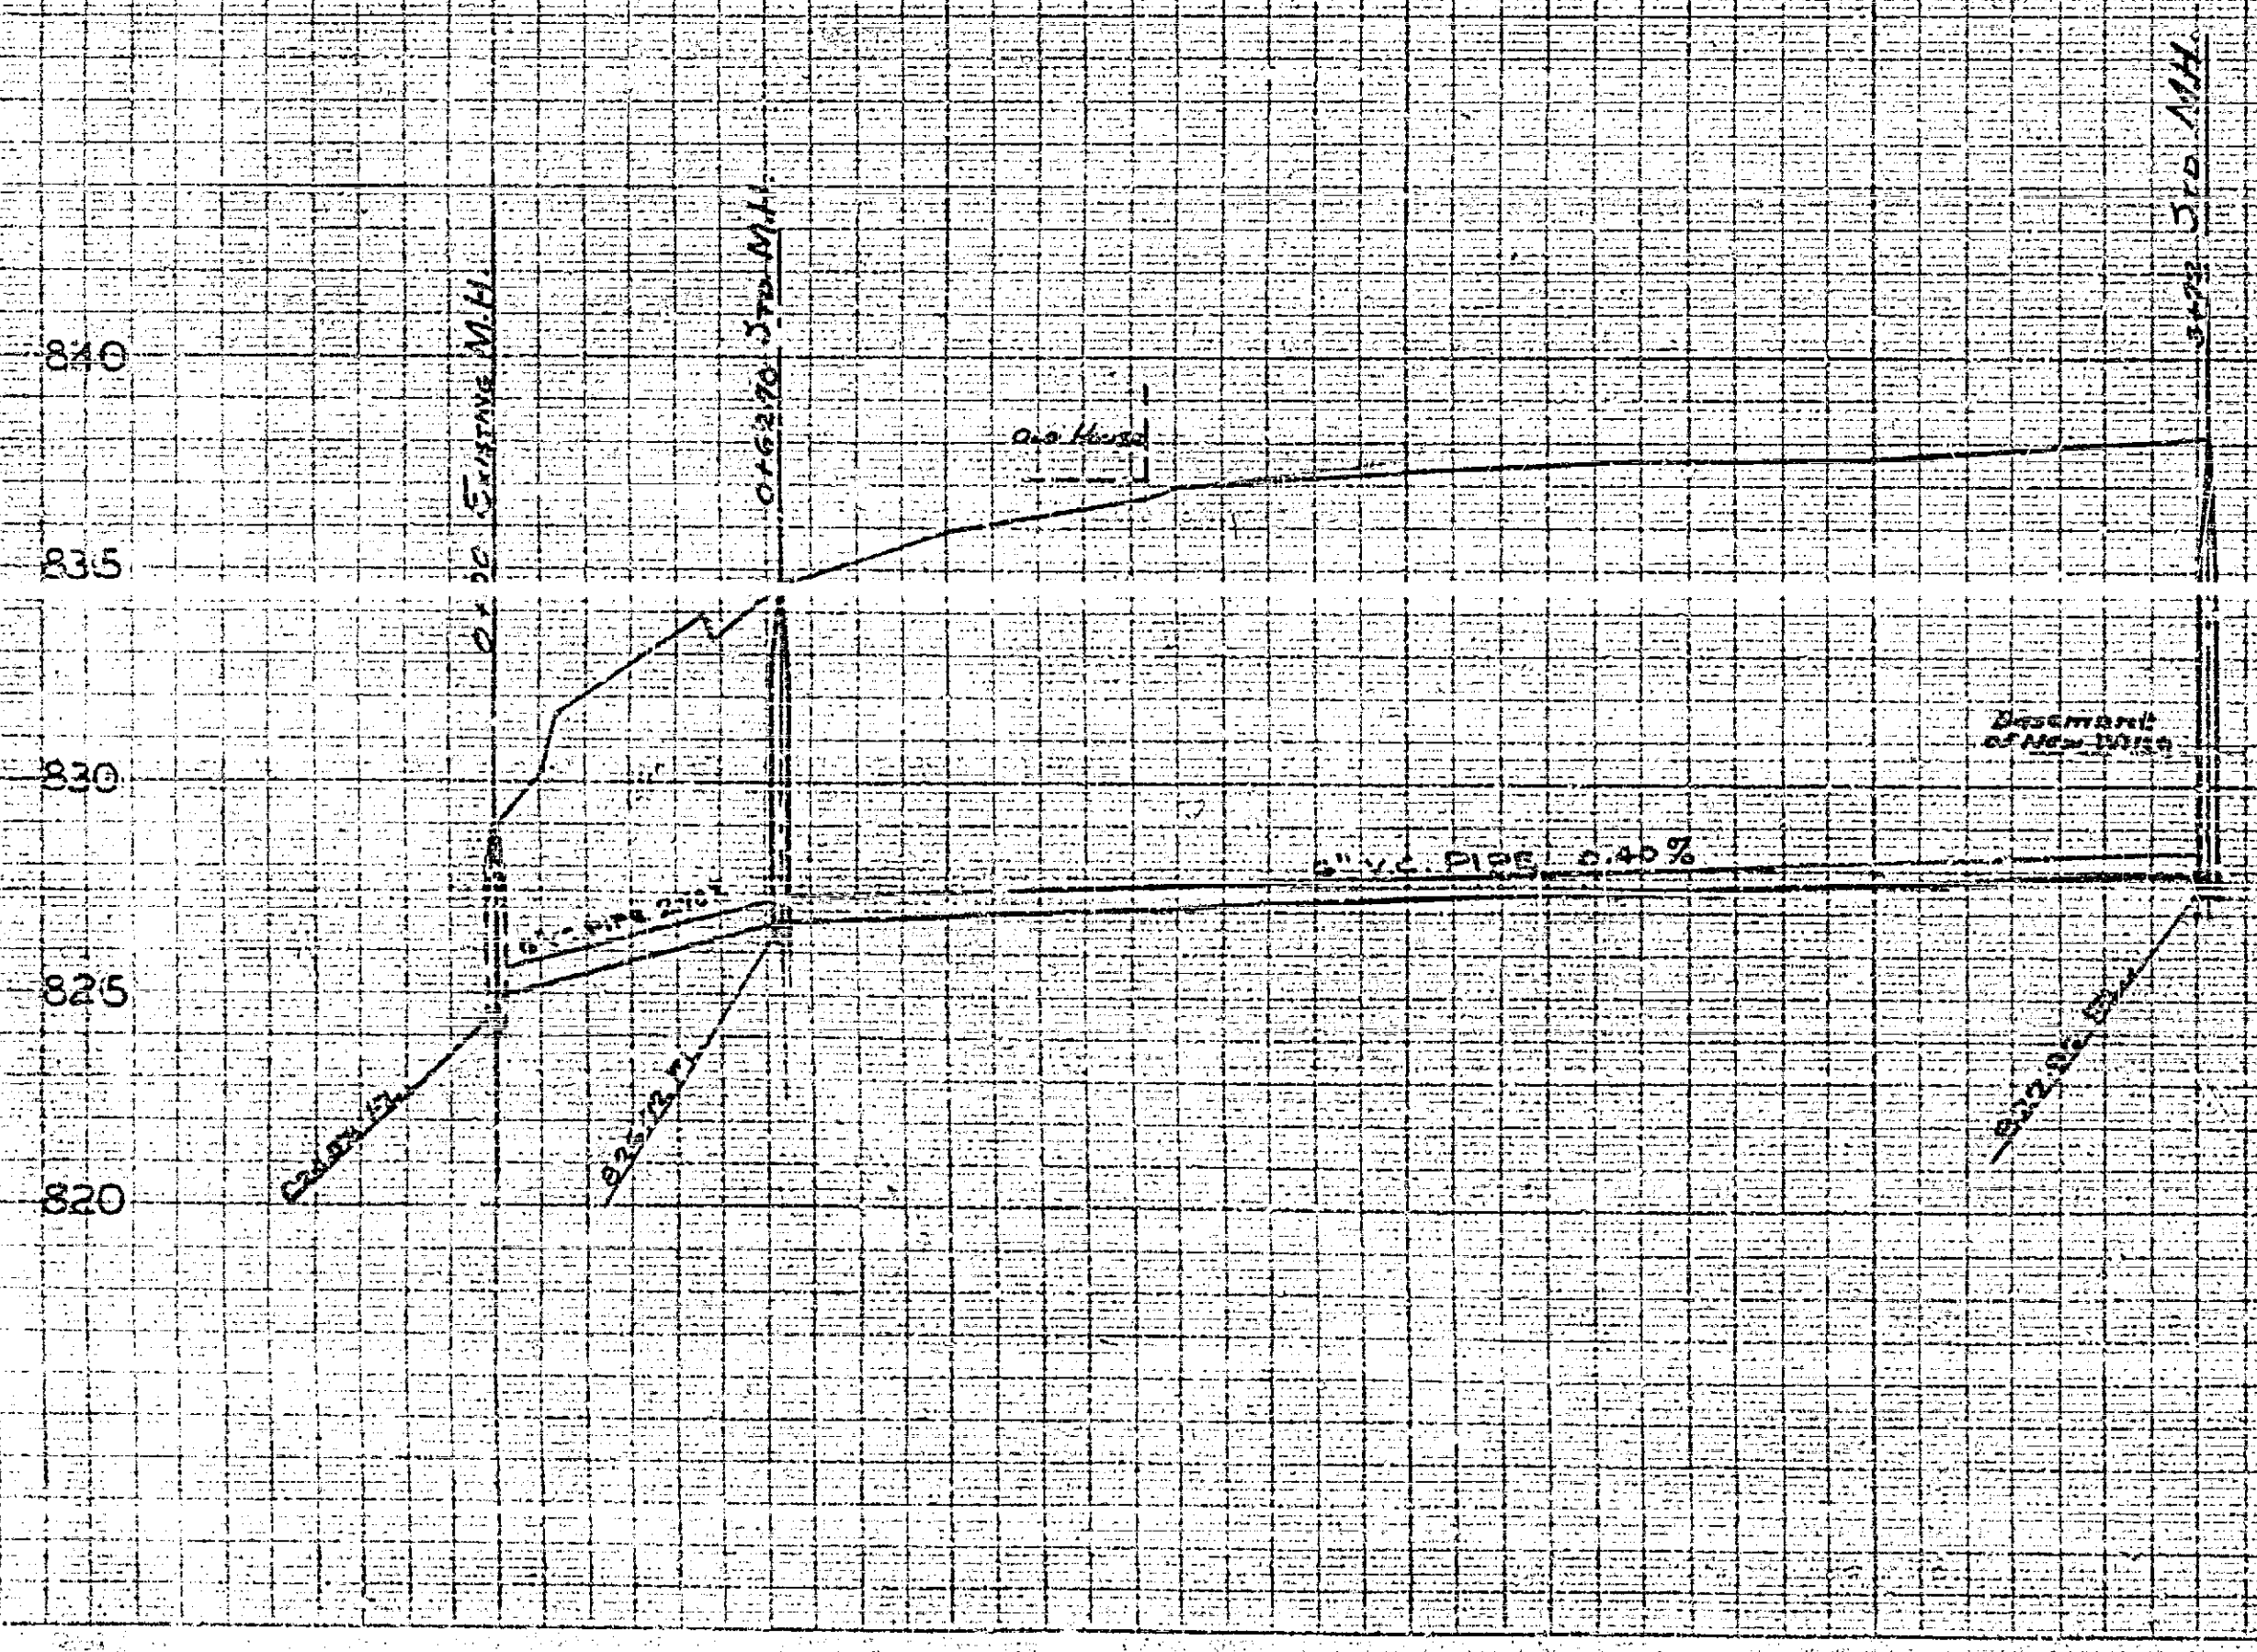

374B