



No 666  
PLAN AND PROFILE  
OUTFALL SEWER LINE  
FOR RIVERSIDE COLLEGE

BOARD OF EDUCATION  
RIVERSIDE CITY JUNIOR COLLEGE DISTRICT

MAY - 1950

BY  
ALBERT A. WEBB  
CIVIL ENGINEER

SCALE: AS SHOWN

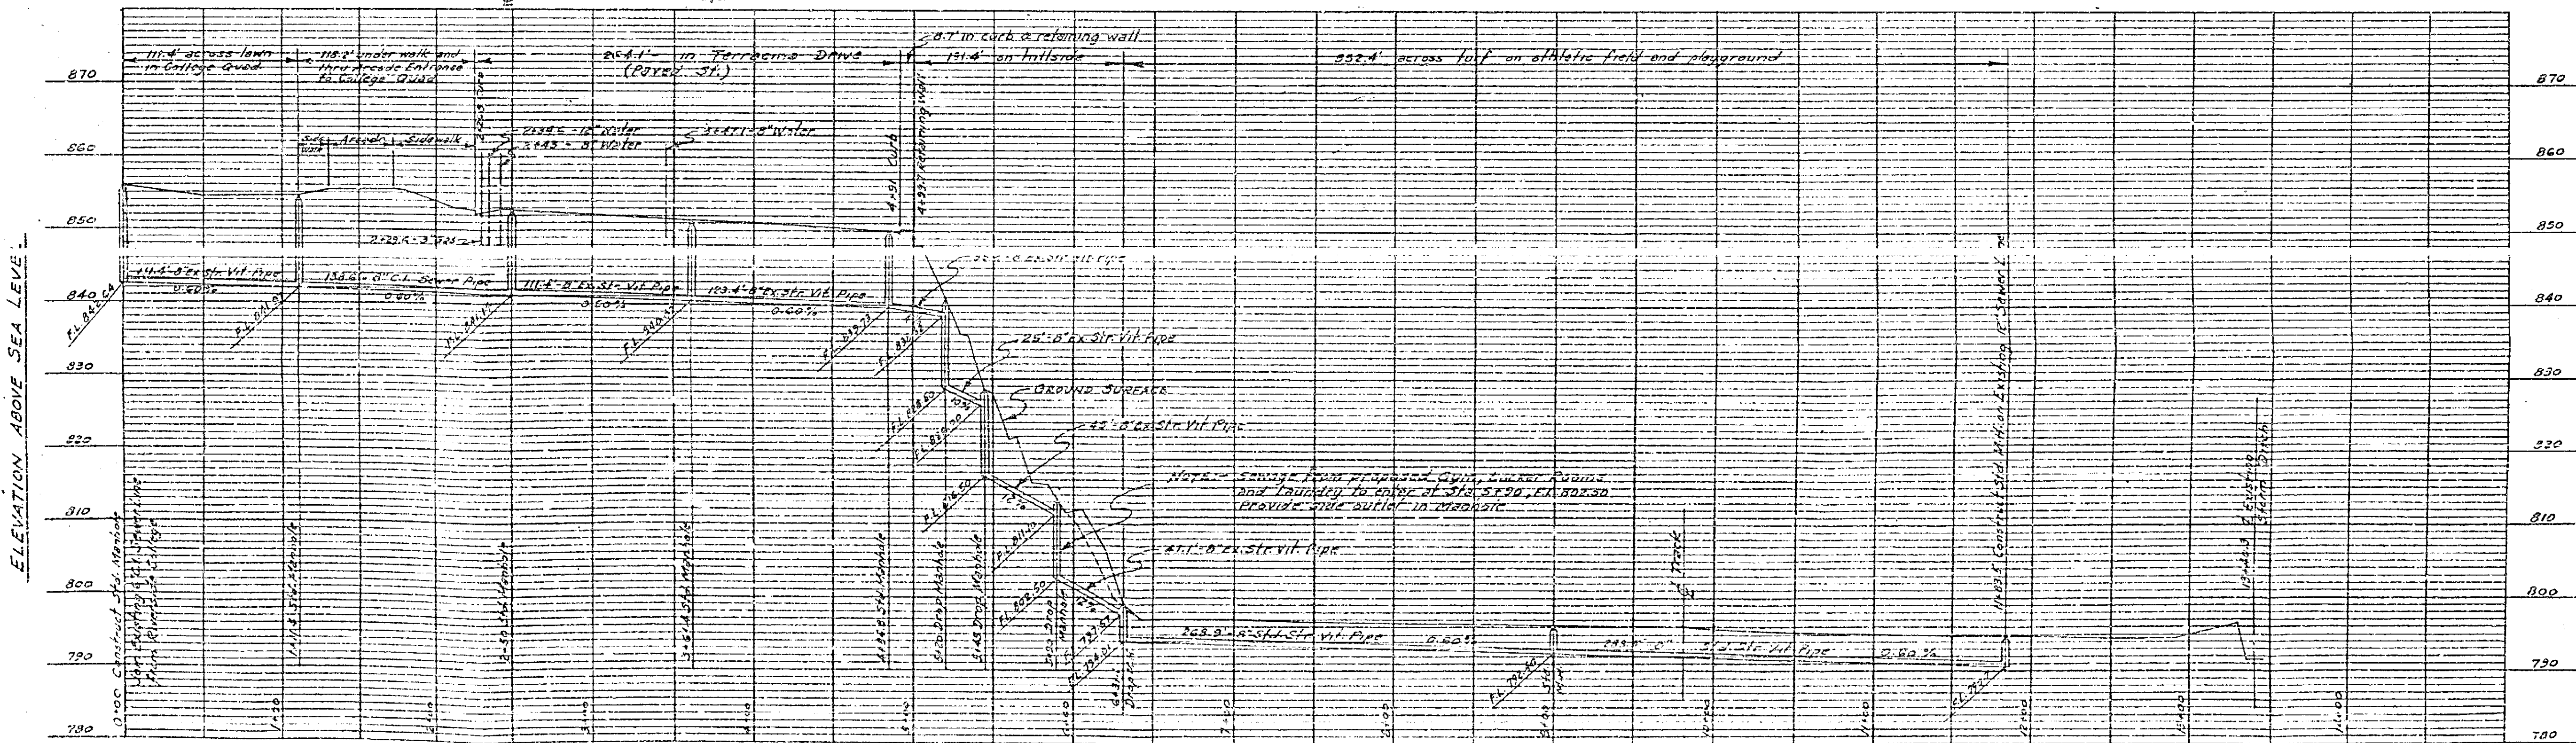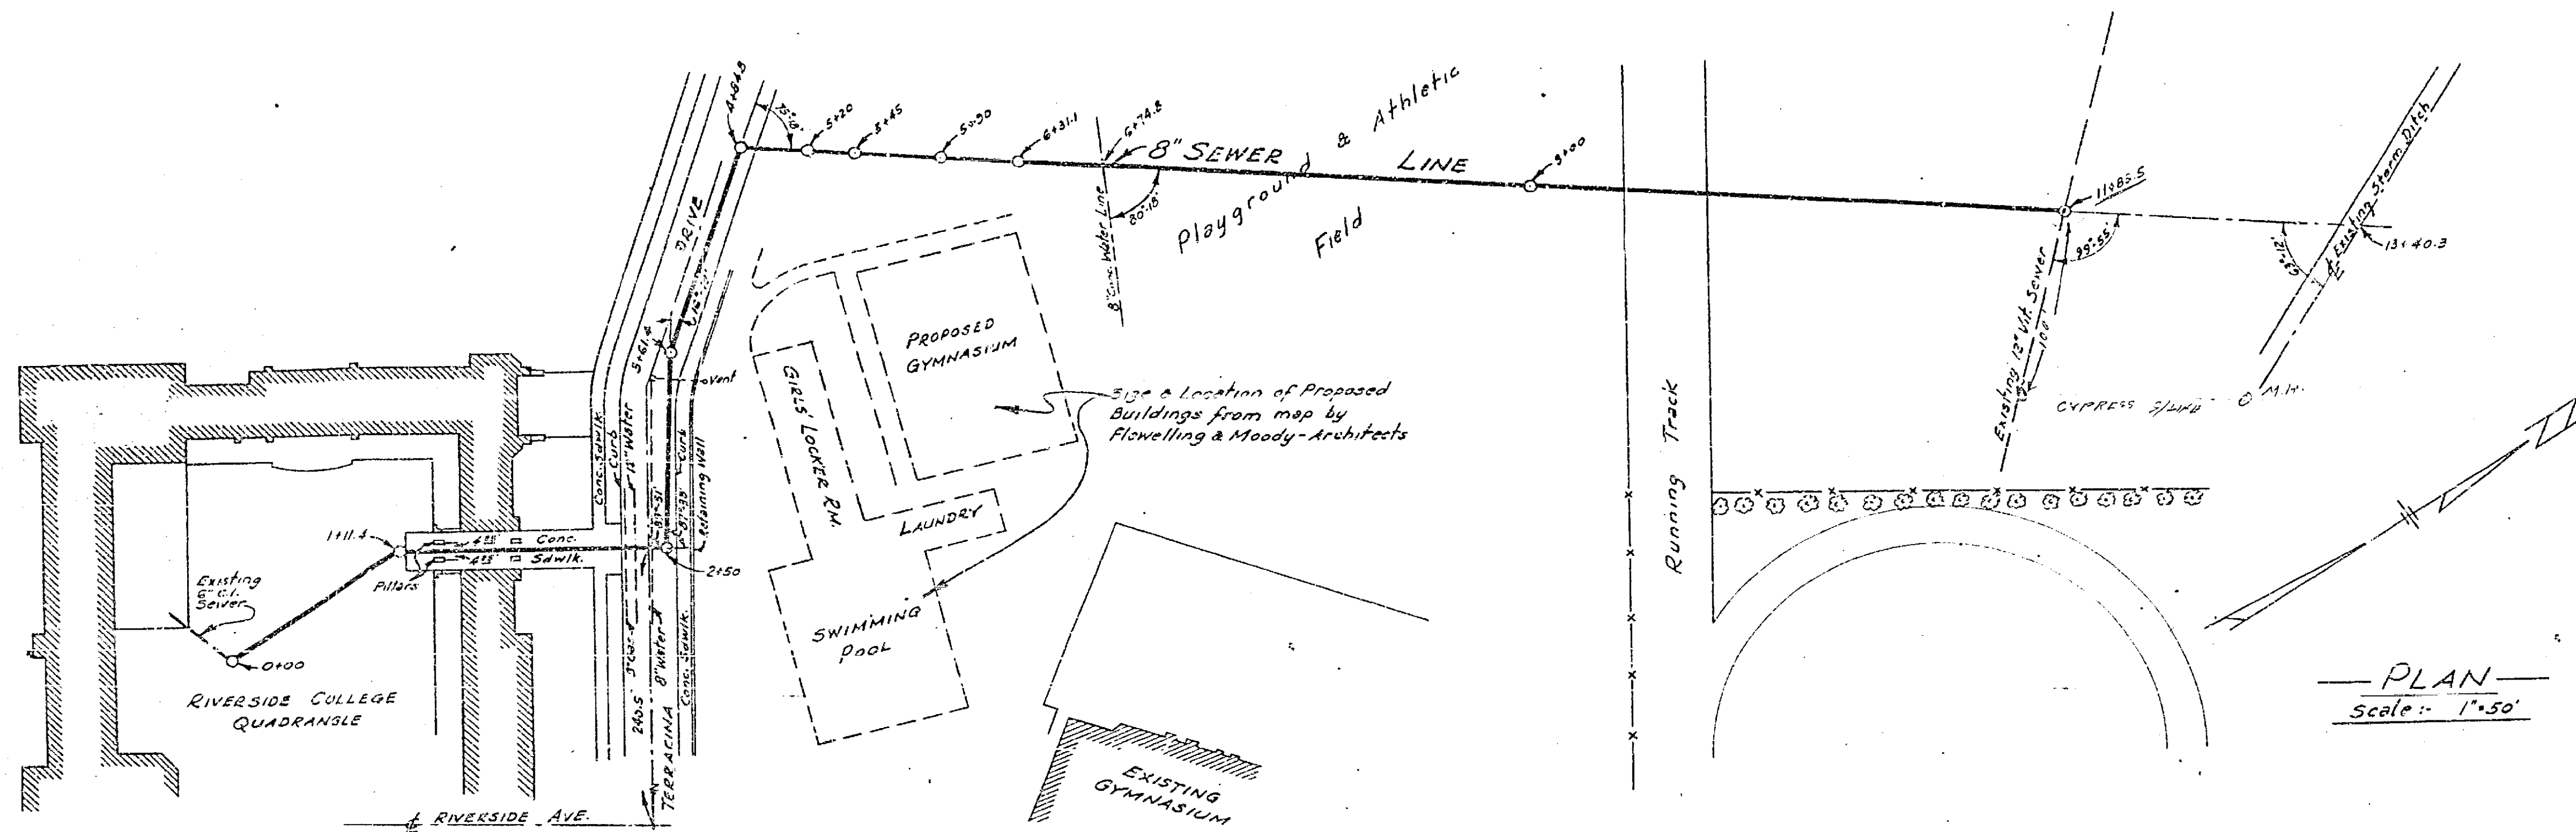

666