



PROFILE

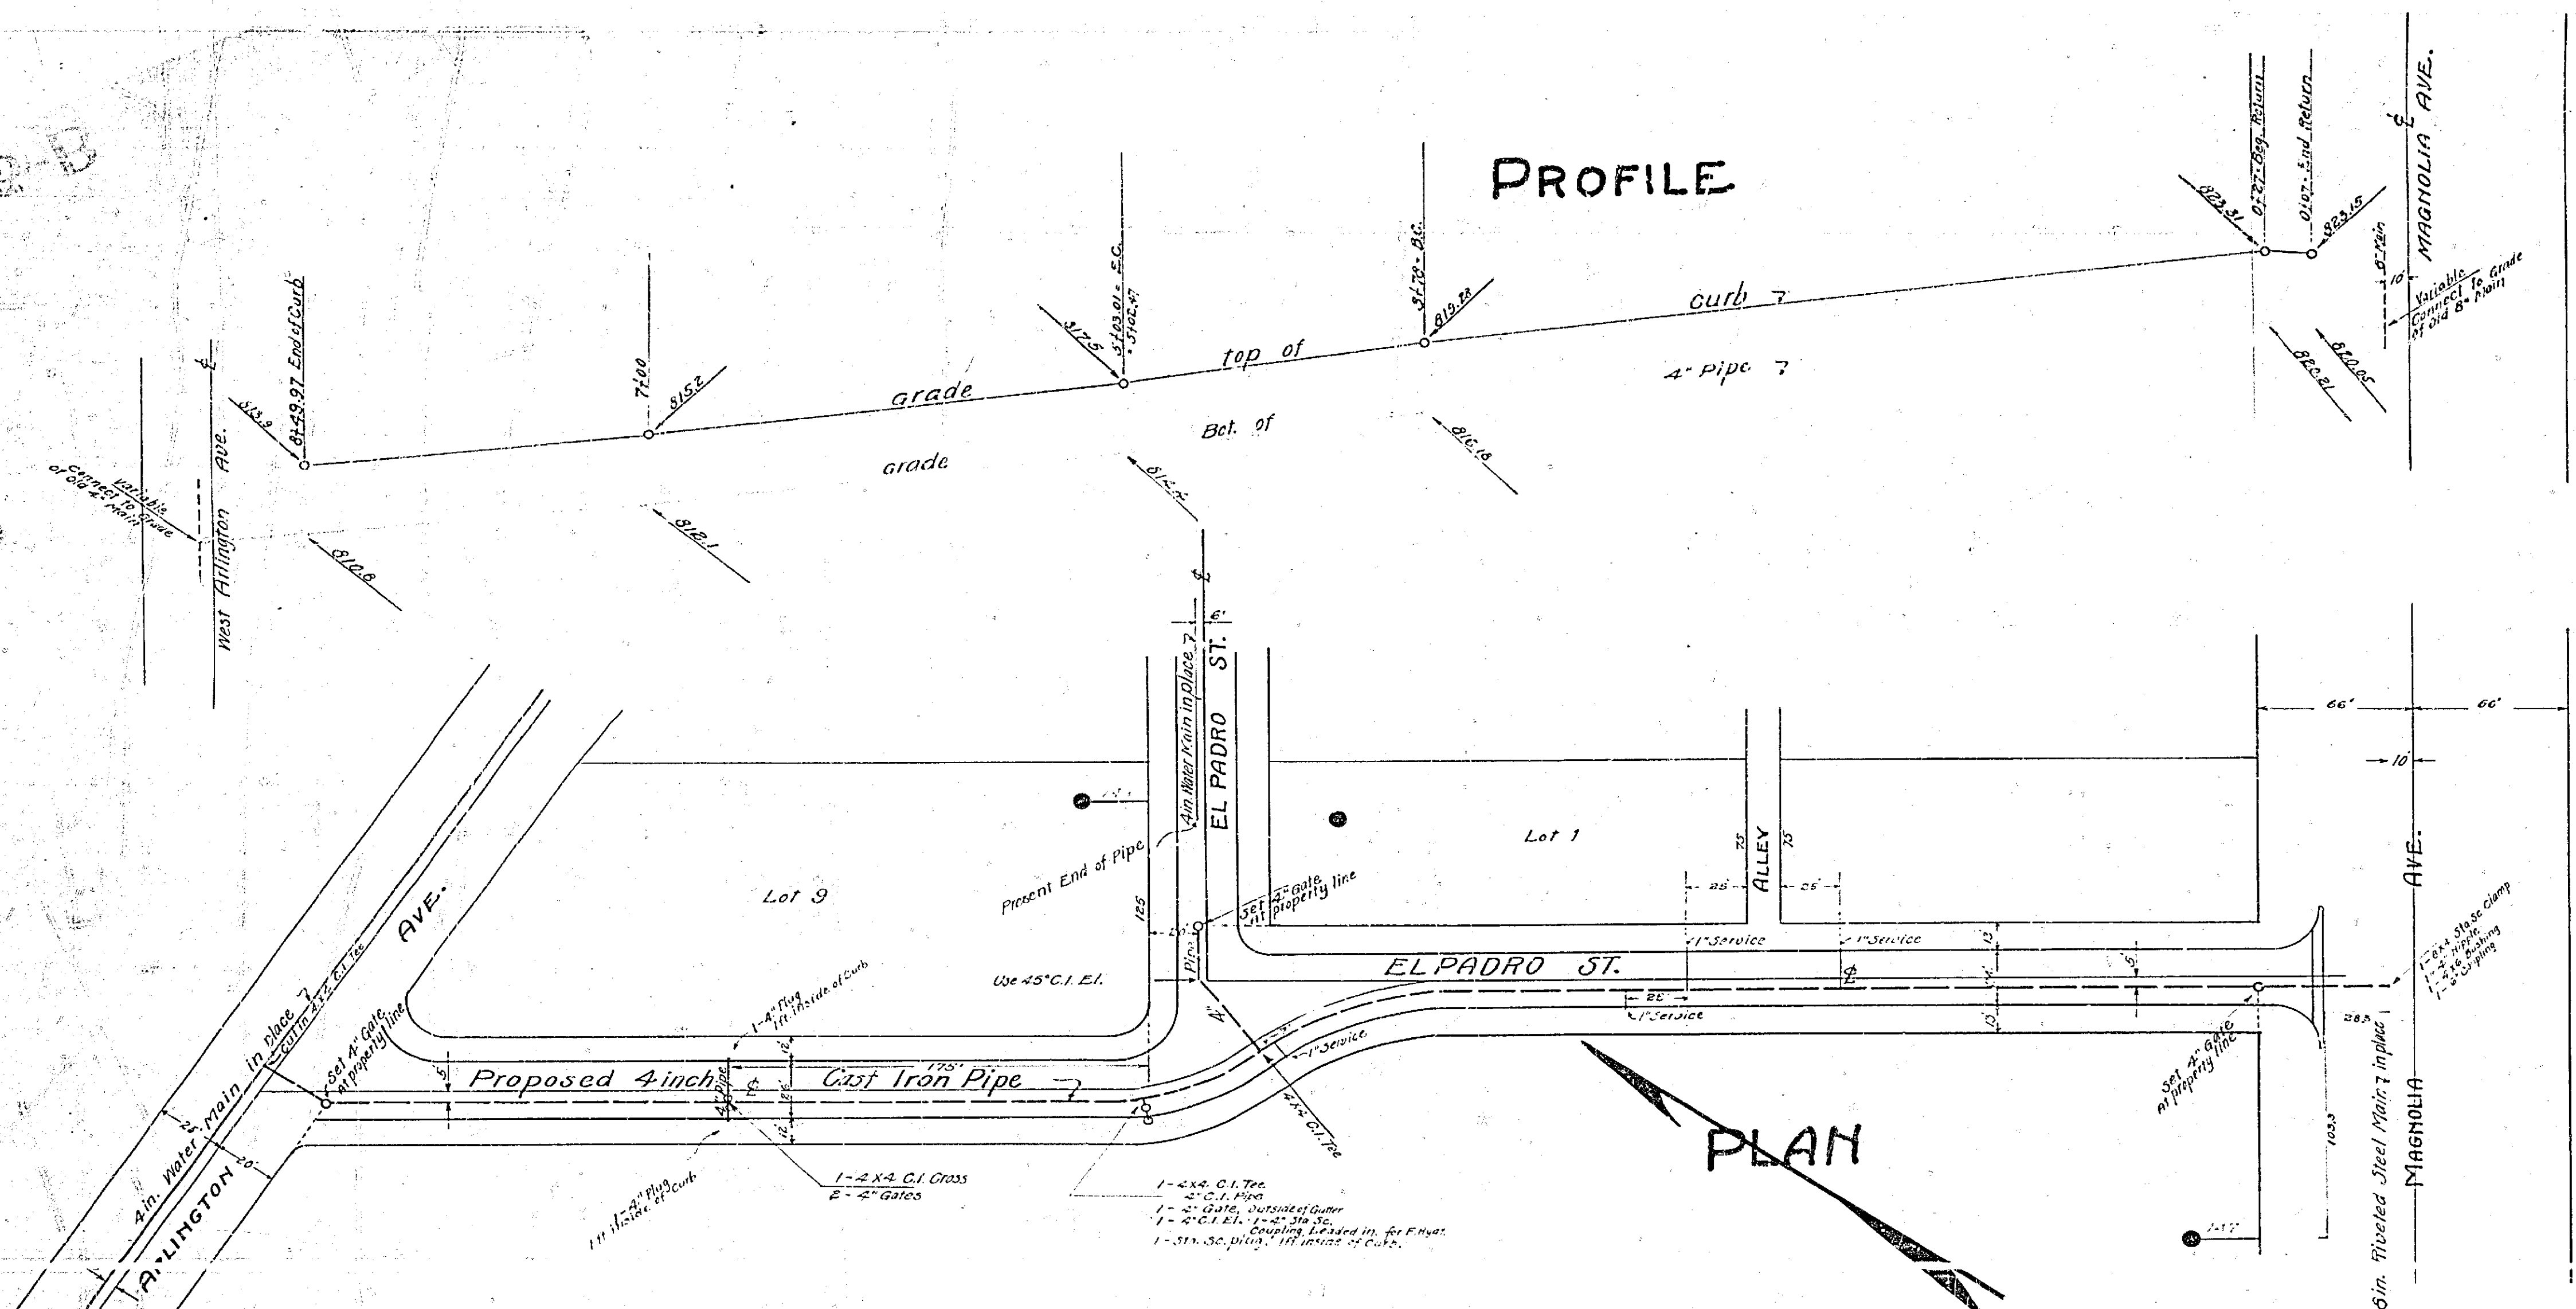

PLAN

**PLAN and PROFILE**  
of Domestic Water system to be  
installed in El Padro St. Magnolia Ave.  
to West Arlington Ave.  
RIVERSIDE MUNICIPAL WATER DEPT.  
To be done under the Act of 1911  
Scale 1 in. = 40 Ft. June 1929

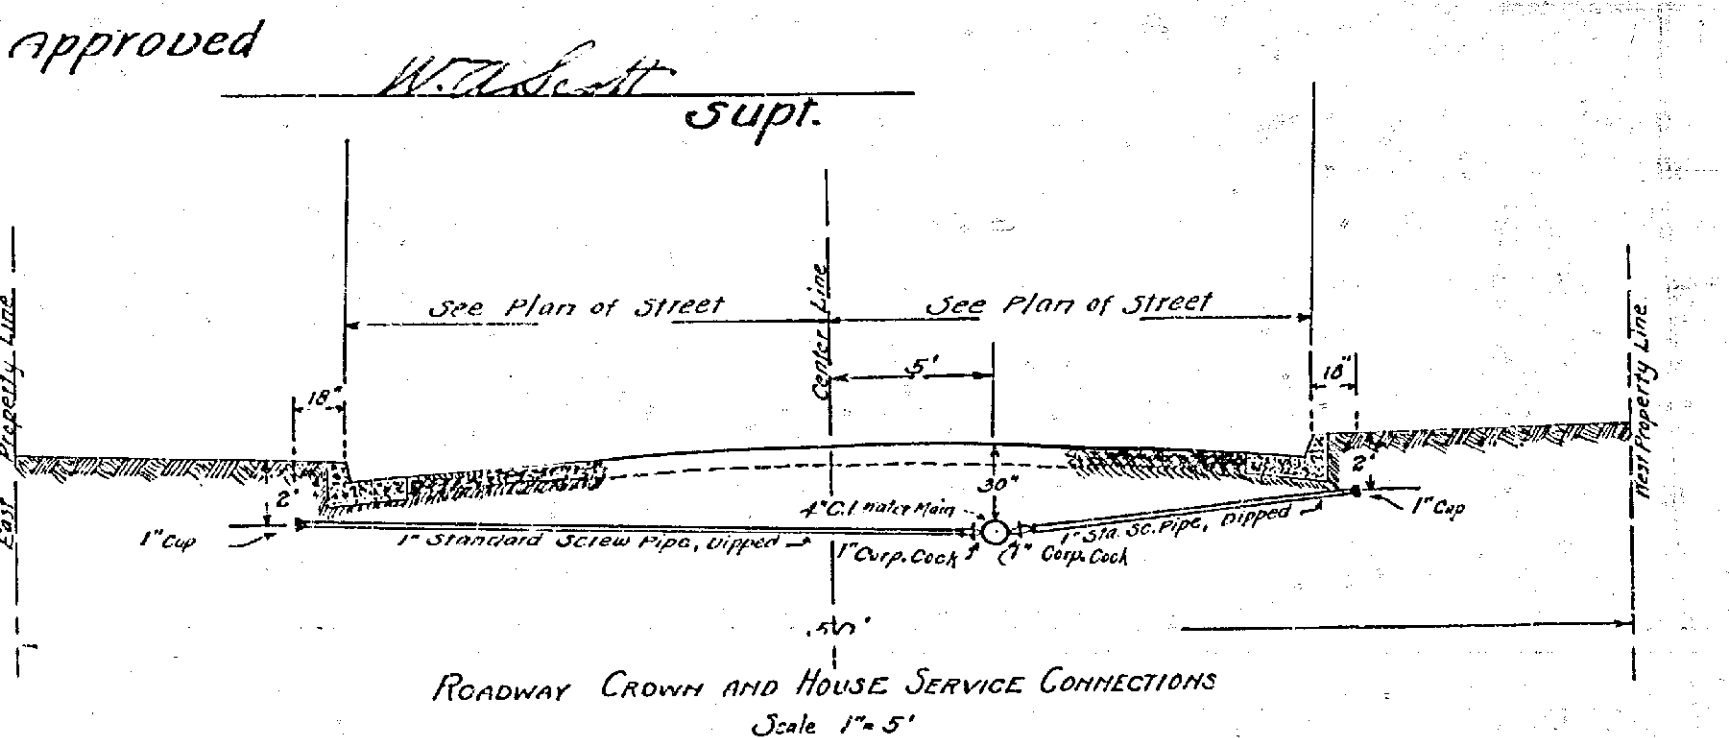

ROADWAY CROWN AND HOUSE SERVICE CONNECTIONS  
Scale 1" = 5'

935B