
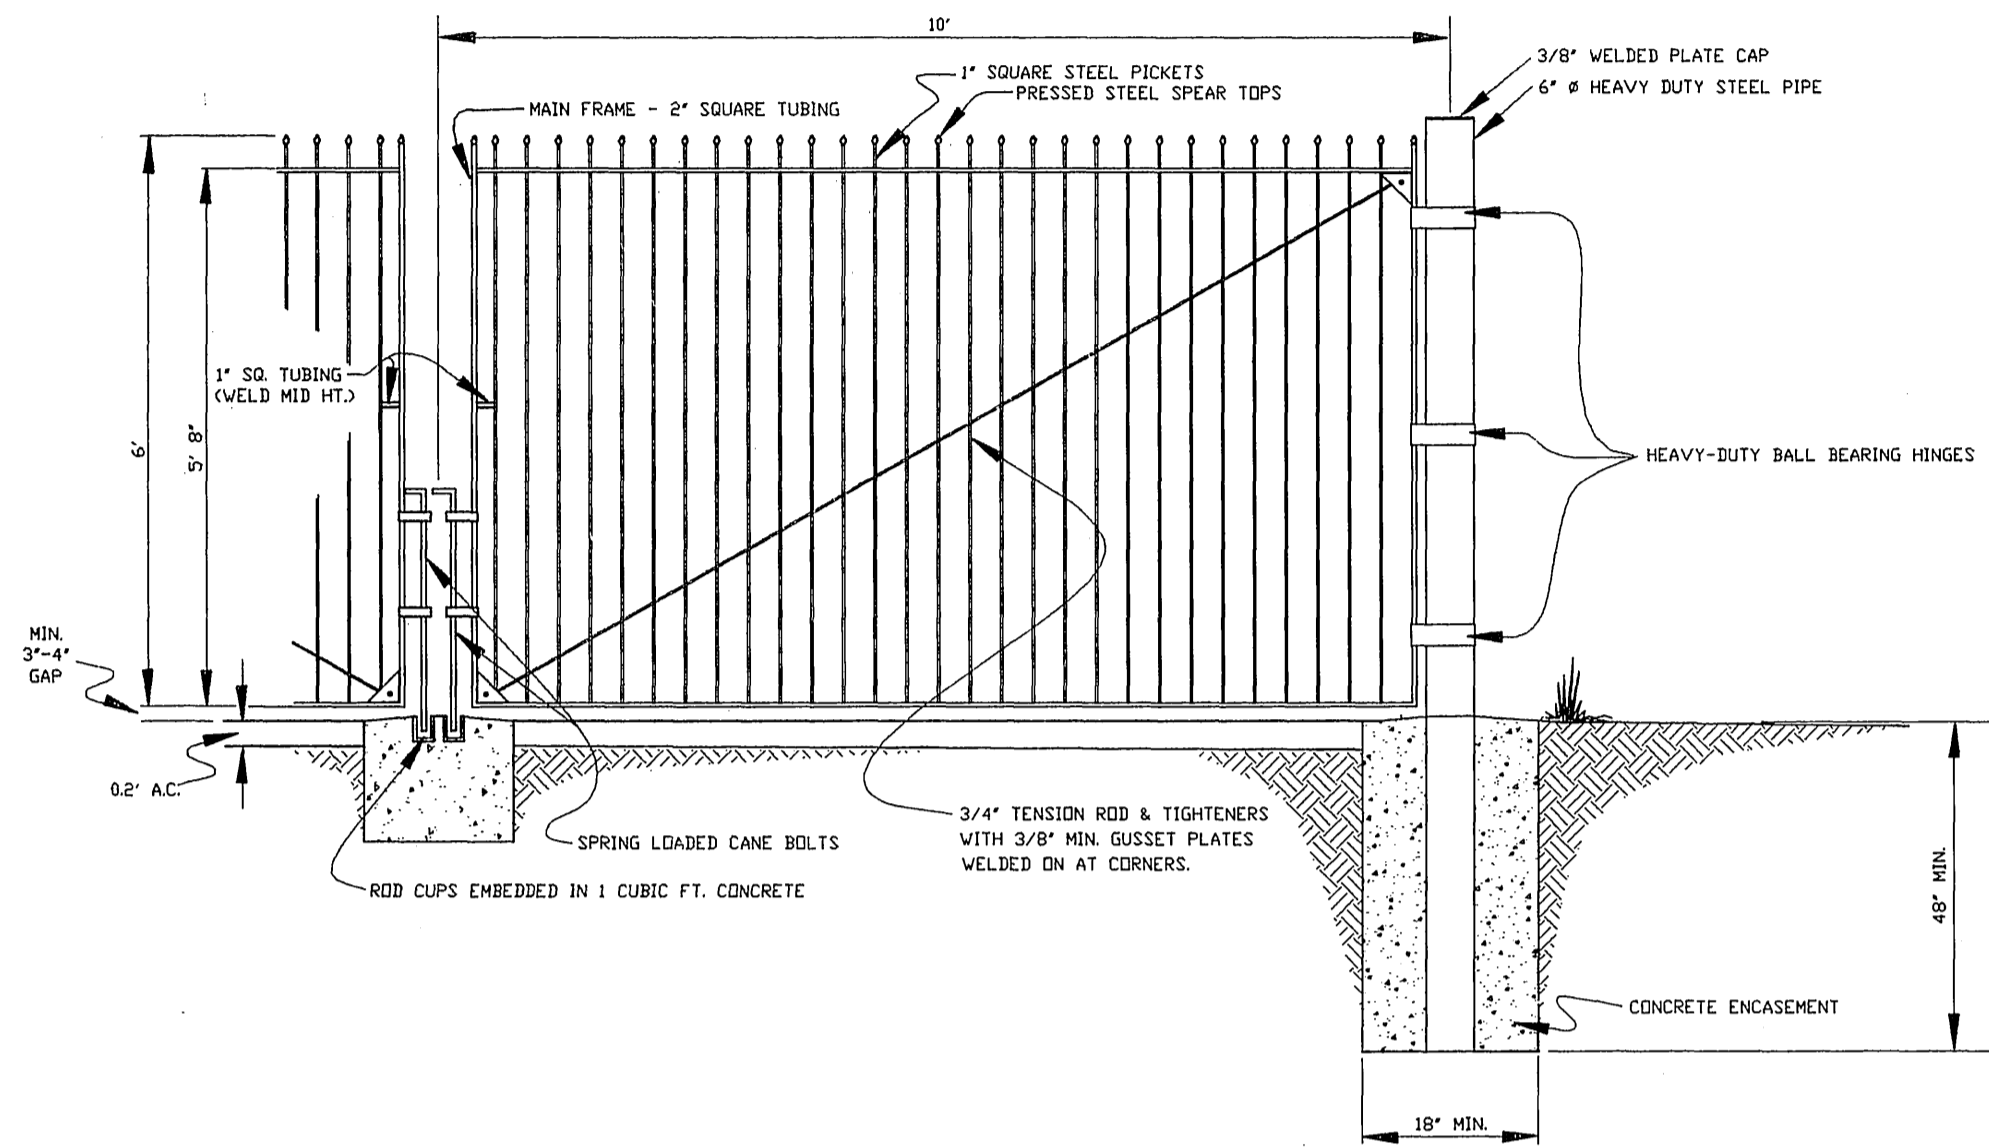



WEST ELEVATION

ORIGINAL SCALE: 1"=4'

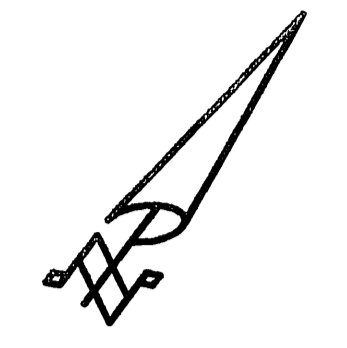

GATE DETAIL

NO SCALE

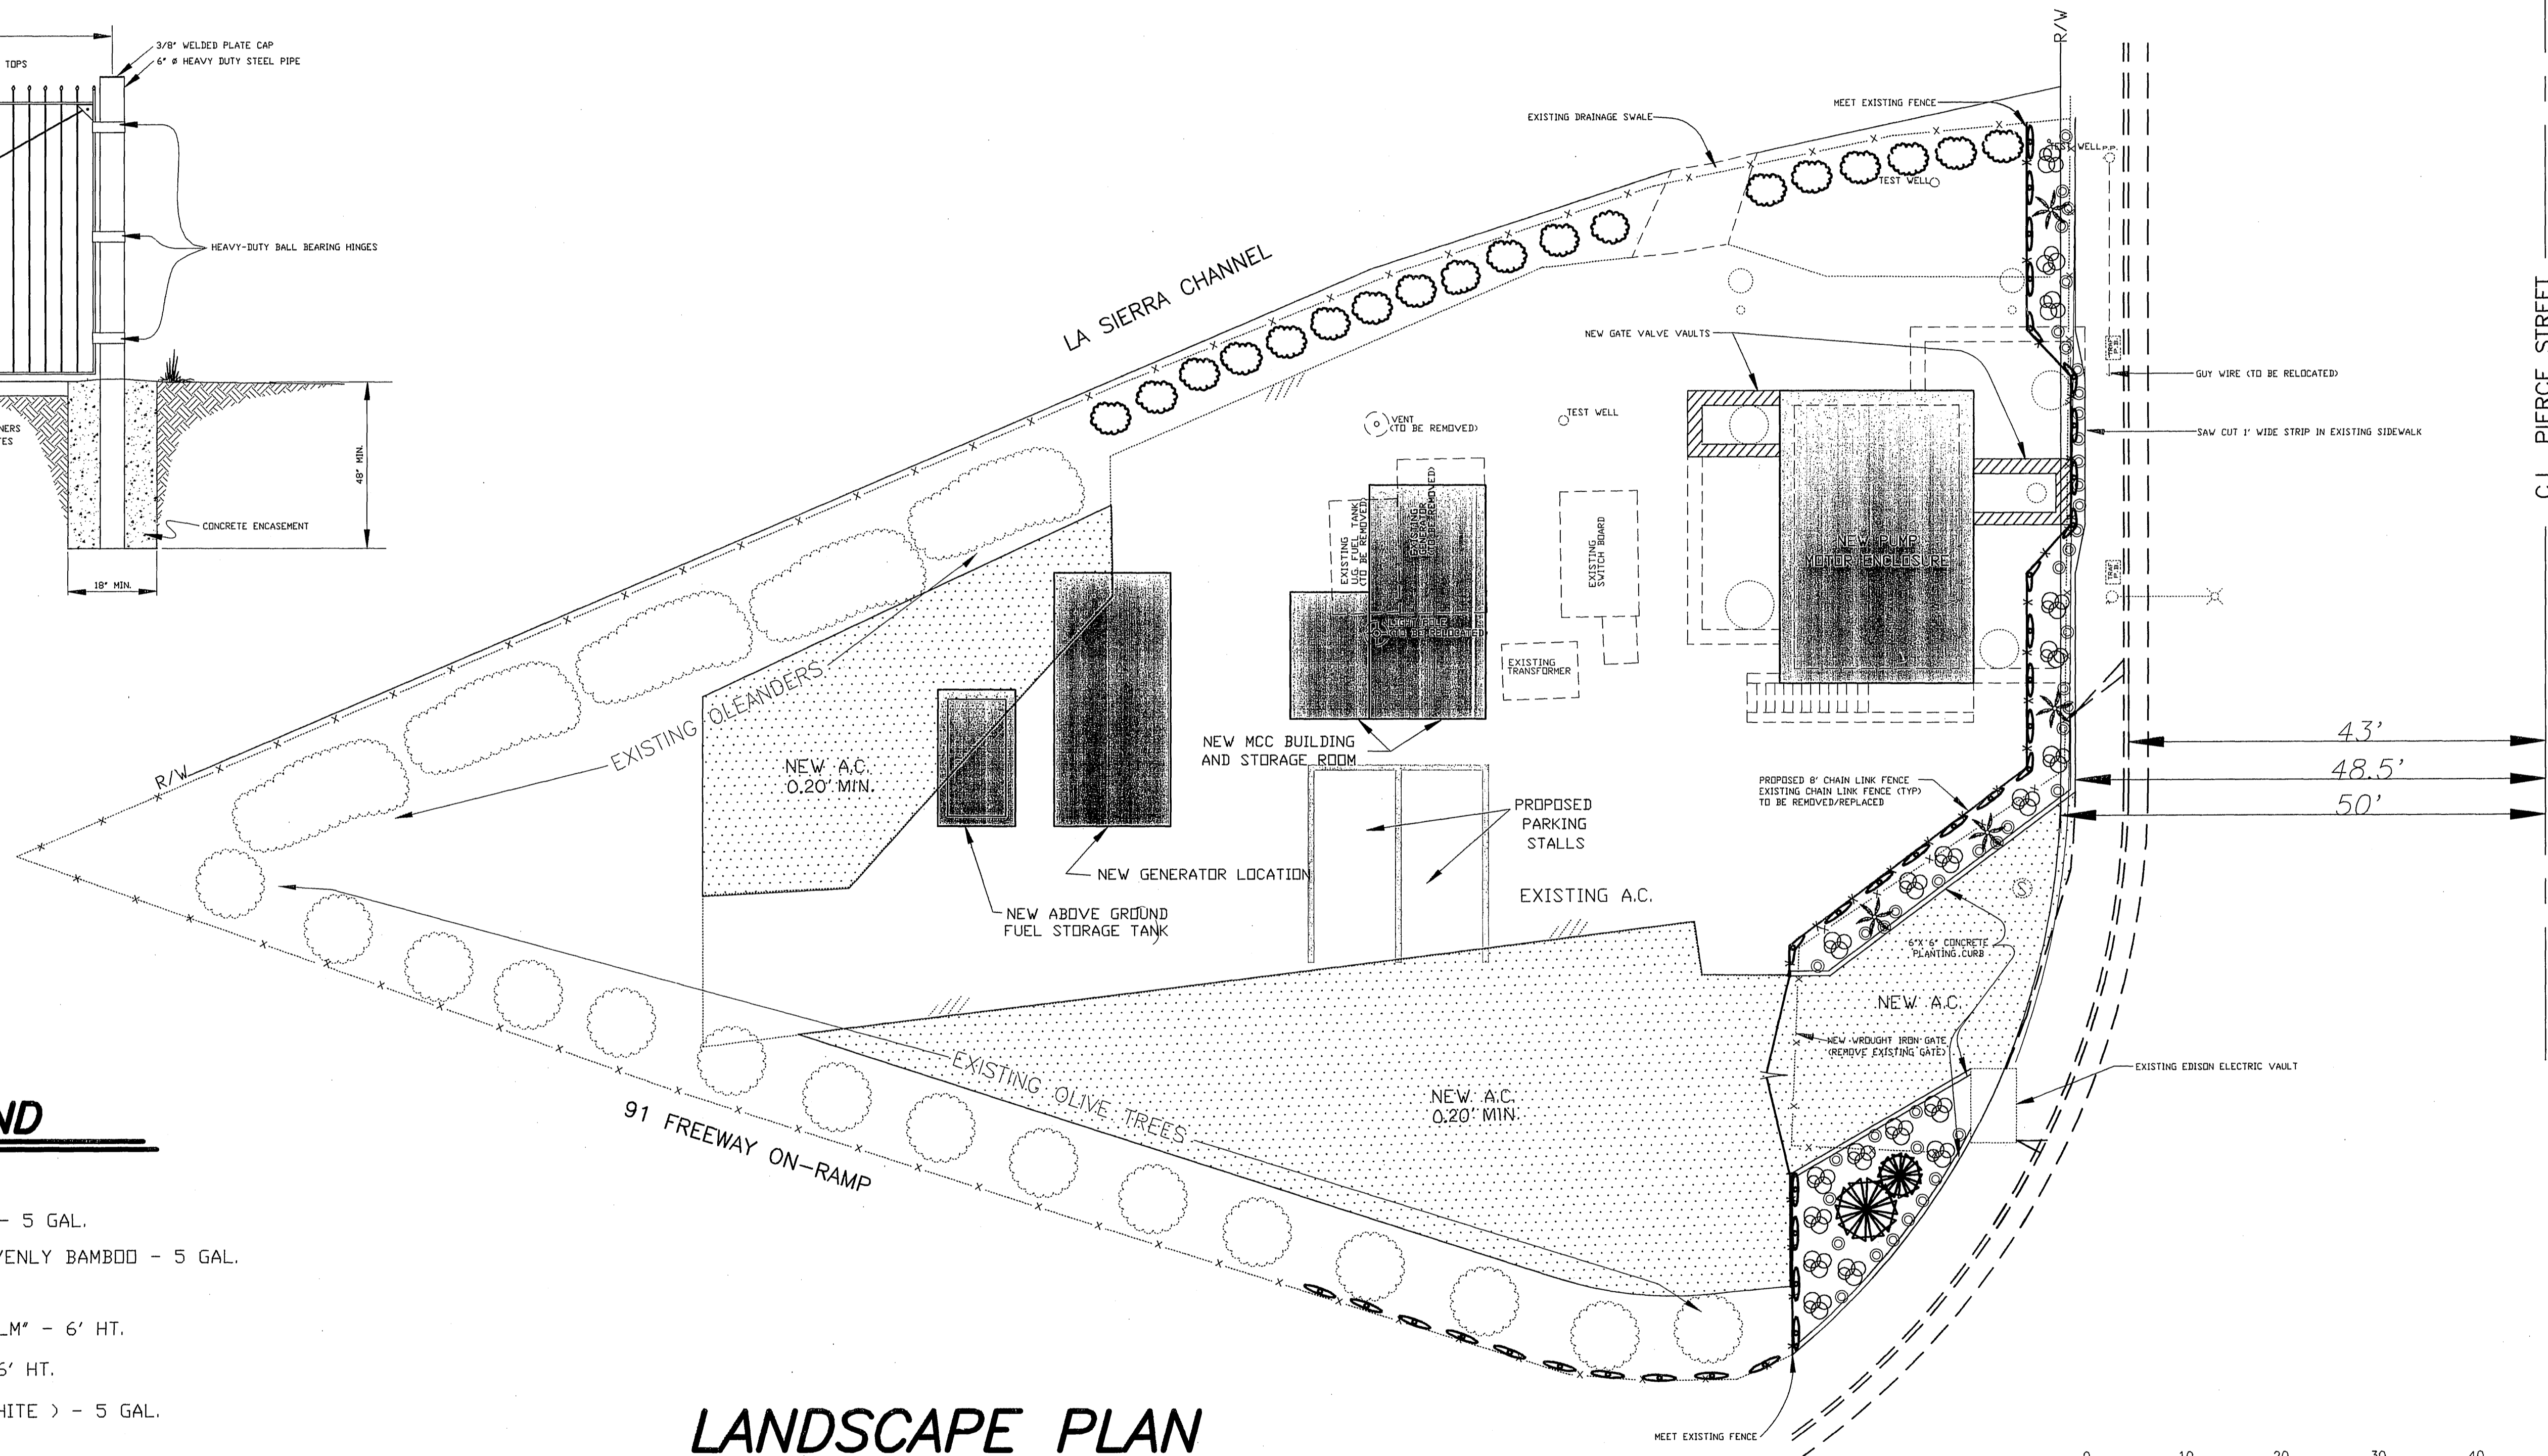

PROPOSED PLANT LEGEND

- QTY.
- 34 - PASSIFLORA ALATOCAERULEA "PASSION VINE" - 5 GAL.
 - 43 - NANDINA DOMESTICA "HARBOUR DWARF" HEAVENLY BAMBOO - 5 GAL.
 - 19 - RAPHIDOLEPIS INDICA "PINK LADY" - 5 GAL.
 - 2 - CHAMEAROPS HUMILIS "MEDITERRANEAN FAN PALM" - 6' HT.
 - 4 - TRACHYCARPUS FORTUNEI "WINDMILL PALM" - 6' HT.
 - 18 - NERIUM OLEANDER (ALTERNATING RED AND WHITE) - 5 GAL.

GENERAL NOTES

- 1 REFER TO OTHER PLAN SHEETS FOR BUILDING / ELECTRICAL DETAILS
- 2 REFER TO IRRIGATION PLAN SHEET L-2 FOR PLANTING DETAILS



ENGINEER IN RESPONSIBLE CHARGE
 Duane K. Greenwood
 DUANE K. GREENWOOD
 R.C.E. No. 43965 expires 6/30/97
 DATE 5/25/94

MARK	REVISIONS	APPR.	DATE


CITY OF RIVERSIDE, CALIFORNIA
 PUBLIC WORKS DEPARTMENT


APPROVED BY	BY	DATE	APPROVED BY
DEPUTY P.W. DIRECTOR	<i>[Signature]</i>	5/27/94	<i>[Signature]</i>
PRINCIPAL ENGINEER	<i>[Signature]</i>	5/27/94	PUBLIC WORKS DIRECTOR
CHIEF P.W. INSPECTOR	<i>[Signature]</i>	5/27/94	
PARKS DEPARTMENT			

DATE 5/27/94


PIERCE STREET
 PUMP STATION UPGRADE

PARK AND RECREATION DEPT.
 CHK # 3677-S
 ACCOUNT NUMBER
 551-741290-440301-40137
S-1636
 SHEET **L-1** OF **2**
 FILE NO. :

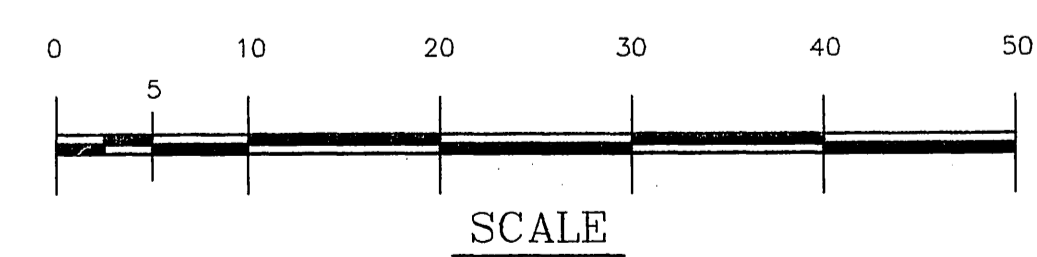

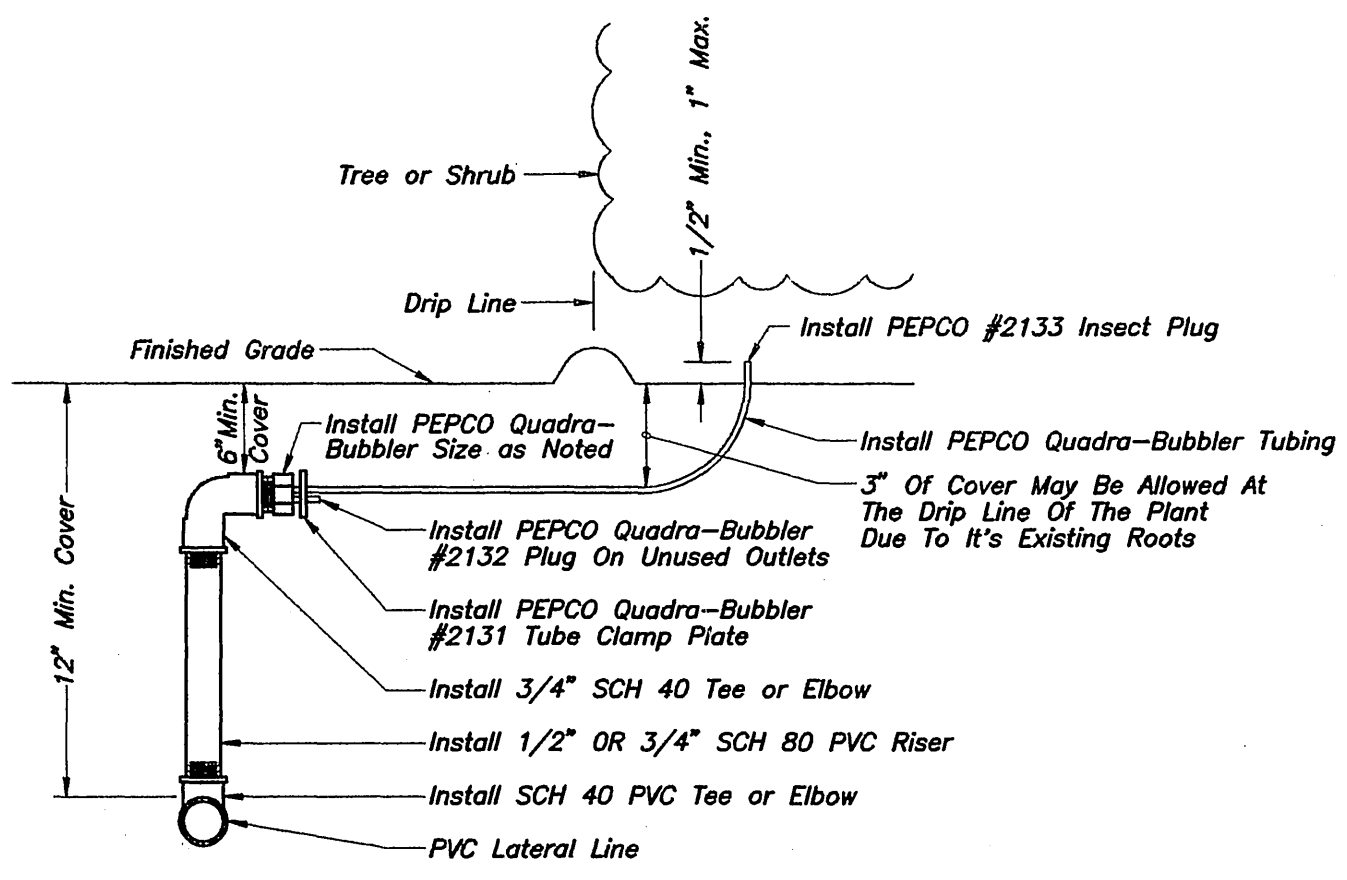


**TYPICAL QUADRA BUBBLER
INSTALLATION DETAIL**
NOT TO SCALE

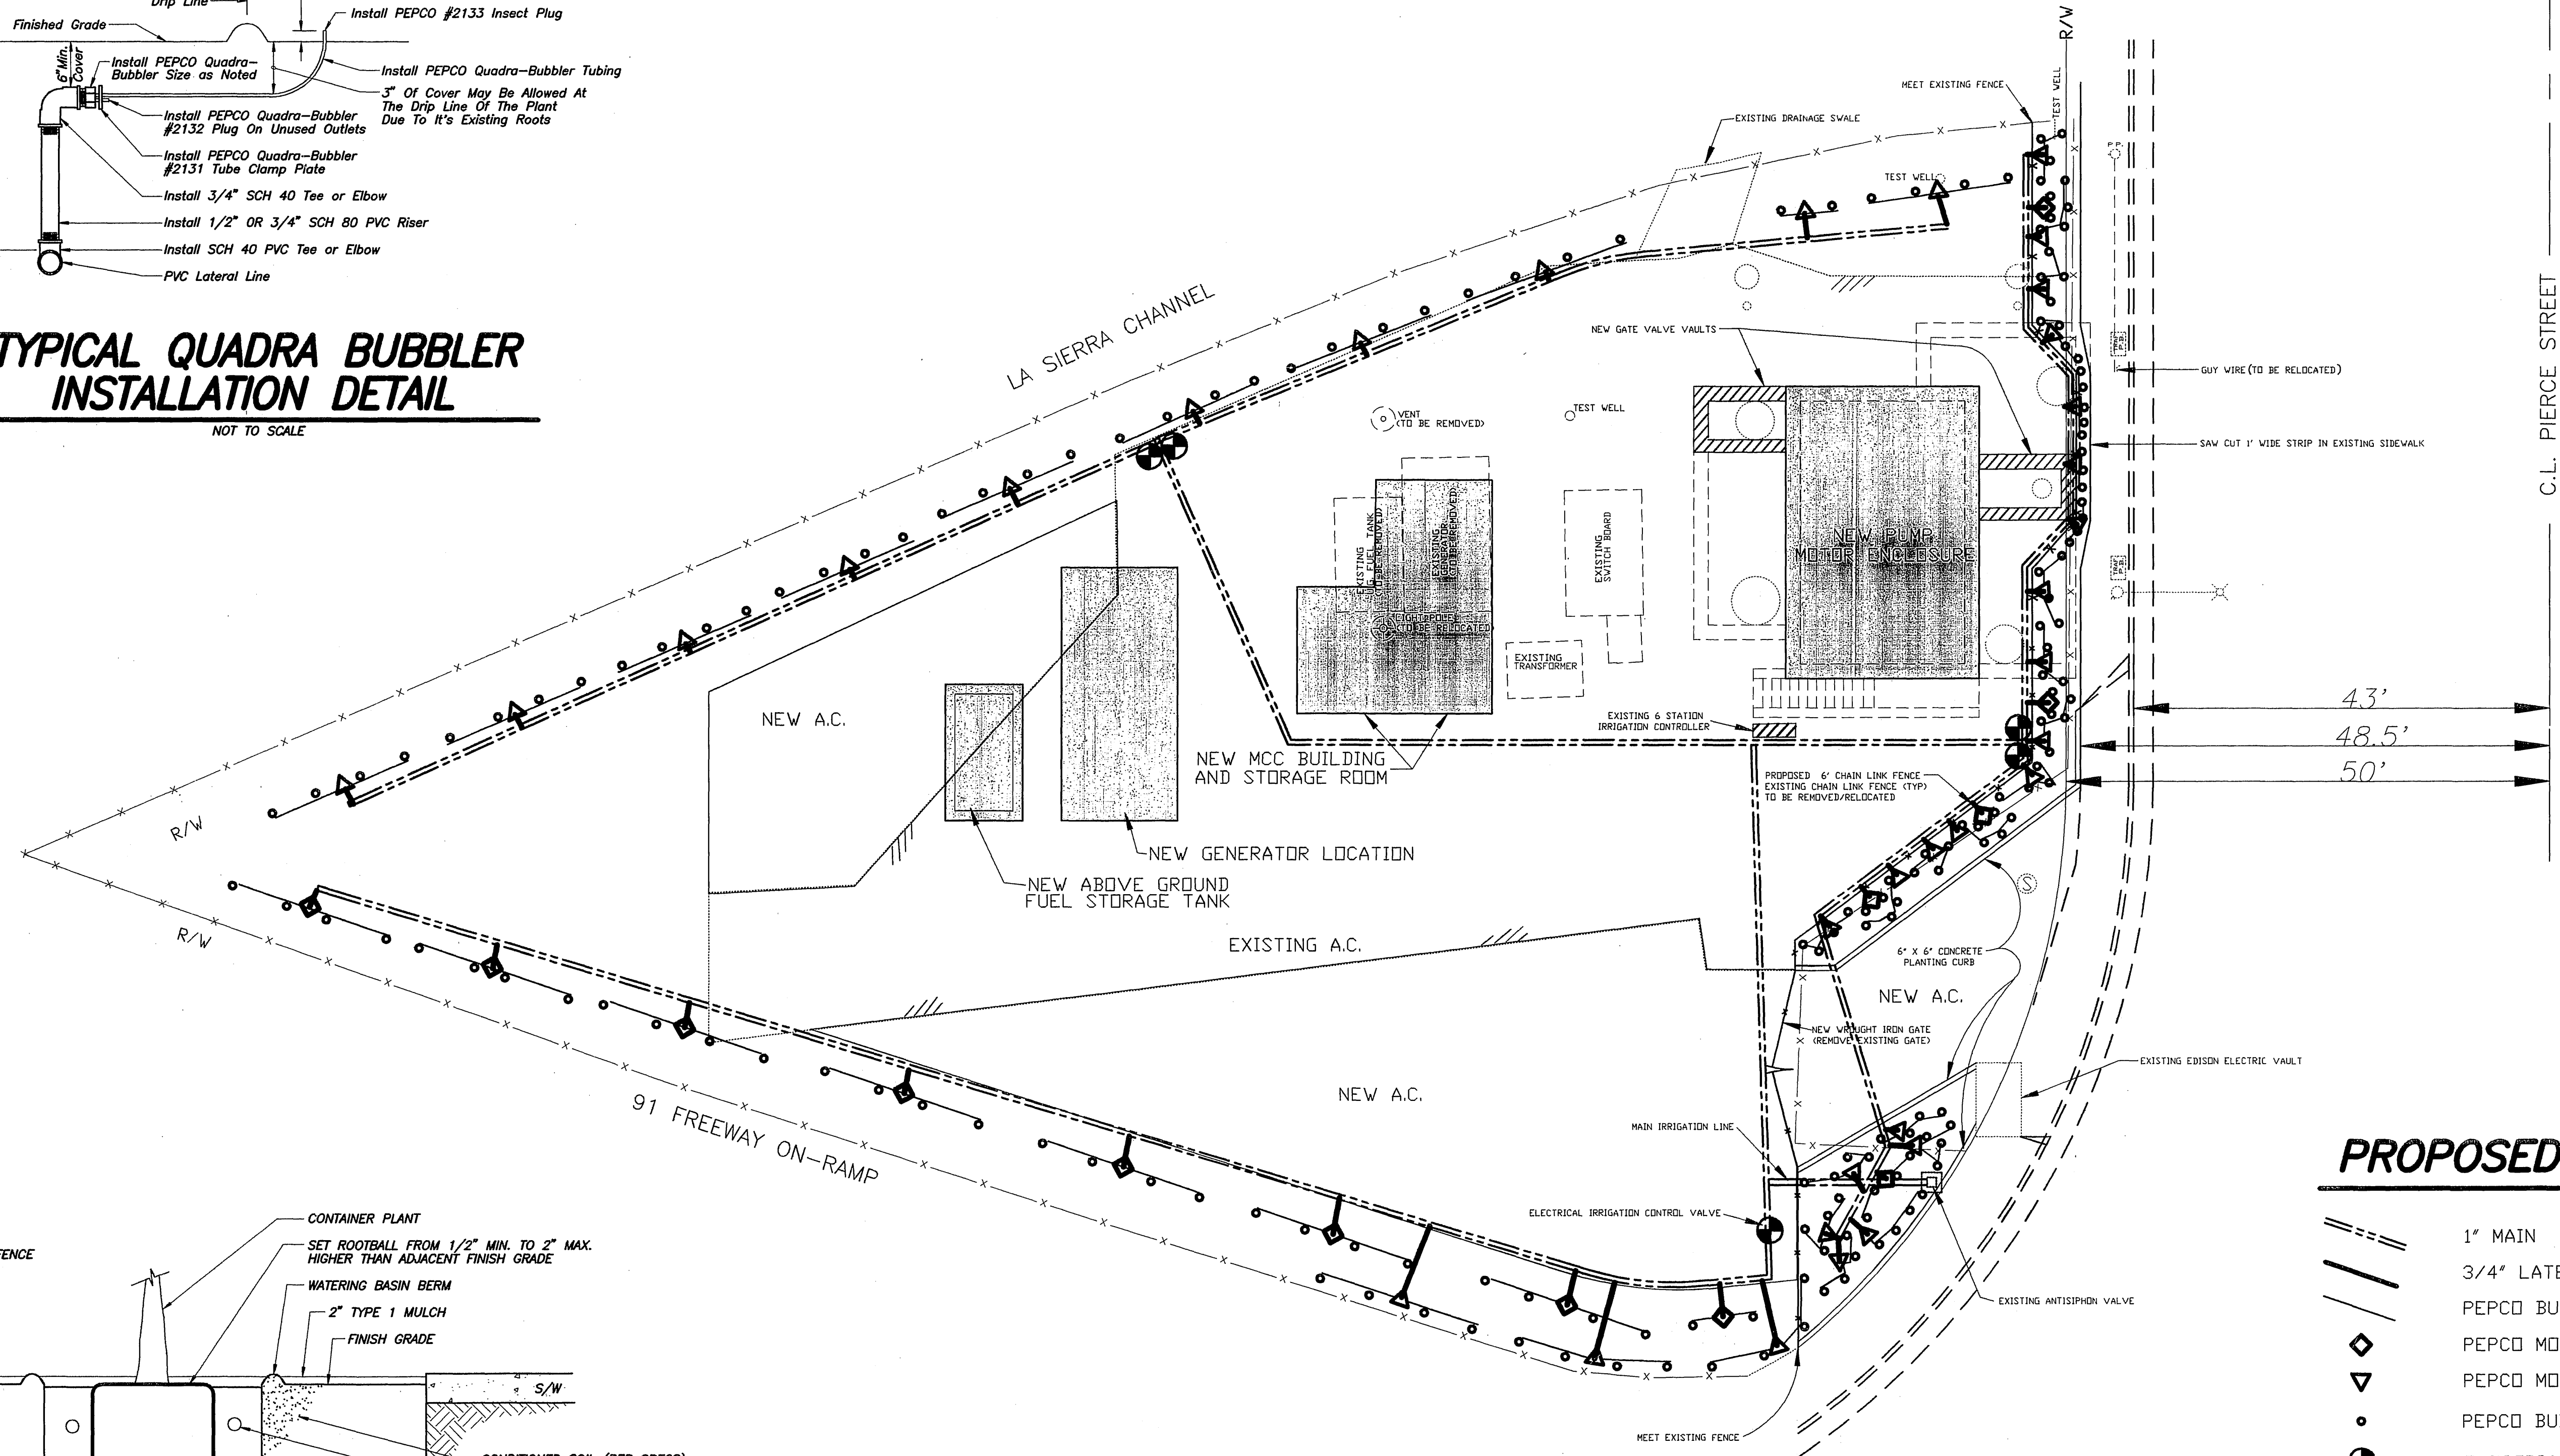


PROPOSED IRRIGATION LEGEND

- 1" MAIN LINE (SCHEDULE 40) PVC
- 3/4" LATERAL (SCHEDULE 40) PVC
- PEPCO BUBBLER TUBING
- PEPCO MODEL #9633 BUBBLER FITTING
- PEPCO MODEL #5633 BUBBLER FITTING
- PEPCO BUBBLER EMMITTERS
- ELECTRIC CONTROL VALVE

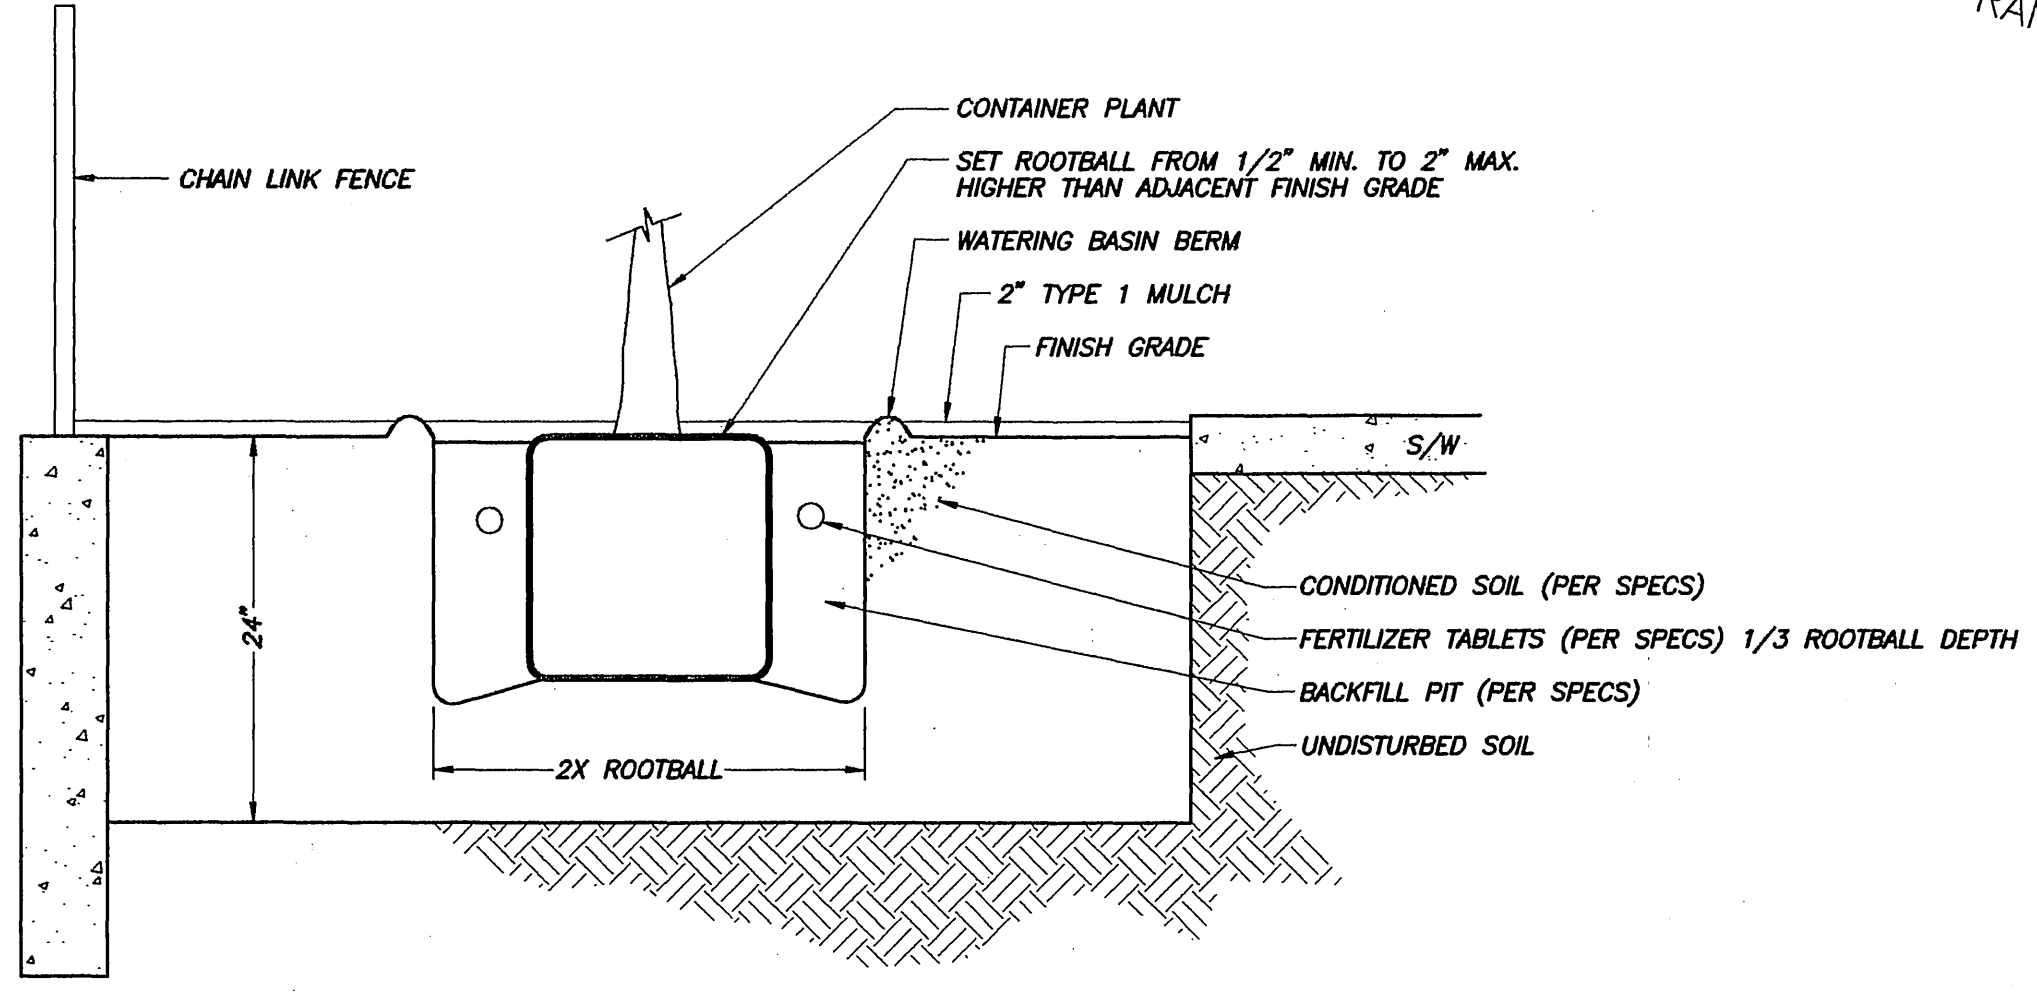

PLANTING DETAIL
NOT TO SCALE

IRRIGATION PLAN

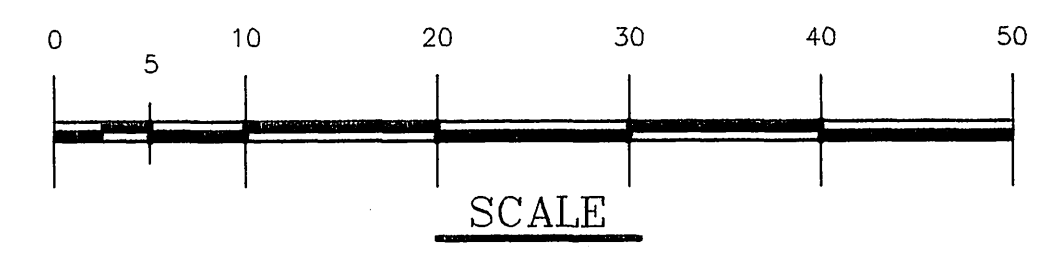

**ENGINEER IN
RESPONSIBLE CHARGE**
DUANE K. GREENWOOD
R.C.E. No. 43965 expires 6/30/97
DATE 5/25/94

NO.	REVISIONS	APPR.	DATE

DESIGNED BY P.H./D.G. DRAWN BY P.H./C.D. CHECKED BY [Signature]

CITY OF RIVERSIDE, CALIFORNIA
PUBLIC WORKS DEPARTMENT
APPROVED BY [Signature] DATE 5/27/94
DEPUTY P.W. DIRECTOR
PRINCIPAL ENGINEER
CHIEF P.W. INSPECTOR
PARKS DEPARTMENT

**PIERCE STREET
PUMP STATION UPGRADE**
ORIGINAL SCALE: 1" = 10'

PARK AND RECREATION DEPT.
CHK. # 3677-S
ACCOUNT NUMBER
551-741290-440301-40137
S-1636
SHEET **L-2** OF **2**
FILE NO. :