


PLAN SURVEYED, PLOTTED, REVISIONS, NOTE BOOK, BY, DATE, NO. OF WAY CHECKED, NO.

PROFILE SURVEYED, REVISIONS, NOTE BOOK, BY, DATE, NO. OF WAY CHECKED, NO.

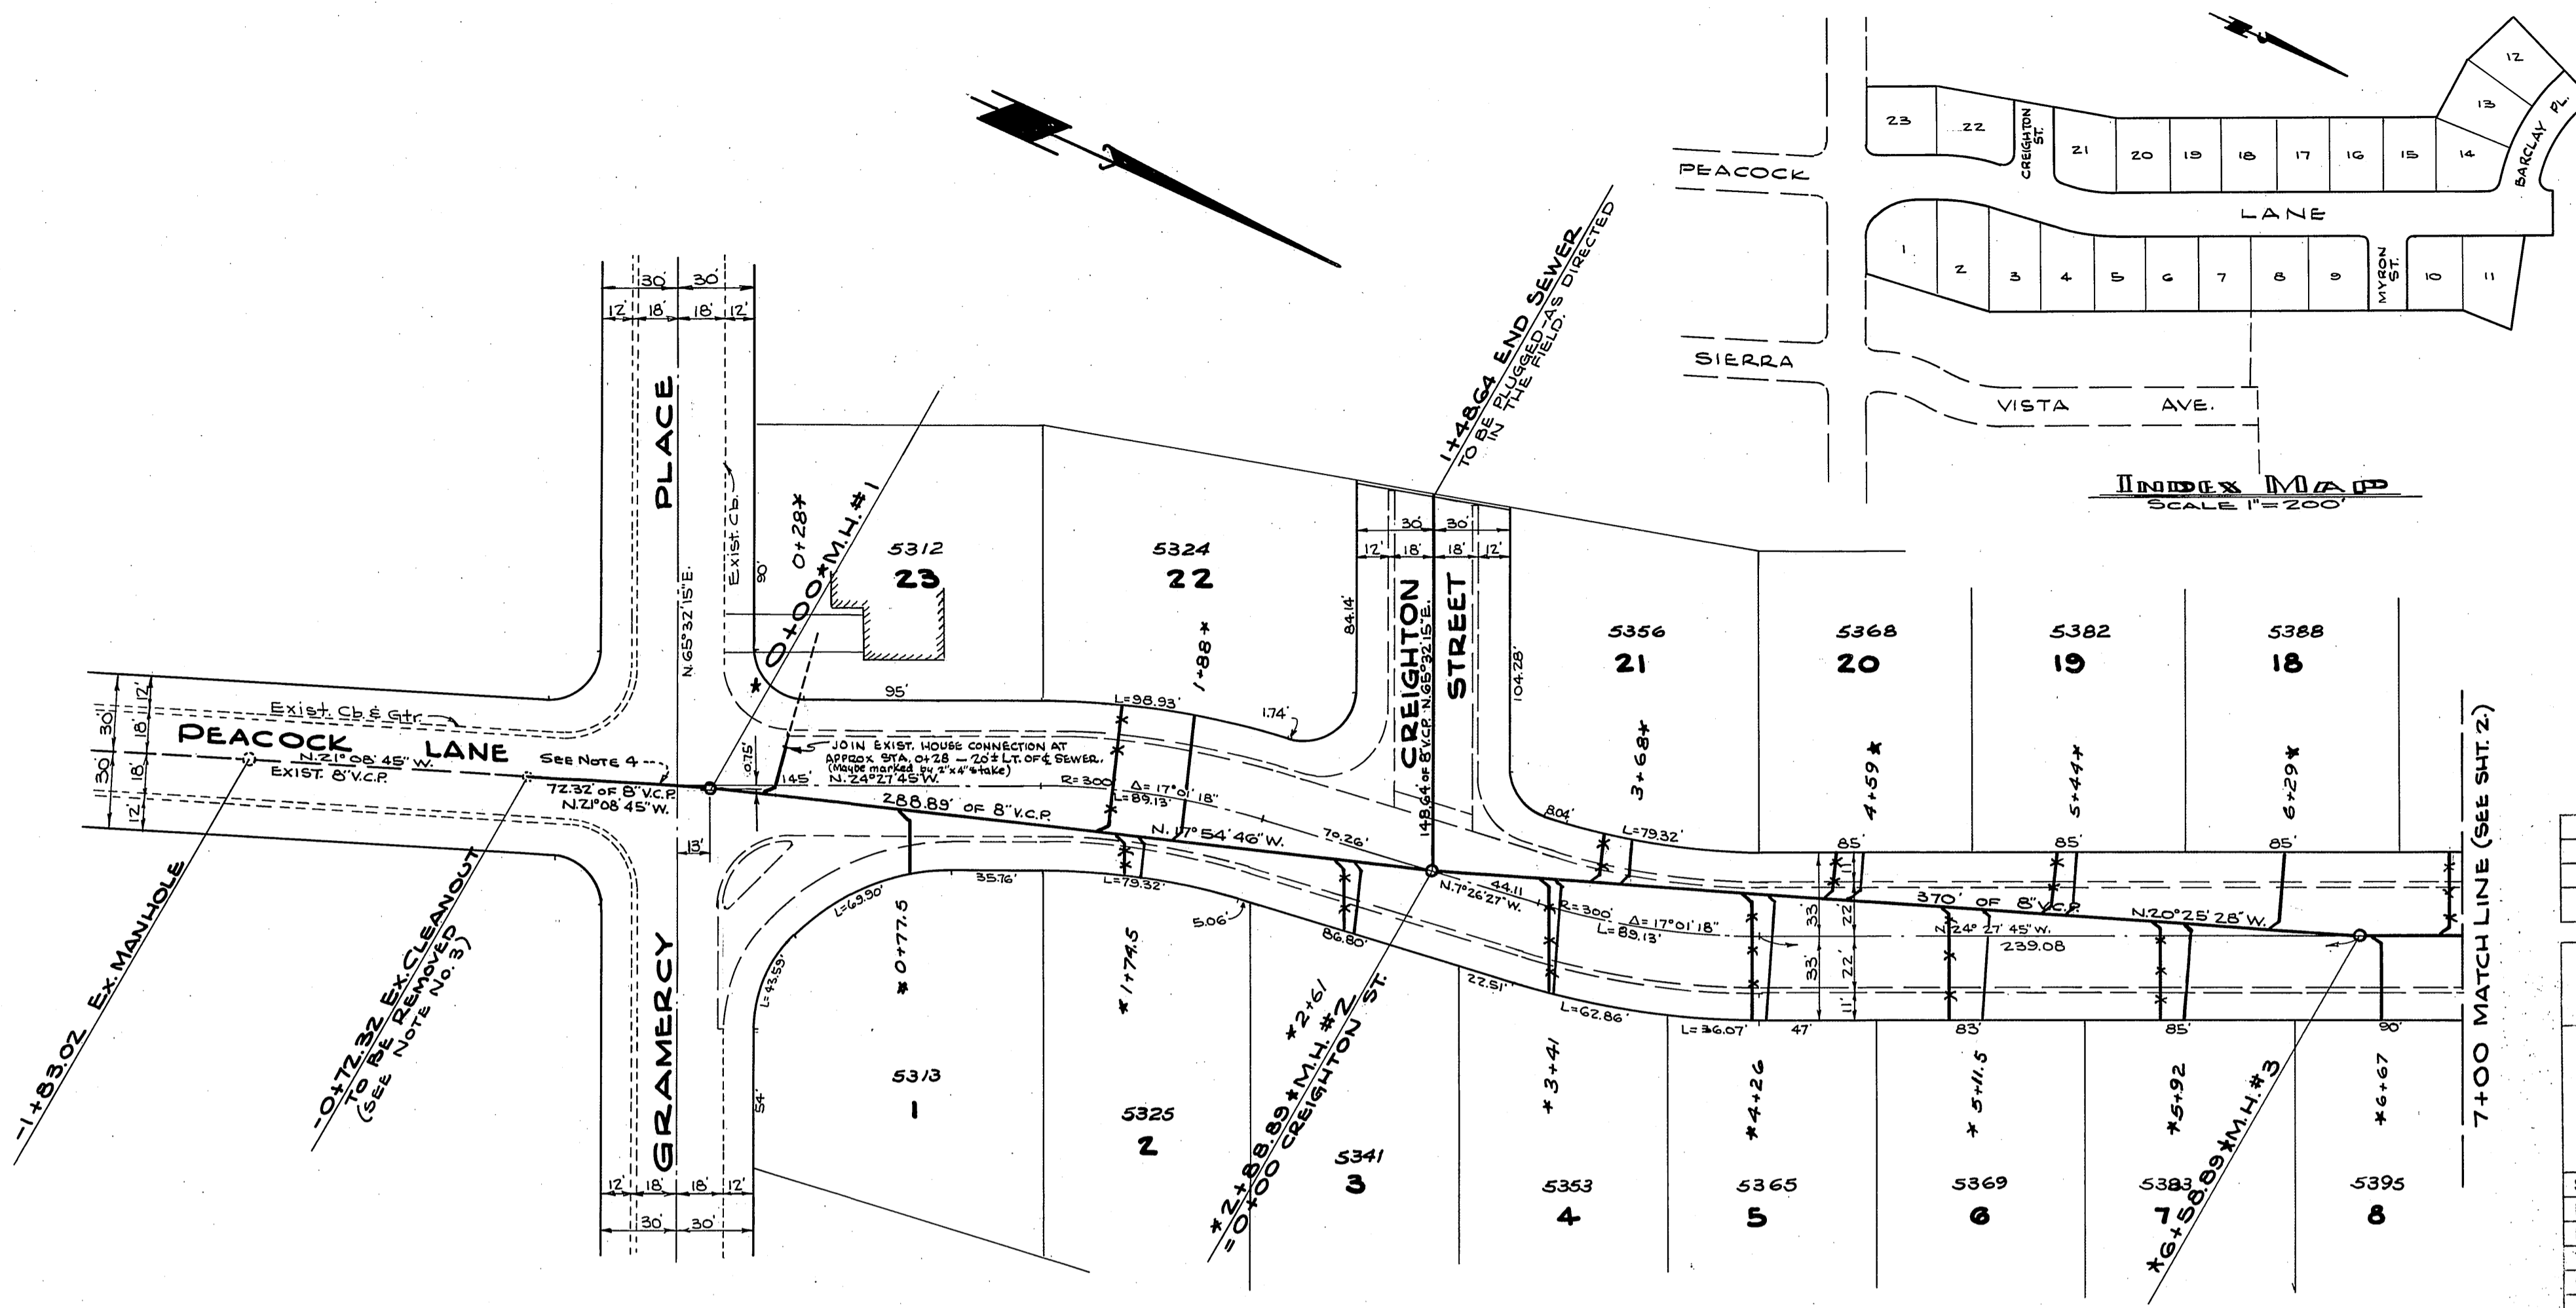

APPROVED *May 4 1962*
Edy N. Davidson, Mayor
 LA SIERRA COMMUNITY SERVICES DISTRICT

APPROVED *May 29 1962*
A.C. KEITH
 RIVERSIDE COUNTY ROAD COMMISSIONER
 By *Paul Stout* DEPUTY


"Approval of these plans by the Riverside County Road Commissioner does not relieve the Engineer of the responsibility for the Engineering design."

REVISIONS	DATE	BY

TRACT NO. 2360

SEWER PLAN AND PROFILE
PEACOCK LANE - CREIGHTON STREET

SCALE 1"=50'	ALBERT A. WEBB ASSOCIATES	W.O. 62-16
DATE MAR 1962	CIVIL ENGINEERS CALIFORNIA	SHEET 1
DRAWN <i>dw</i>		OF 2 SHEETS
TRACED	APPROVED BY <i>Albert A. Webb</i>	DWG. NO. 62-16 B
CHECKED	F.B. 354.437	

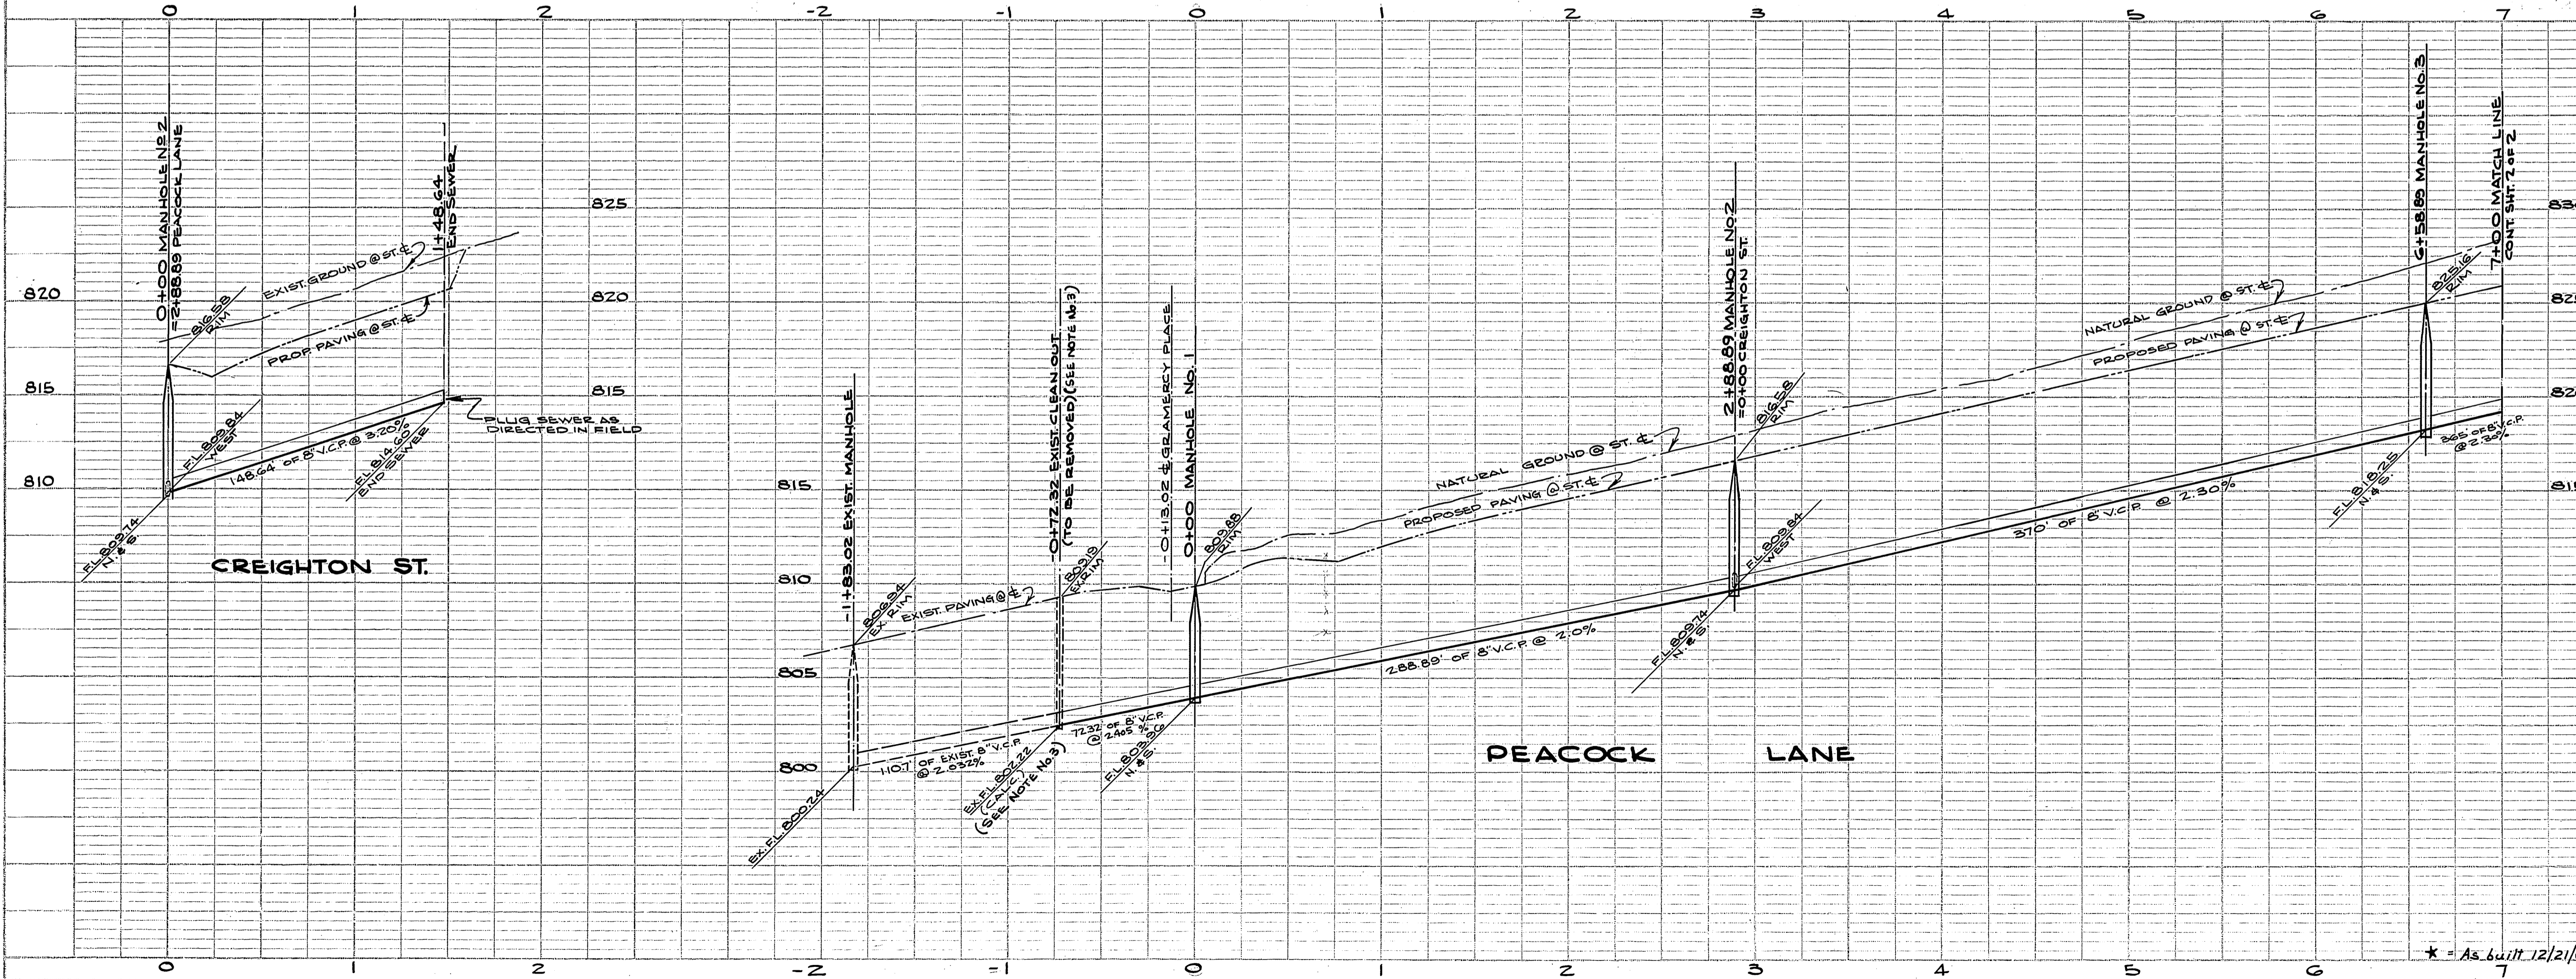

BENCH MARK:
 PER SPIKE IN WEST SIDE POWER POLE NO. 883746, LOCATED AT SE. CORNER OF SIERRA VISTA AVE & GERNEY WAY ELEV. 793.40 F.D. 354.72

- GENERAL NOTES:**
1. LOCATION OF WYES AND HOUSE CONNECTIONS LATERALS TO BE DETERMINED IN THE FIELD.
 2. MANHOLE FRAMES AND COVERS TO BE SET TO EXISTING FINISH GRADES UNLESS ELEVATION IS GIVEN IN PROFILE.
 3. PRIOR TO THE CONSTRUCTION OF SEWER, CONTRACTOR IS TO EXCAVE AND NOTIFY ALL UTILITIES FOR VERIFICATION OF ELEVATION OF EXISTING SEWER AT EX. CO. (0+72.32) PEACOCK LANE (SEE VERIFIED AS SHOWN ON PLAN) MAY 9, 1962.
 4. PERMANENT PAVING AFTER BACKFILL TO BE THE RESPONSIBILITY OF THE PAVING CONTRACTOR.

QUANTITY ESTIMATE

8" VITRIFIED CLAY PIPE	1565 L.F.
4" VITRIFIED CLAY PIPE	790 L.F.
8"x4" WYES	23 EA.
MANHOLES	5 EA.

PROPERTY OF
 COUNTY OF RIVERSIDE
 Office of the Road Commissioner


RIVERSIDE COUNTY HEALTH DEPARTMENT

FOOD ESTABLISHMENT	SEWAGE DISPOSAL
TRUCKER PARK	100' SEPTIC TANK
MOTEL APT. HOTEL	50' FT. OF LEACH LINE
DWELLING	X SEWAGE FIT
COMMERCIAL BUILDING	CONNECTION TO SEWER
WATER SOURCE	X SEWER LINE LAYOUT
WATER LINE LAYOUT	SWIMMING POOL

This is to Certify that the Riverside County Health Department Approves for Occupancy, Construction or Installation the Item(s) Checked Above.
 Date *5-8-62* By *Edy N. Davidson*

PLAN	SURVEYED	DATE
	PLOTTED	
	NOTE BOOK	
	BY	
	NO.	

PROFILE	SURVEYED	DATE
	GRADES CHECKED	
	B. M. NOTED	
	STRUCTURE NOTATIONS CHECKED	
	NO.	

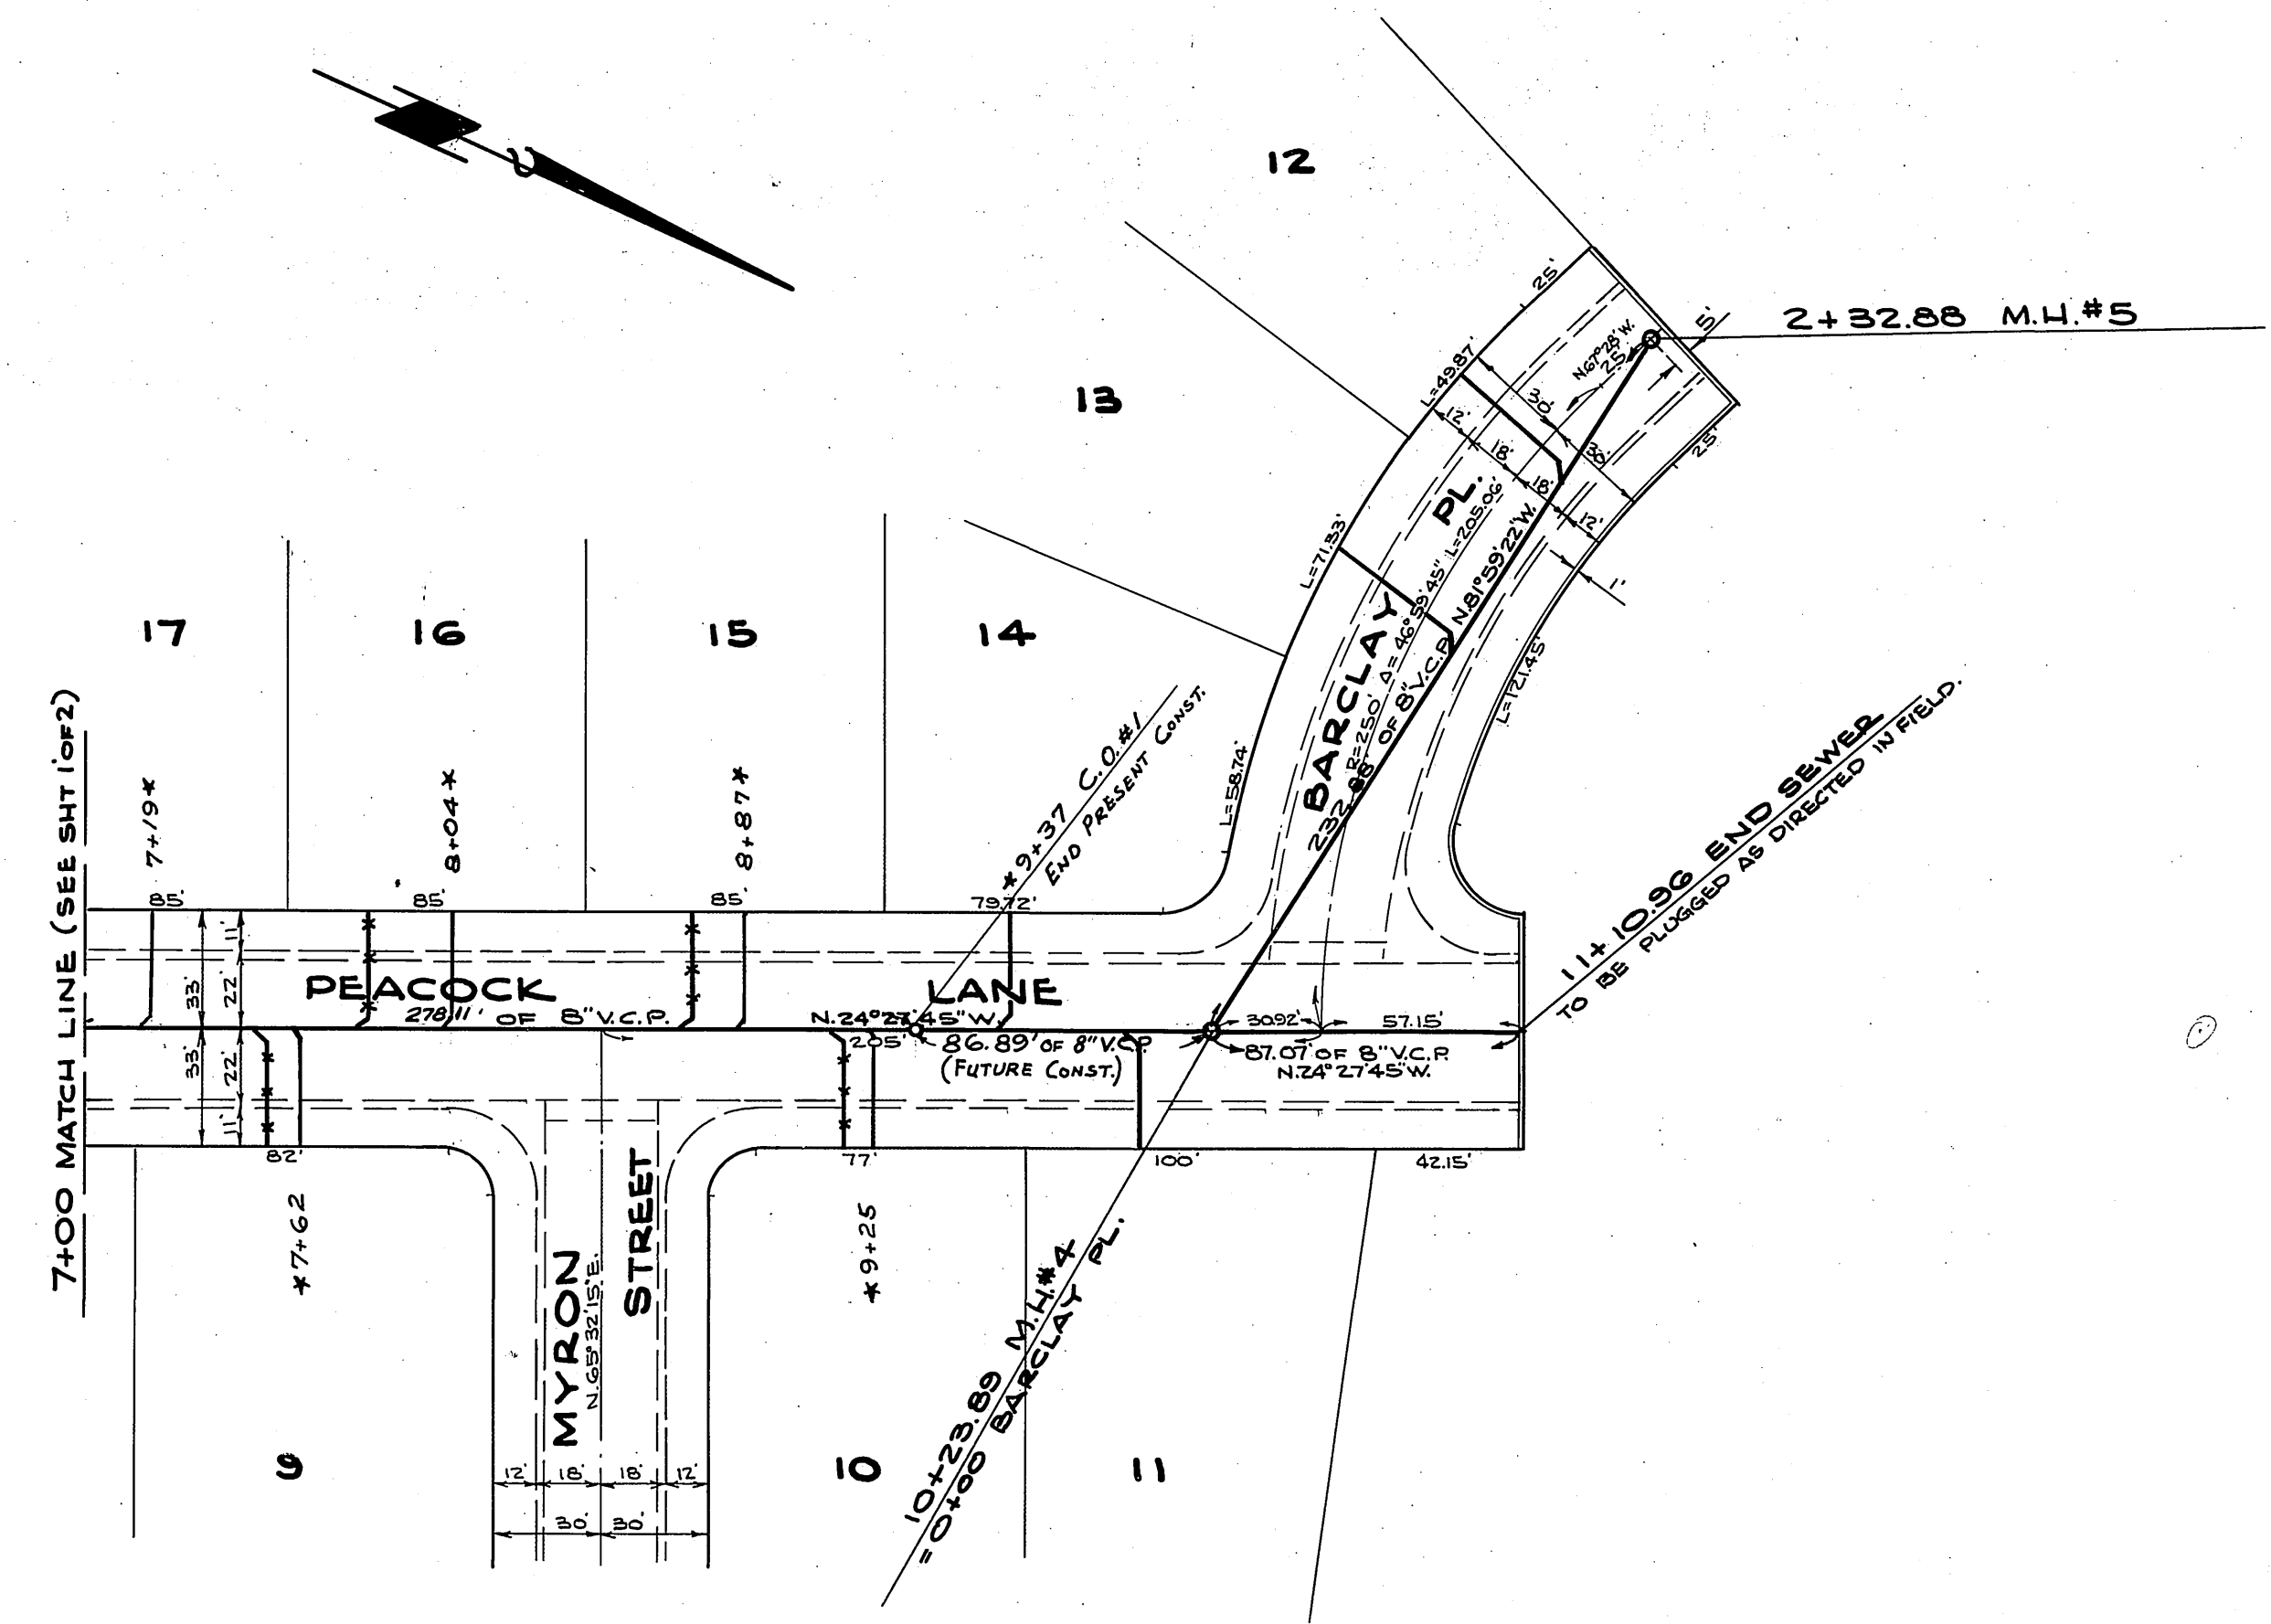

VISIONS	DATE	BY

TRACT NO. 2360

SEWER PLAN AND PROFILE

PEACOCK LANE - BARCLAY PLACE

1" = 50'

MAR 1962

44-

354-437

HERT A. WEBB ASSOCIATES
CIVIL ENGINEERS

ERIC S. WEBB
CALIFORNIA
P.E. 9876

NO. 62-16
SHEET
2
OF 2 SHEETS
DWG. NO.
62-16B

